 
 Key: Firewall- all penetrations must be firestopped
 All penetrations into floors must be firestopped


1 ANN STUART SCIENCE BUILDING
 1ST FLOOR PLAN

SCALE: 1/32" = 1'-0"

GRAPHIC SCALE




LEGEND	
FIRE PULL	FIRE
FIRE EXTINGUISHER	FE
FIRE EXT IN CABINET	FE
EYEWASH STATION	EW

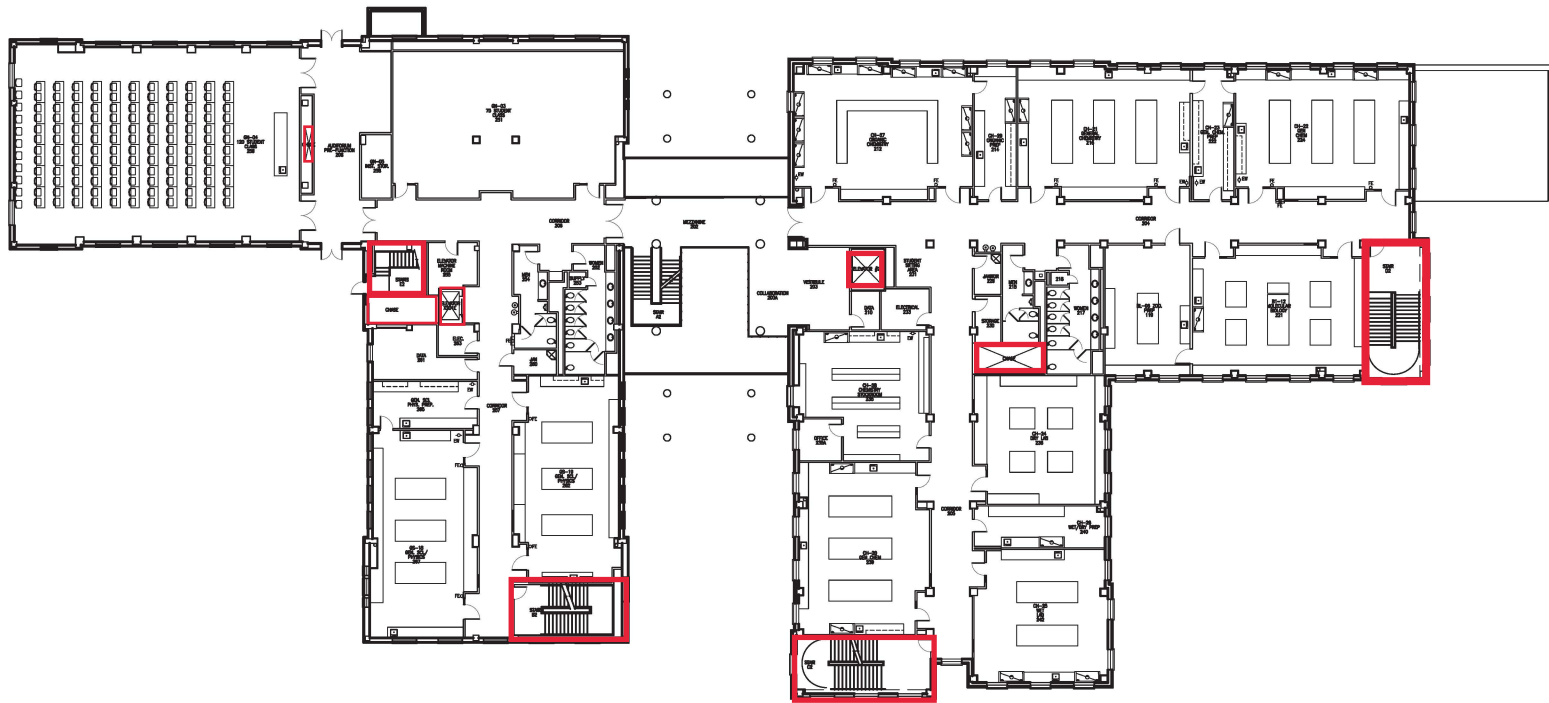


Key: Firewall- all
penetrations must be
firestopped
All penetrations into floors
must be firestopped

 1 ANN STUART SCIENCE BUILDING
2ND FLOOR PLAN
SCALE: 1/32" = 1'-0"




LEGEND	
FIRE PULL	FIRE
FIRE EXTINGUISHER	FE
FIRE EXT IN CABINET	FECD
EYEWASH STATION	EW

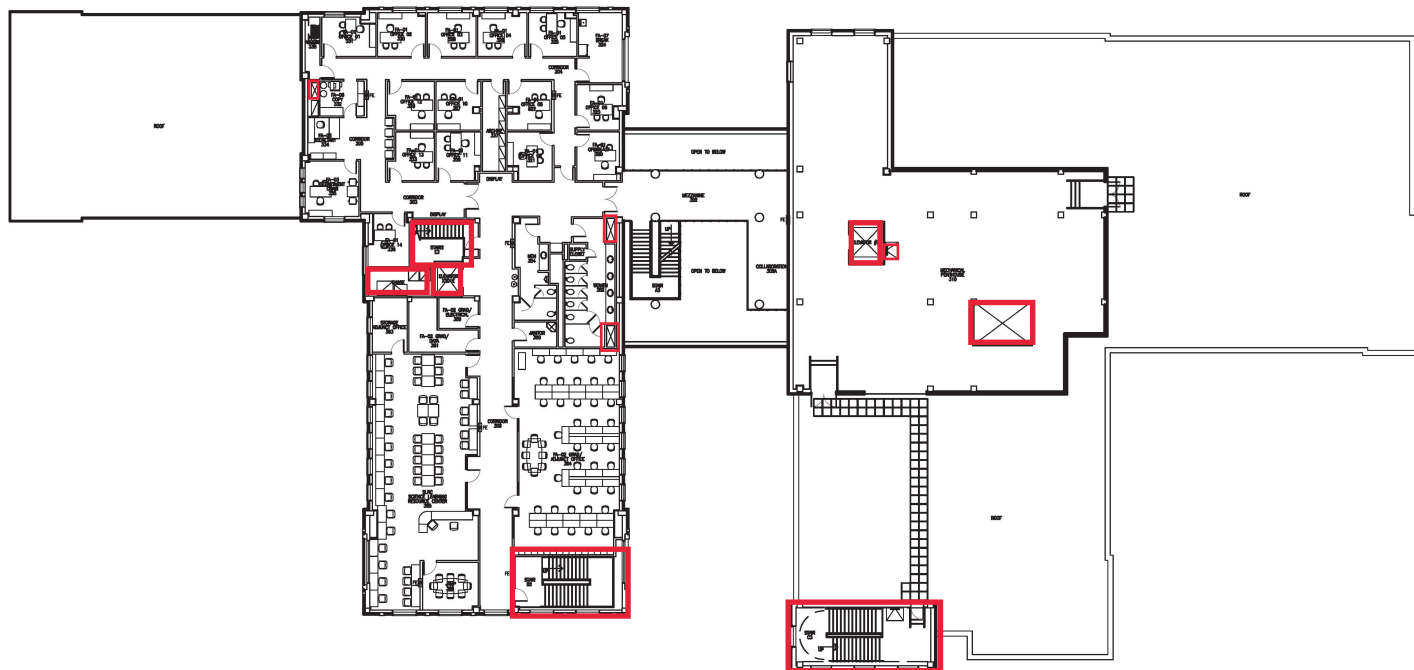


Key: Firewall- all penetrations must be firestopped
 All penetrations into floors must be firestopped

1 ANN STUART SCIENCE BUILDING
 3RD FLOOR PLAN

 SCALE: 1/32" = 1'-0"



LEGEND	
FIRE PULL	FIRE
FIRE EXTINGUISHER	FE
FIRE EXT IN CABINET	FECD
EYEWASH STATION	EW

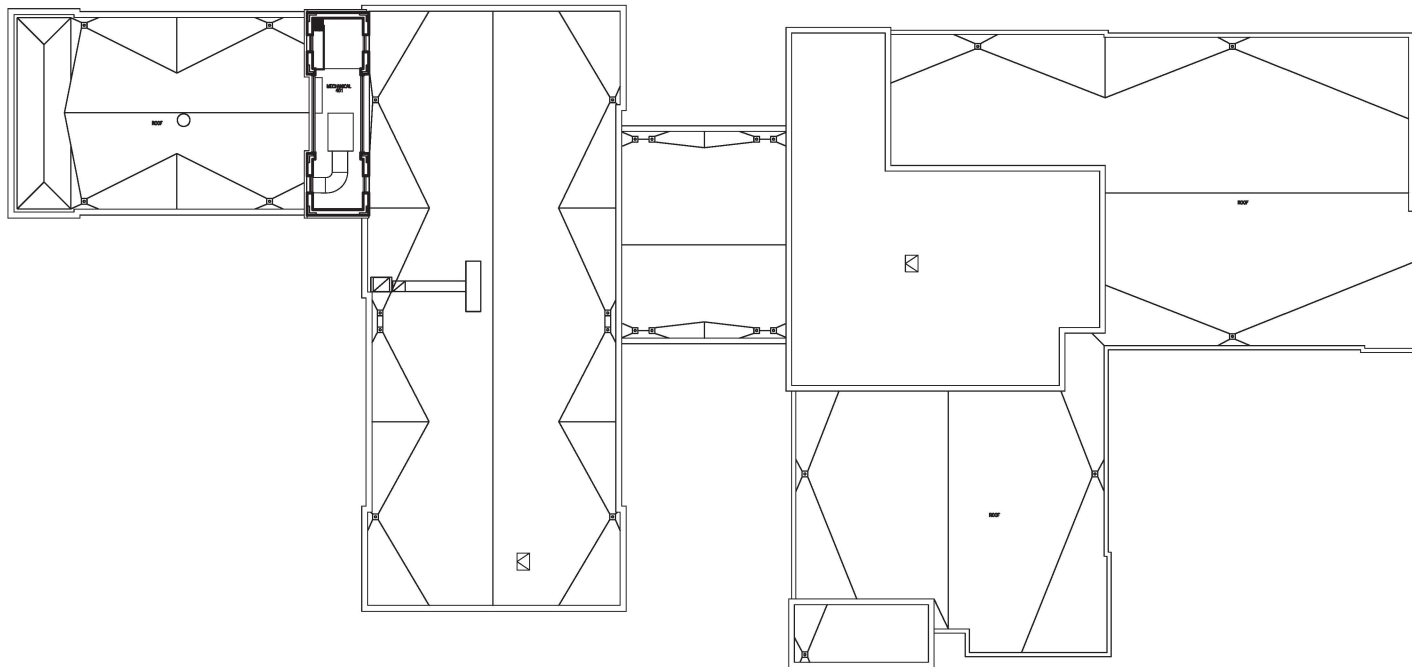


Key: Firewall- all
 penetrations must be
 firestopped
 All penetrations into floors
 must be firestopped

1 ANN STUART SCIENCE BUILDING
 4TH FLOOR PLAN

SCALE: 1/32" = 1'-0"

 GRAPHIC SCALE



LEGEND	
FIRE PULL	FIRE
FIRE EXTINGUISHER	FE
FIRE EXT IN CABINET	FECD
EYEWASH STATION	EW