


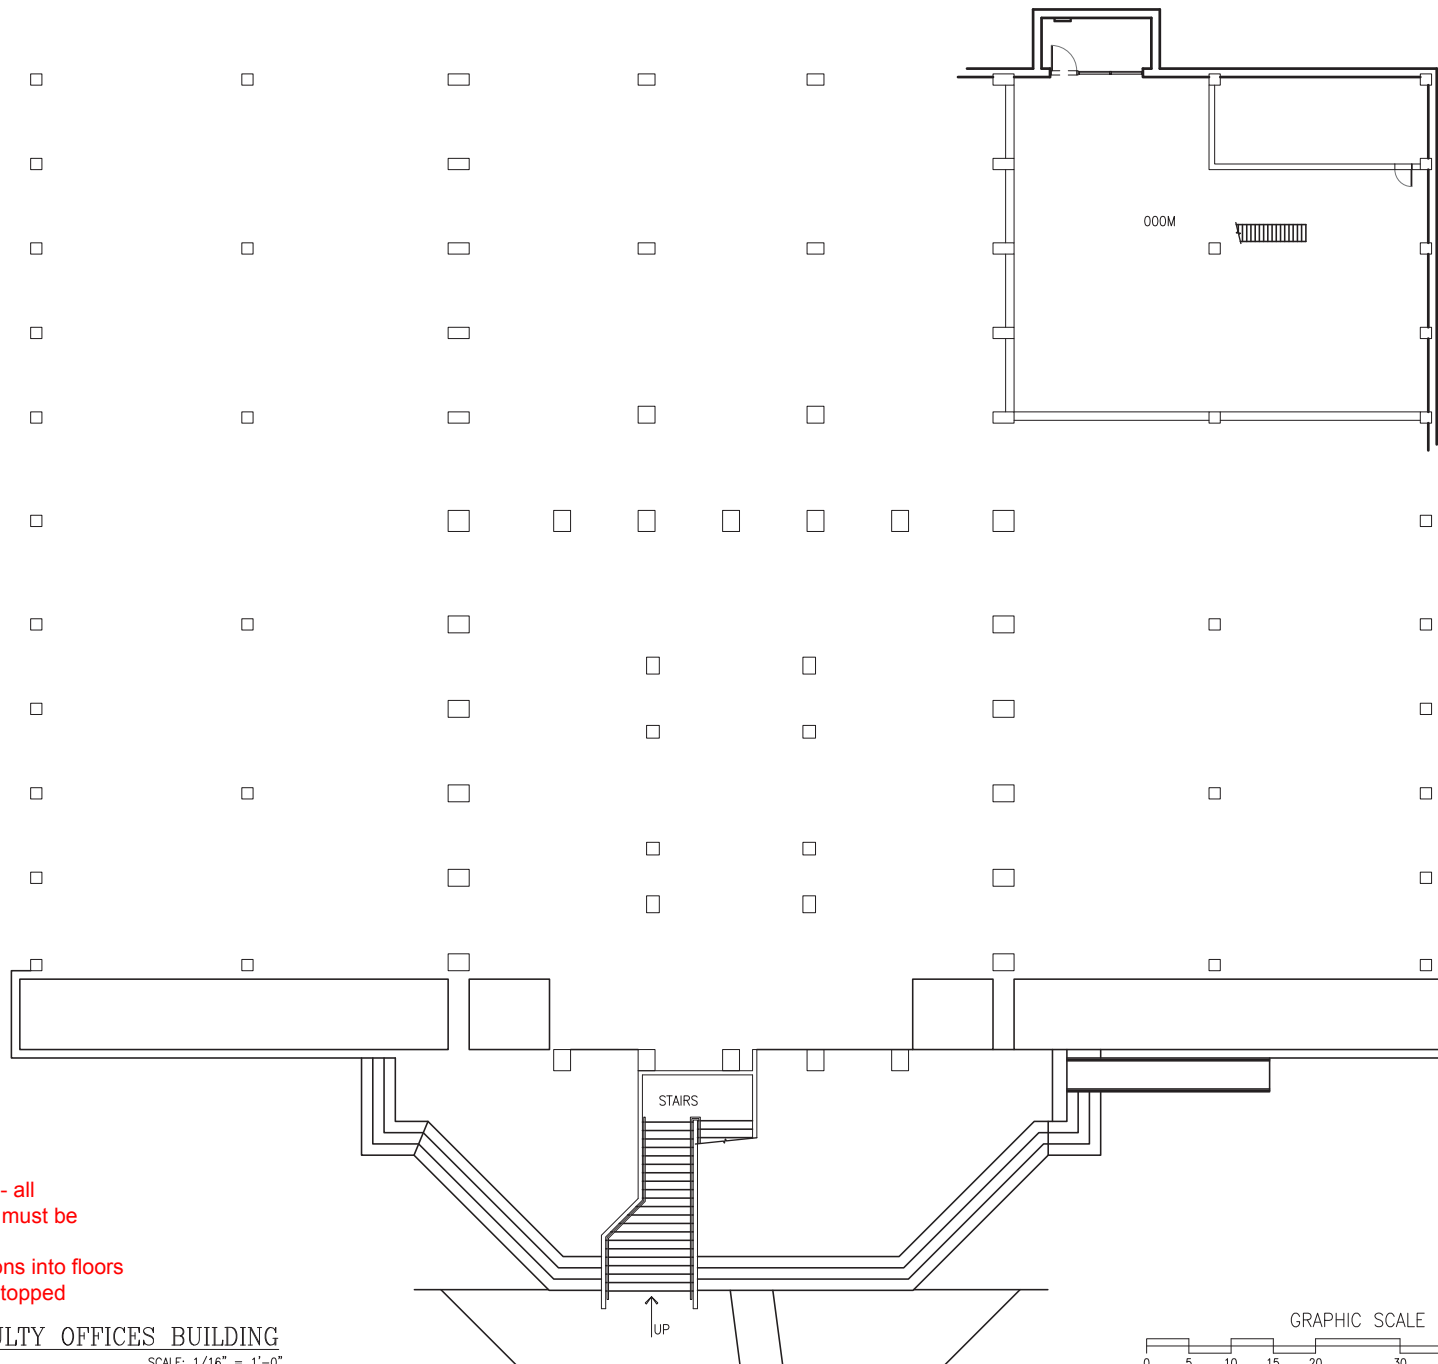


Key: Firewall- all
 penetrations must be
 firestopped
 All penetrations into floors
 must be firestopped

1 CLASSROOM FACULTY OFFICES BUILDING
 BASEMENT PLAN

SCALE: 1/16" = 1'-0"



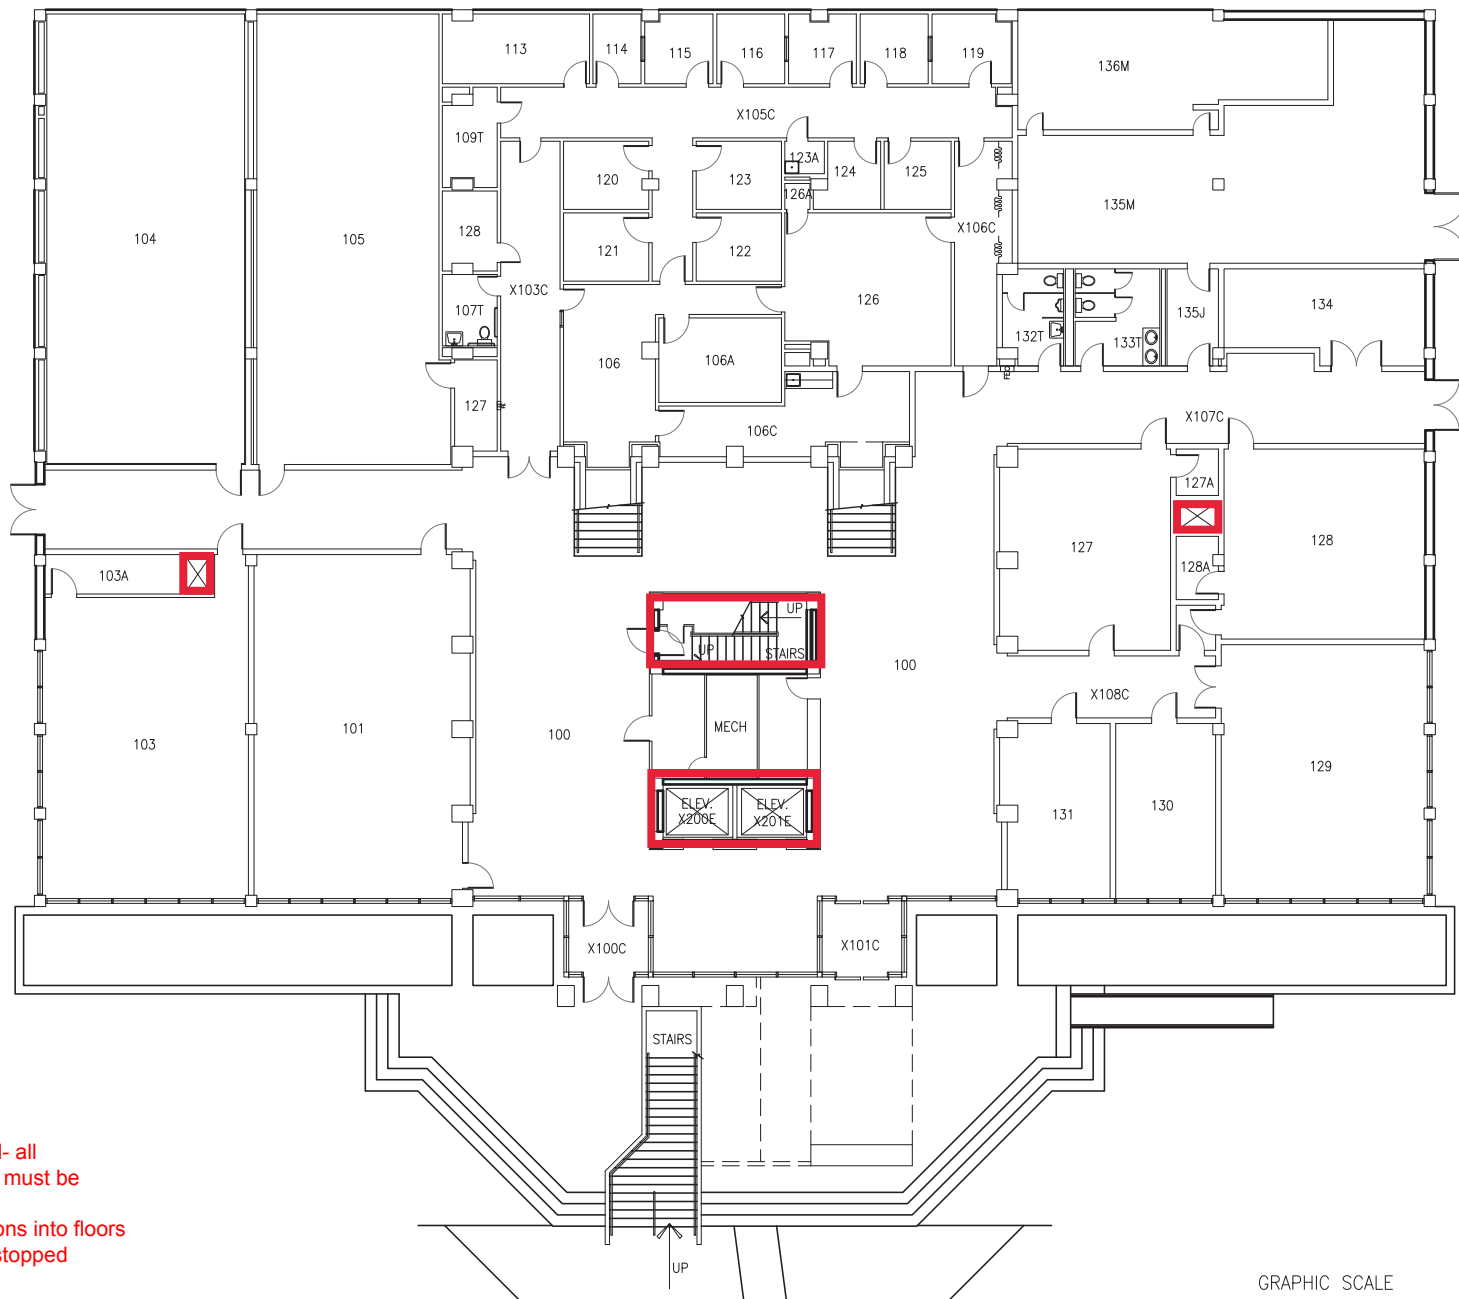



Key: Firewall- all penetrations must be firestopped
 All penetrations into floors must be firestopped

1 CLASSROOM FACULTY OFFICES BUILDING
 1ST FLOOR PLAN


SCALE: 1/16" = 1'-0"




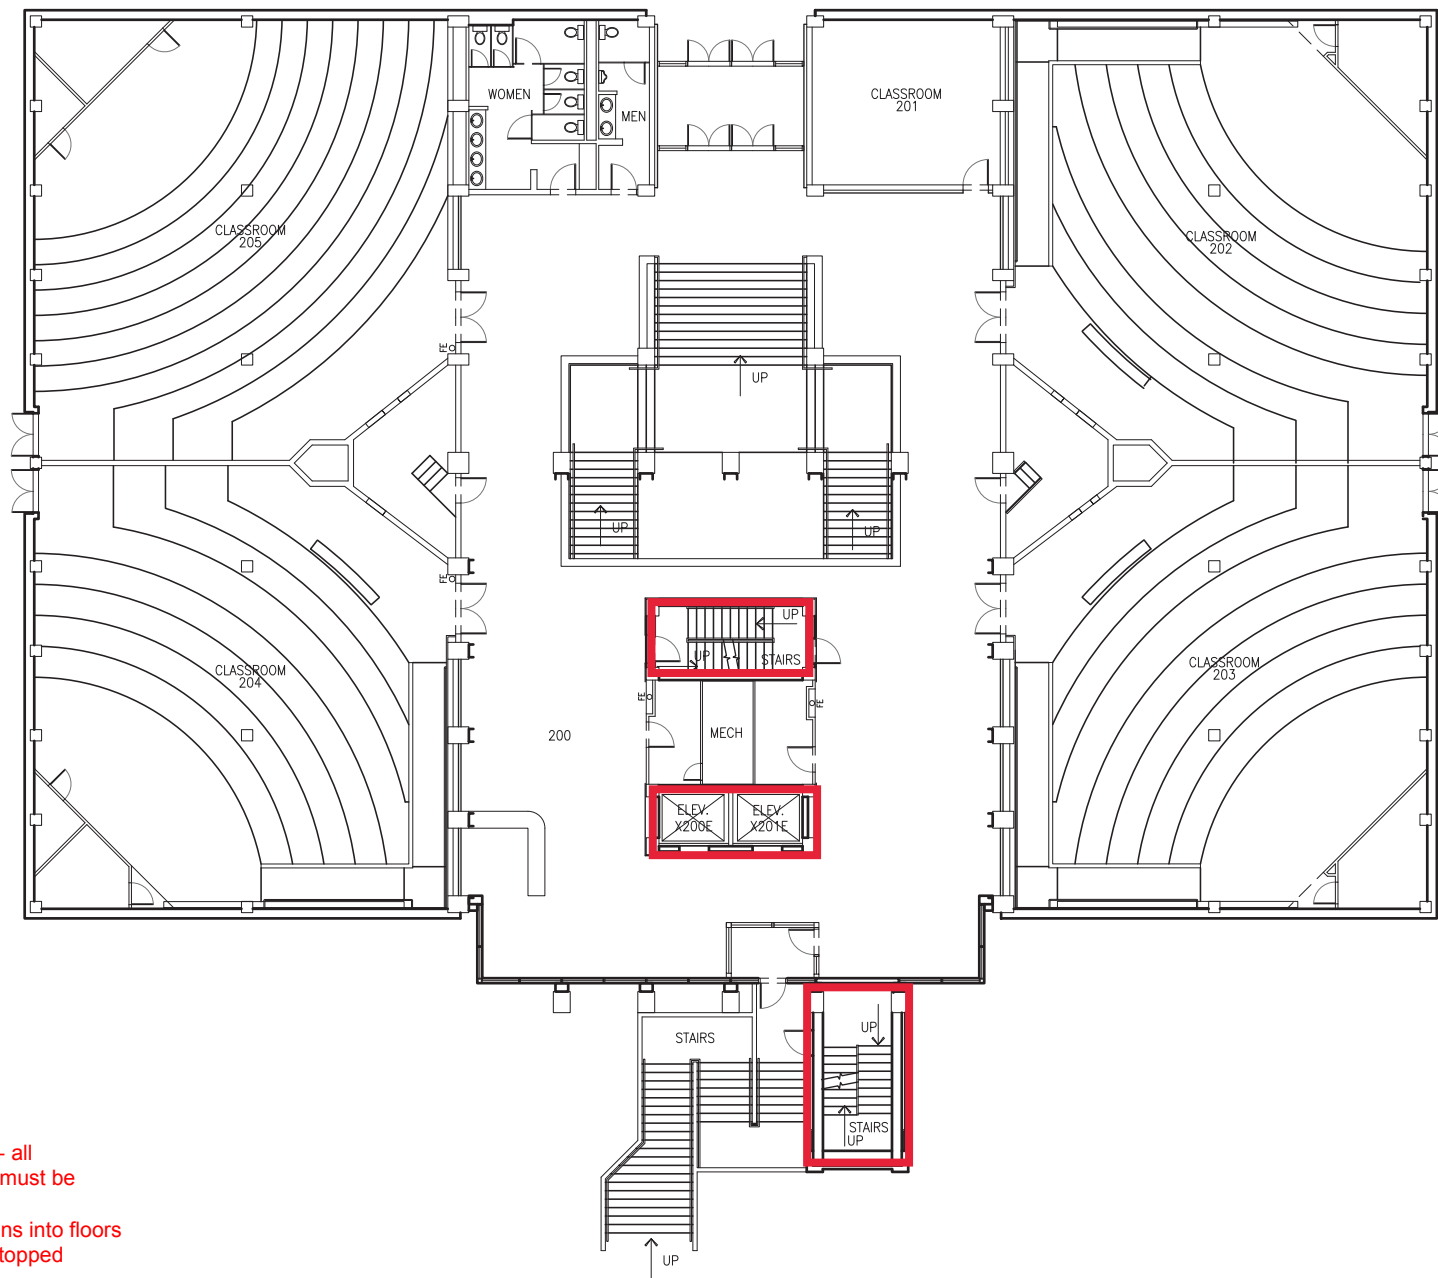

Key: Firewall- all penetrations must be firestopped
 All penetrations into floors must be firestopped

 1 CLASSROOM FACULTY OFFICES BUILDING
 2ND FLOOR PLAN
 SCALE: 1/16" = 1'-0"



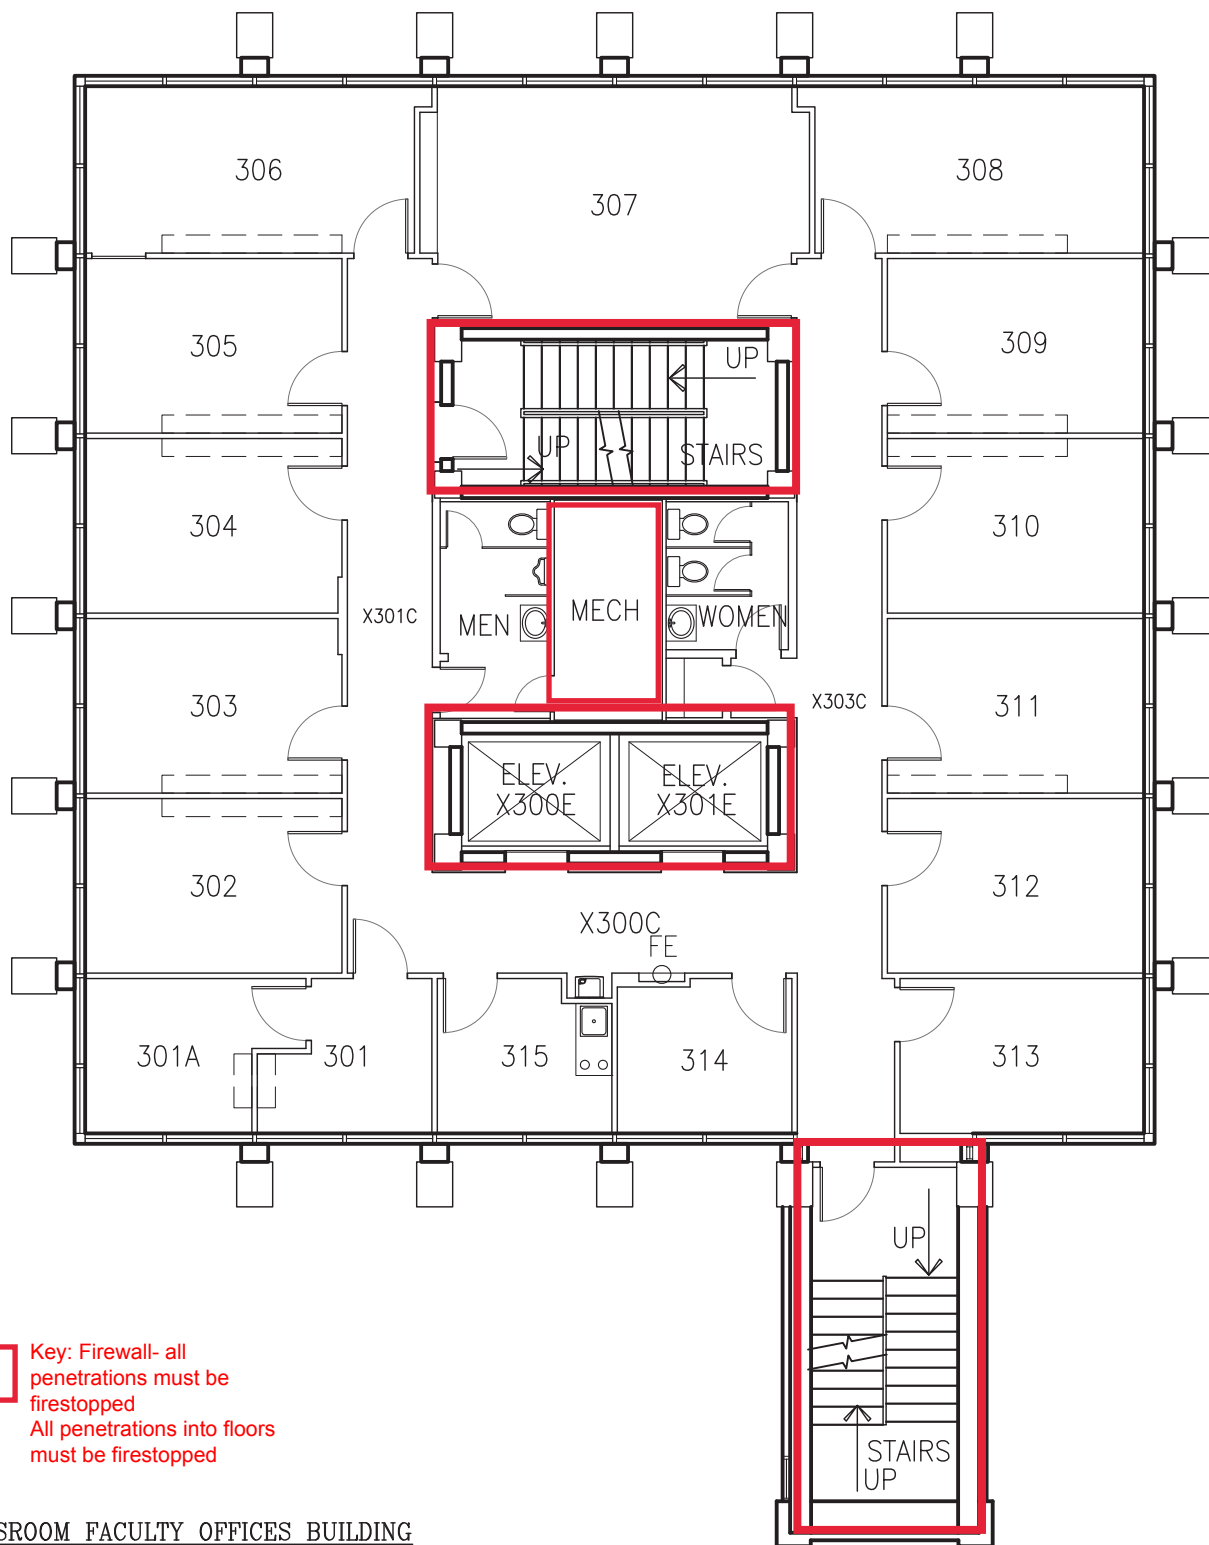


 Key: Firewall- all penetrations must be firestopped
All penetrations into floors must be firestopped


1 CLASSROOM FACULTY OFFICES BUILDING
3RD FLOOR PLAN

SCALE: 3/32" = 1'-0"

 GRAPHIC SCALE



LEGEND	
FIRE PULL	FIRE
FIRE EXTINGUISHER	FE

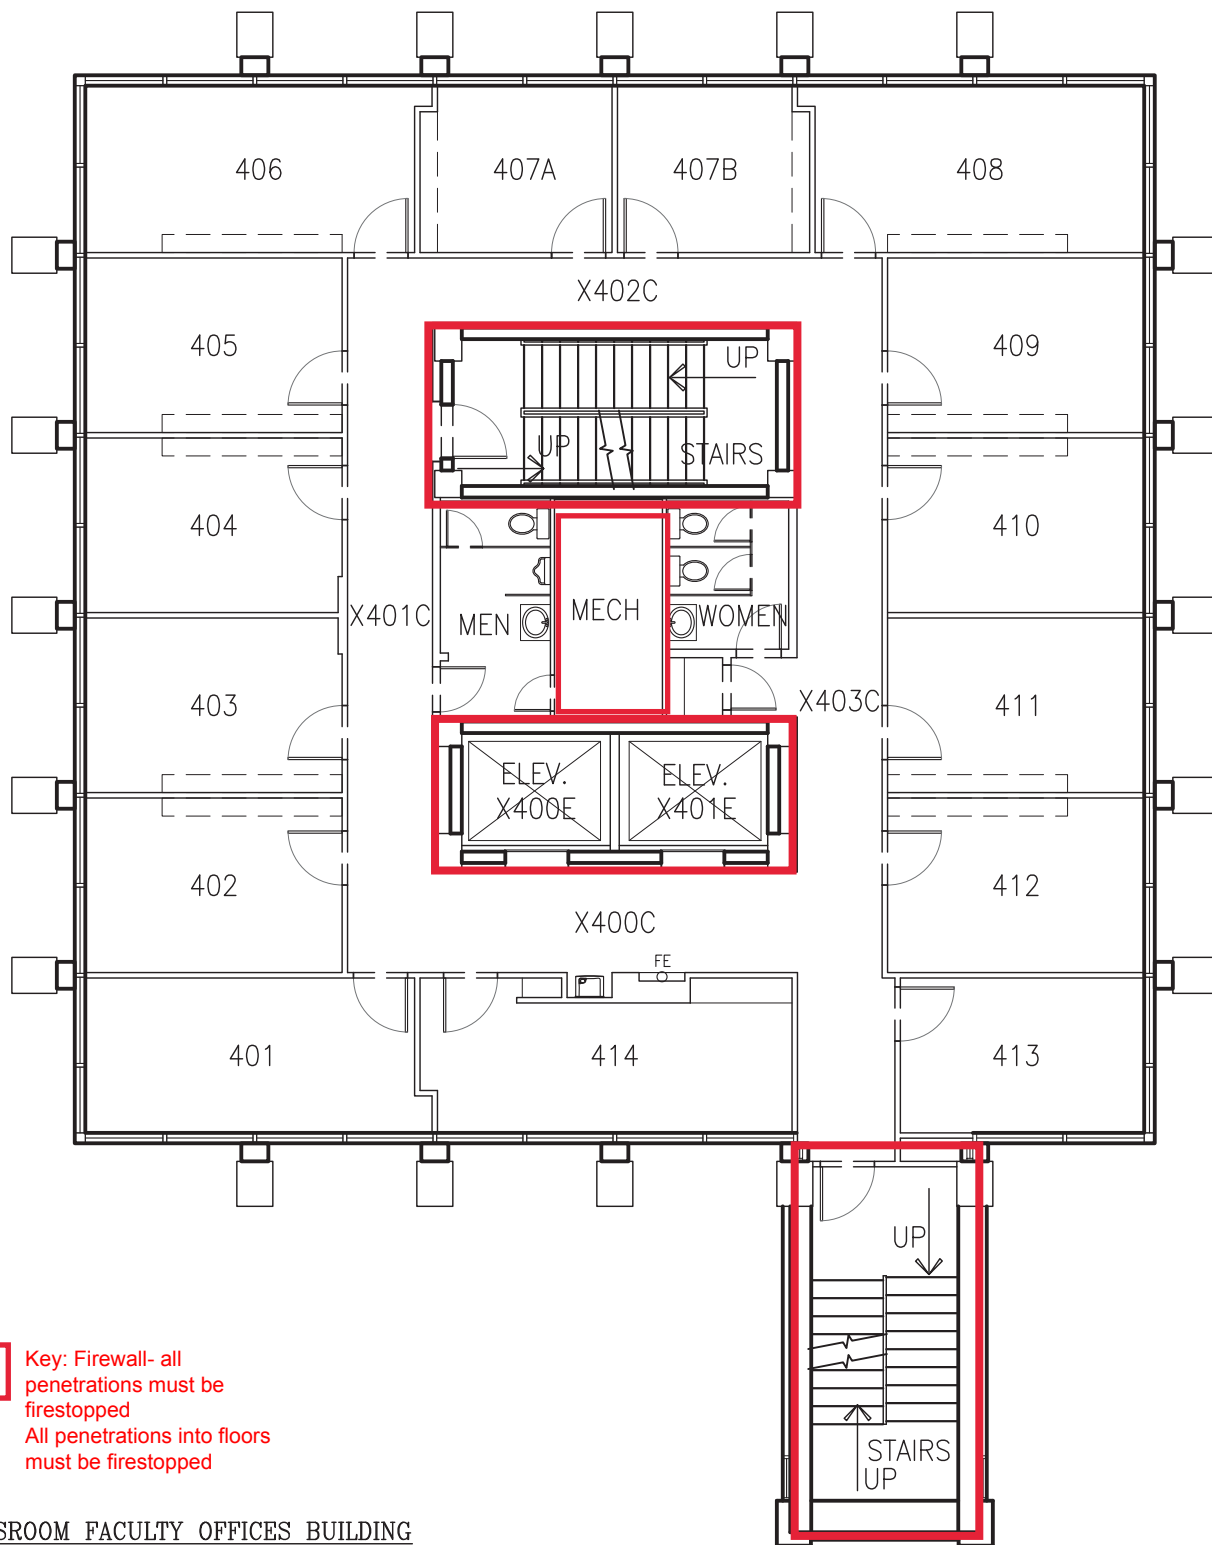


Key: Firewall- all
penetrations must be
firestopped
All penetrations into floors
must be firestopped

1 CLASSROOM FACULTY OFFICES BUILDING
4TH FLOOR PLAN SCALE: 3/32" = 1'-0"

GRAPHIC SCALE



LEGEND	
FIRE PULL	FIRE
FIRE EXTINGUISHER	FE

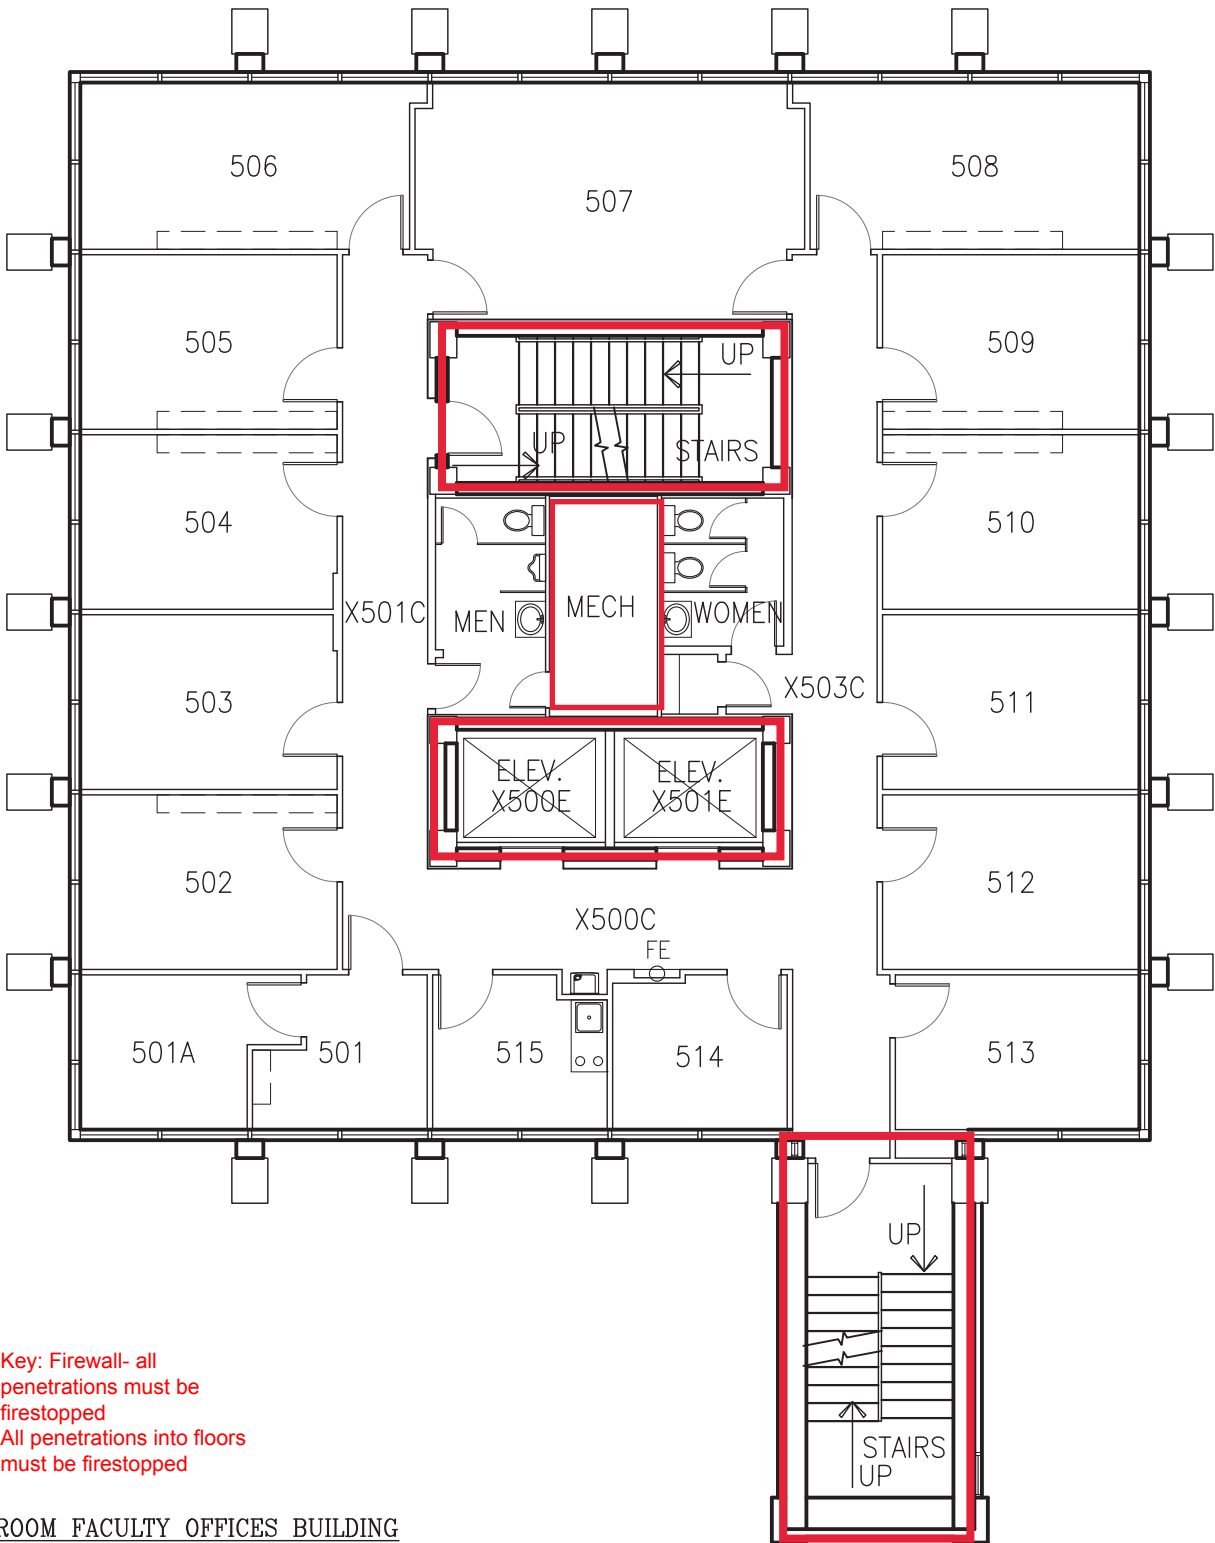



Key: Firewall- all penetrations must be firestopped
 All penetrations into floors must be firestopped


1 CLASSROOM FACULTY OFFICES BUILDING
 5TH FLOOR PLAN

SCALE: 3/32" = 1'-0"

 GRAPHIC SCALE




LEGEND	
FIRE PULL	FIRE
FIRE EXTINGUISHER	FE

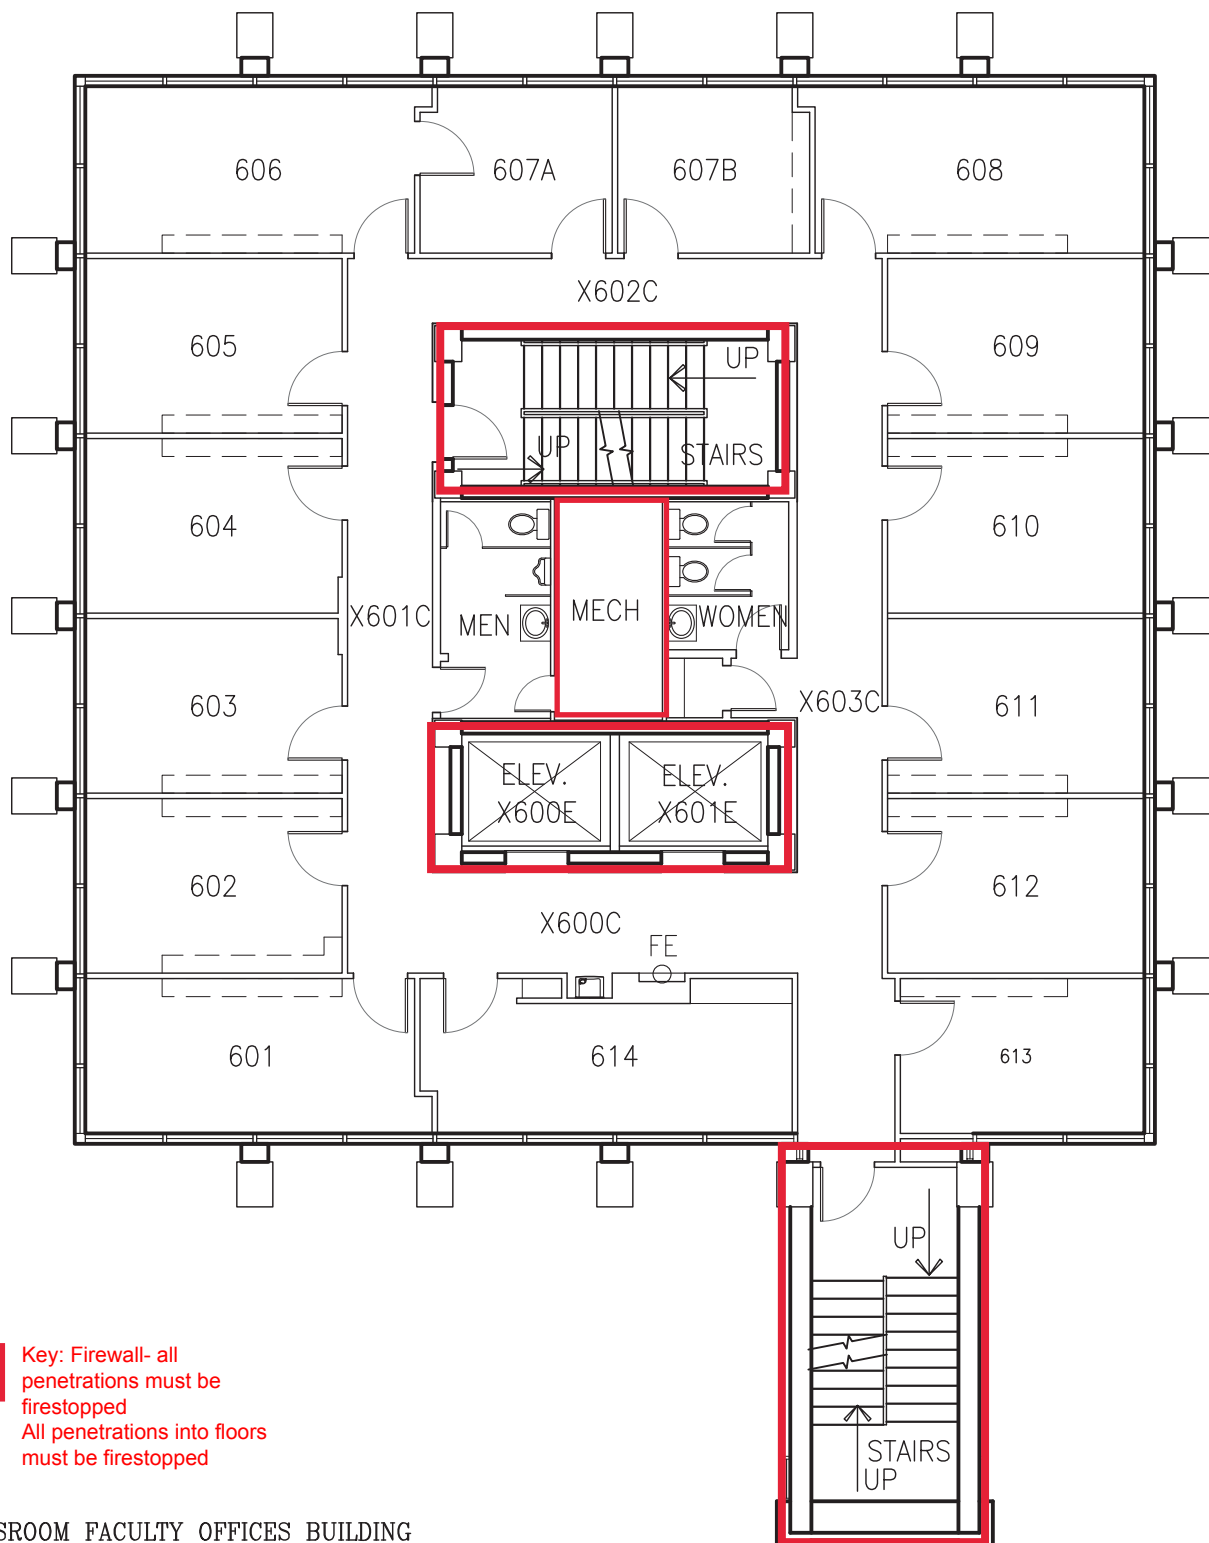


Key: Firewall- all penetrations must be firestopped
All penetrations into floors must be firestopped

1 CLASSROOM FACULTY OFFICES BUILDING
6TH FLOOR PLAN SCALE: 3/32" = 1'-0"

 GRAPHIC SCALE




LEGEND	
FIRE PULL	FIRE
FIRE EXTINGUISHER	FE

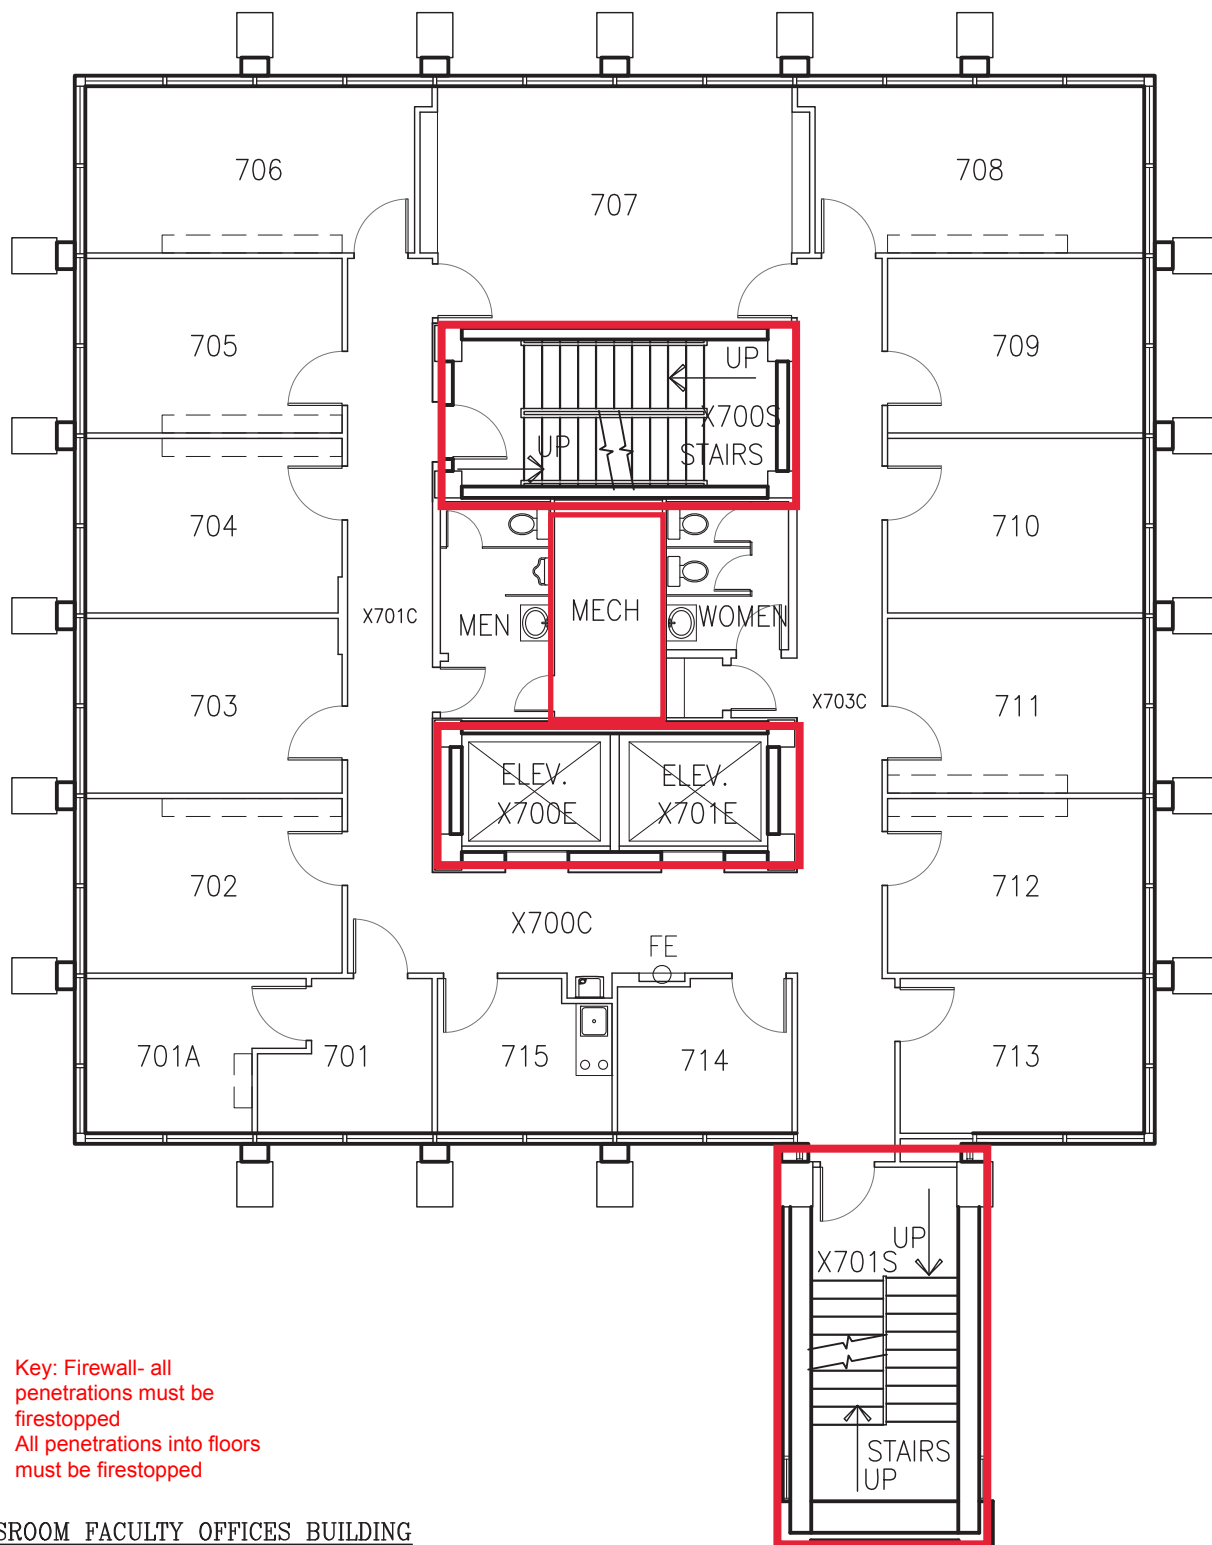


 Key: Firewall- all penetrations must be firestopped
 All penetrations into floors must be firestopped

1 CLASSROOM FACULTY OFFICES BUILDING
 7TH FLOOR PLAN SCALE: 3/32" = 1'-0"

 GRAPHIC SCALE




LEGEND	
FIRE PULL	FIRE
FIRE EXTINGUISHER	FE

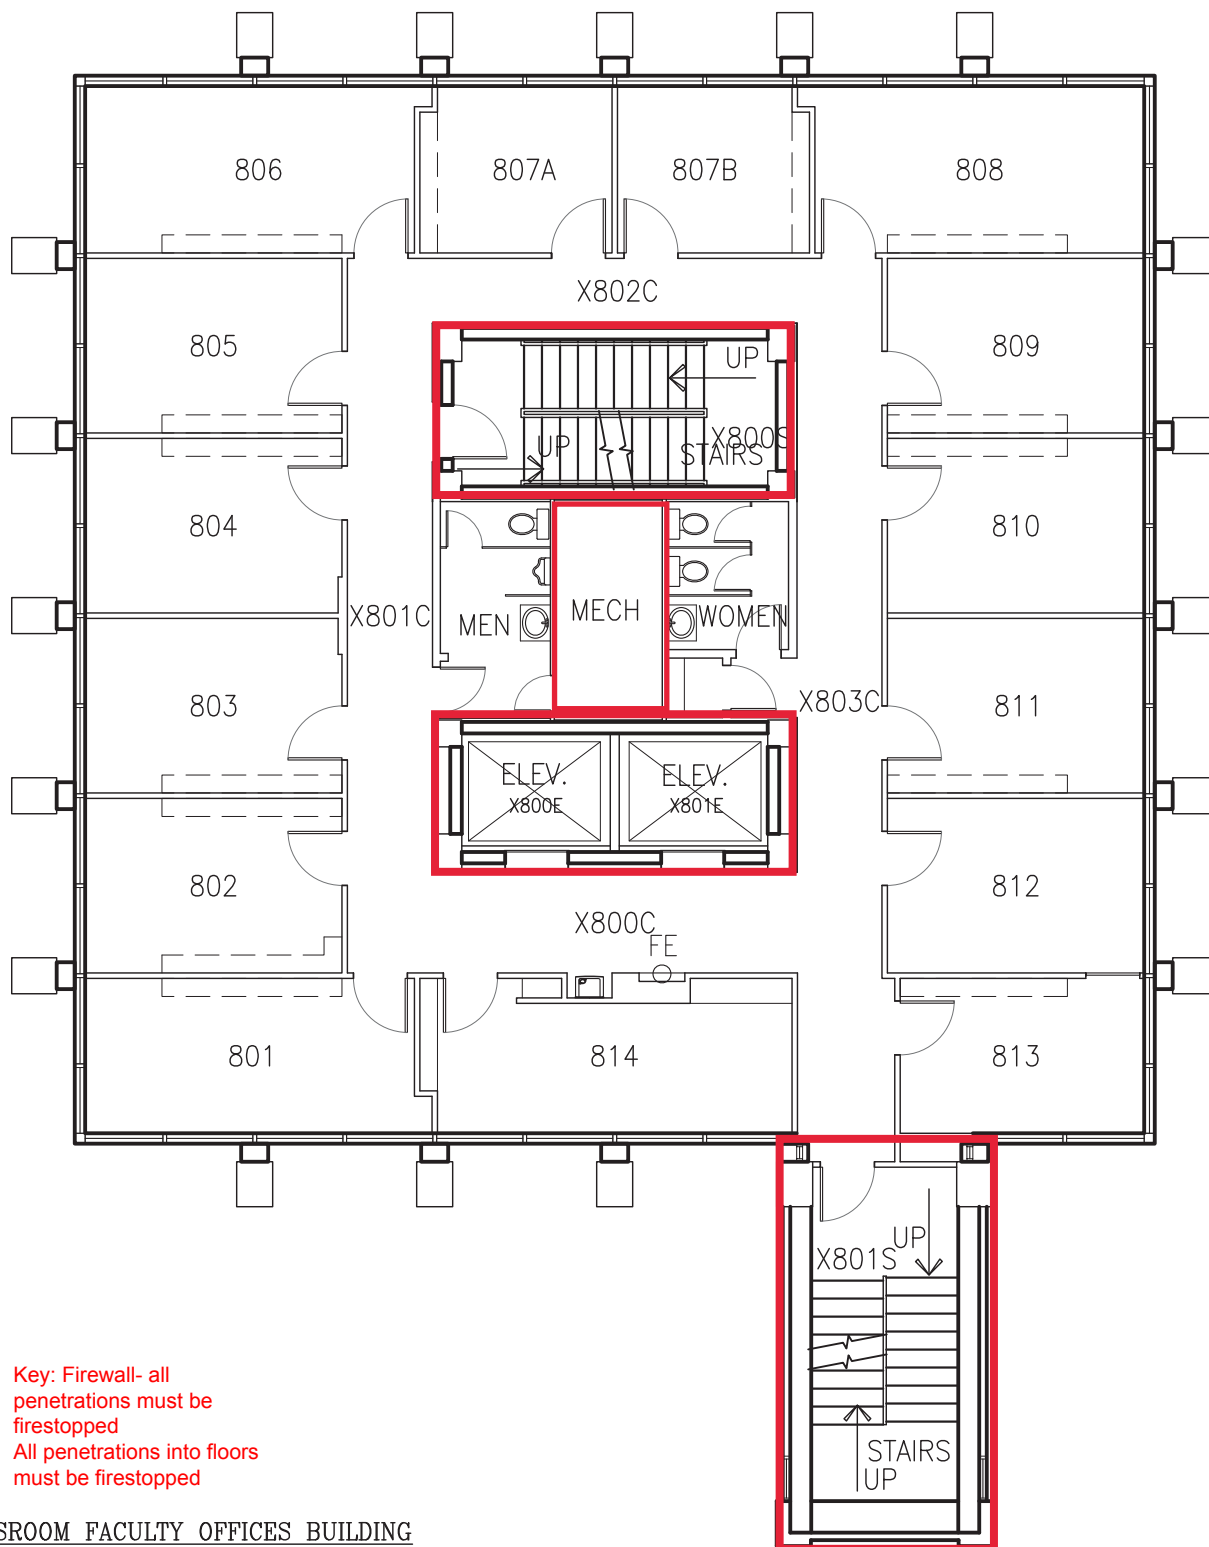


Key: Firewall- all penetrations must be firestopped
All penetrations into floors must be firestopped

1 CLASSROOM FACULTY OFFICES BUILDING
8TH FLOOR PLAN SCALE: 3/32" = 1'-0"

 GRAPHIC SCALE



LEGEND	
FIRE PULL	FIRE
FIRE EXTINGUISHER	FE

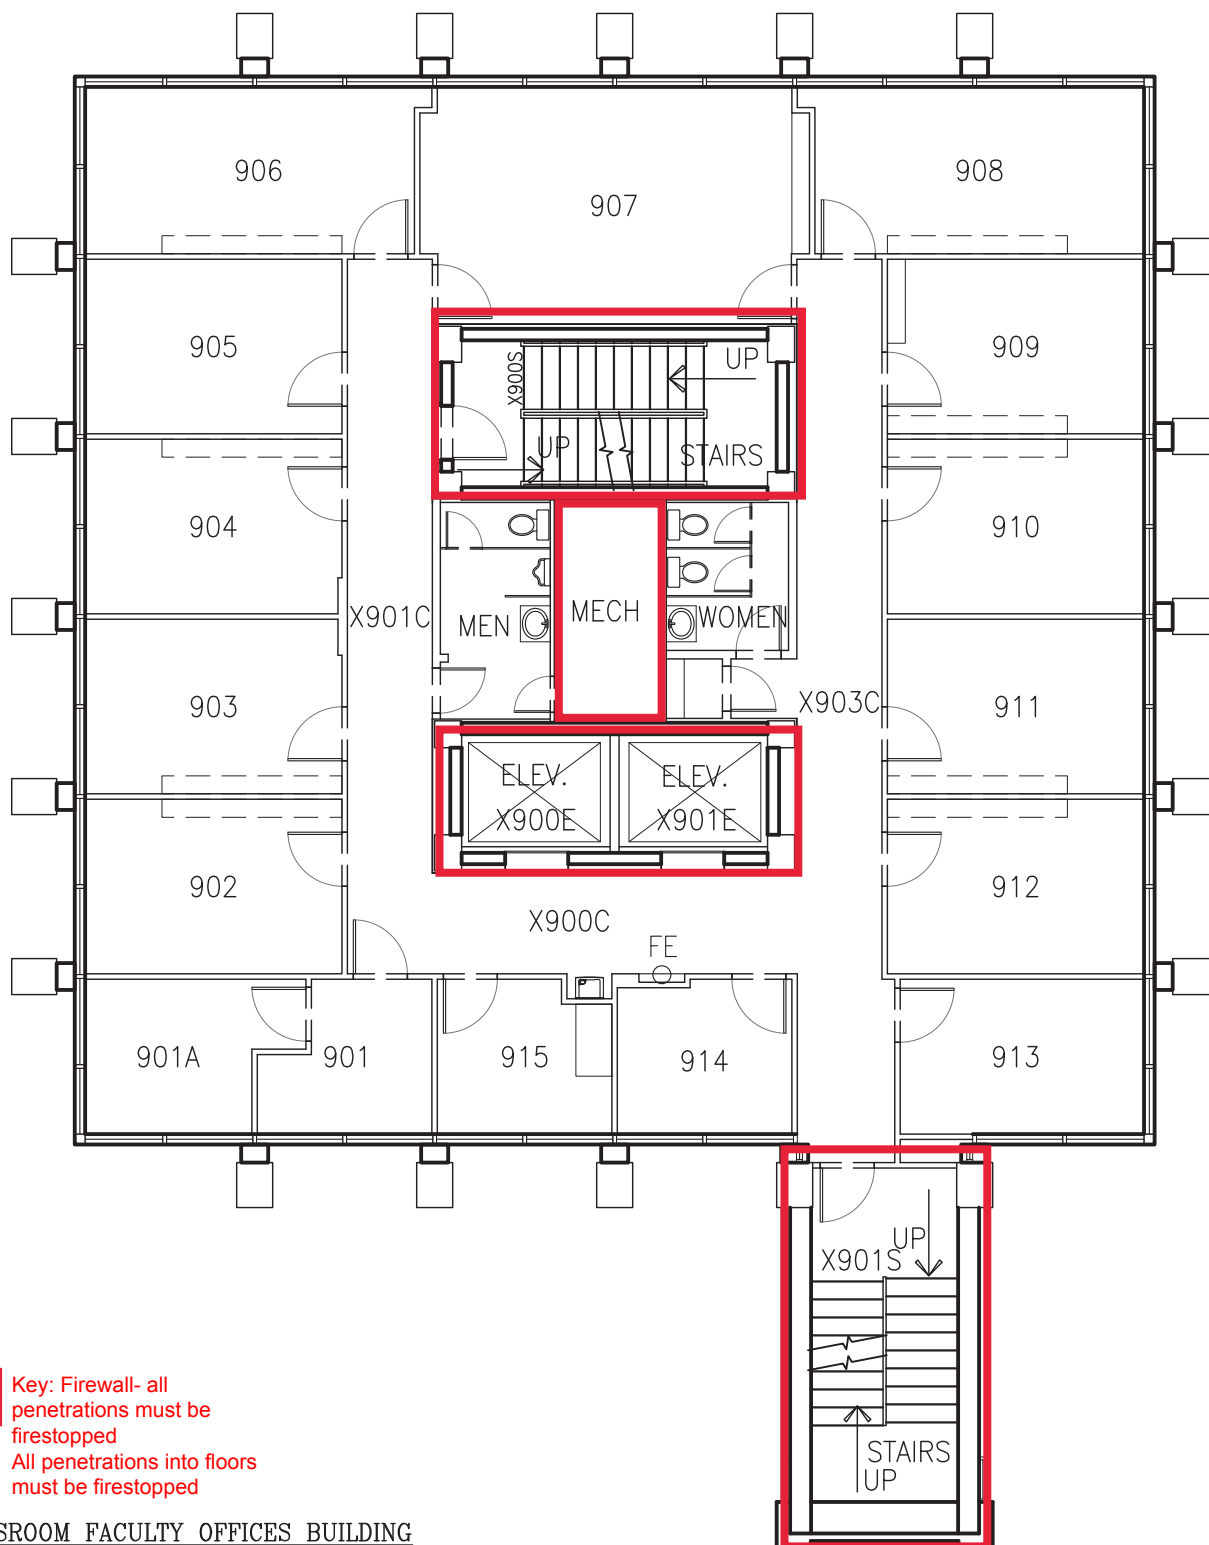


Key: Firewall- all penetrations must be firestopped
All penetrations into floors must be firestopped

1 CLASSROOM FACULTY OFFICES BUILDING
9TH FLOOR PLAN SCALE: 3/32" = 1'-0"


GRAPHIC SCALE




LEGEND	
FIRE PULL	FIRE
FIRE EXTINGUISHER	FE

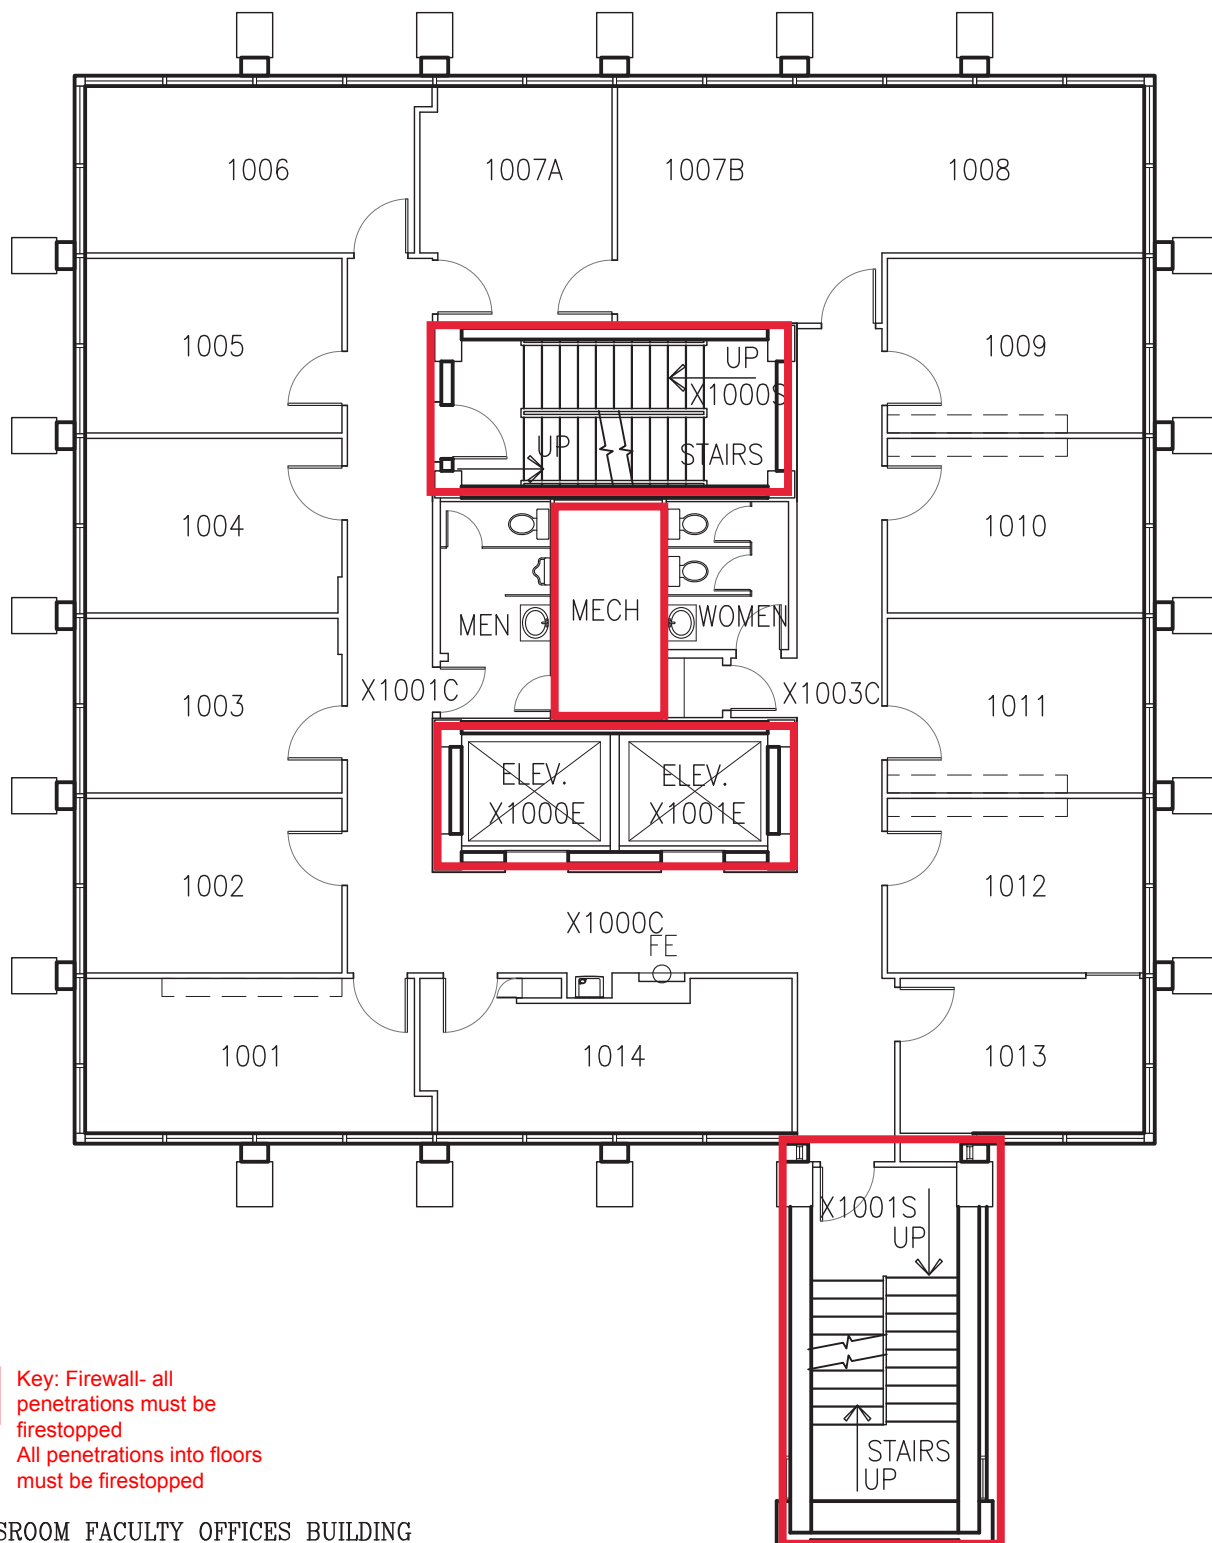

Key: Firewall- all penetrations must be firestopped
All penetrations into floors must be firestopped

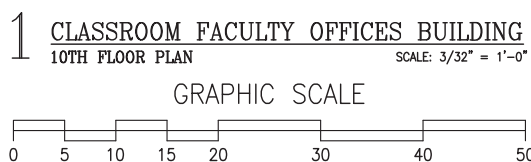


LEGEND	
FIRE PULL	FIRE
FIRE EXTINGUISHER	FE

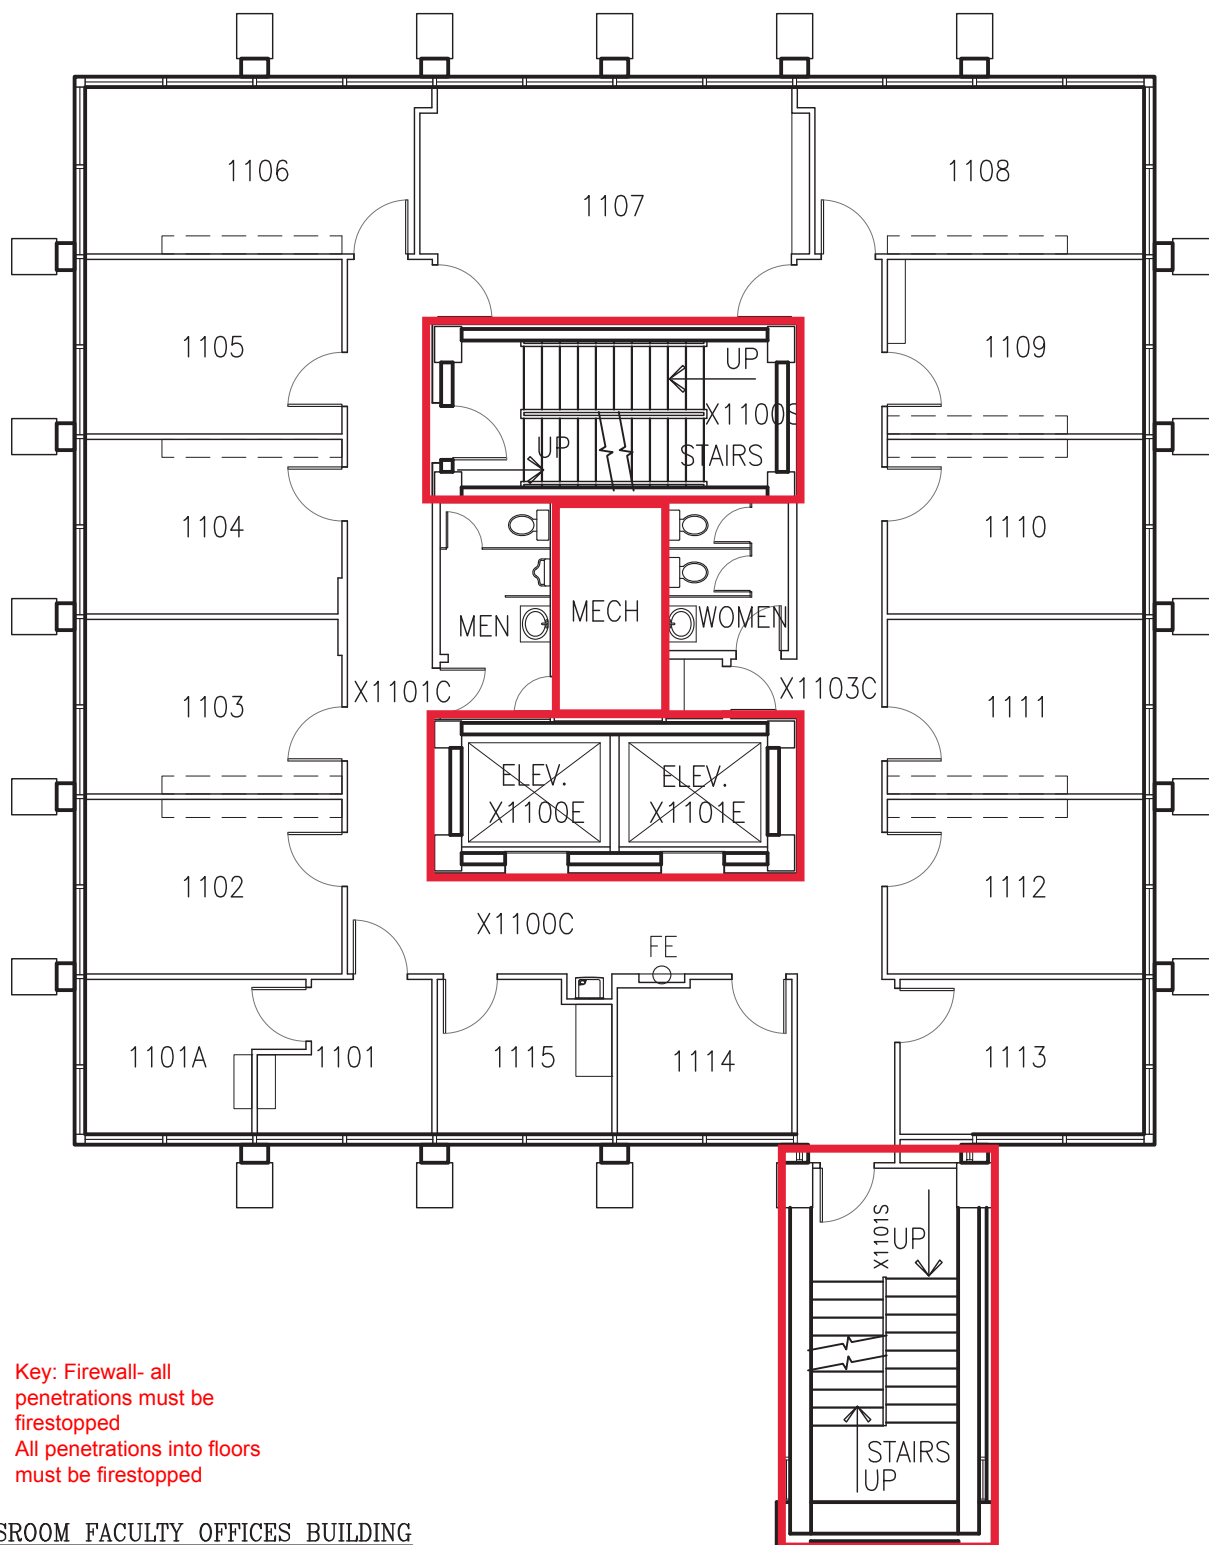


Key: Firewall- all penetrations must be firestopped
 All penetrations into floors must be firestopped

1 CLASSROOM FACULTY OFFICES BUILDING
 11TH FLOOR PLAN SCALE: 3/32" = 1'-0"

 GRAPHIC SCALE



LEGEND	
FIRE PULL	FIRE
FIRE EXTINGUISHER	FEL

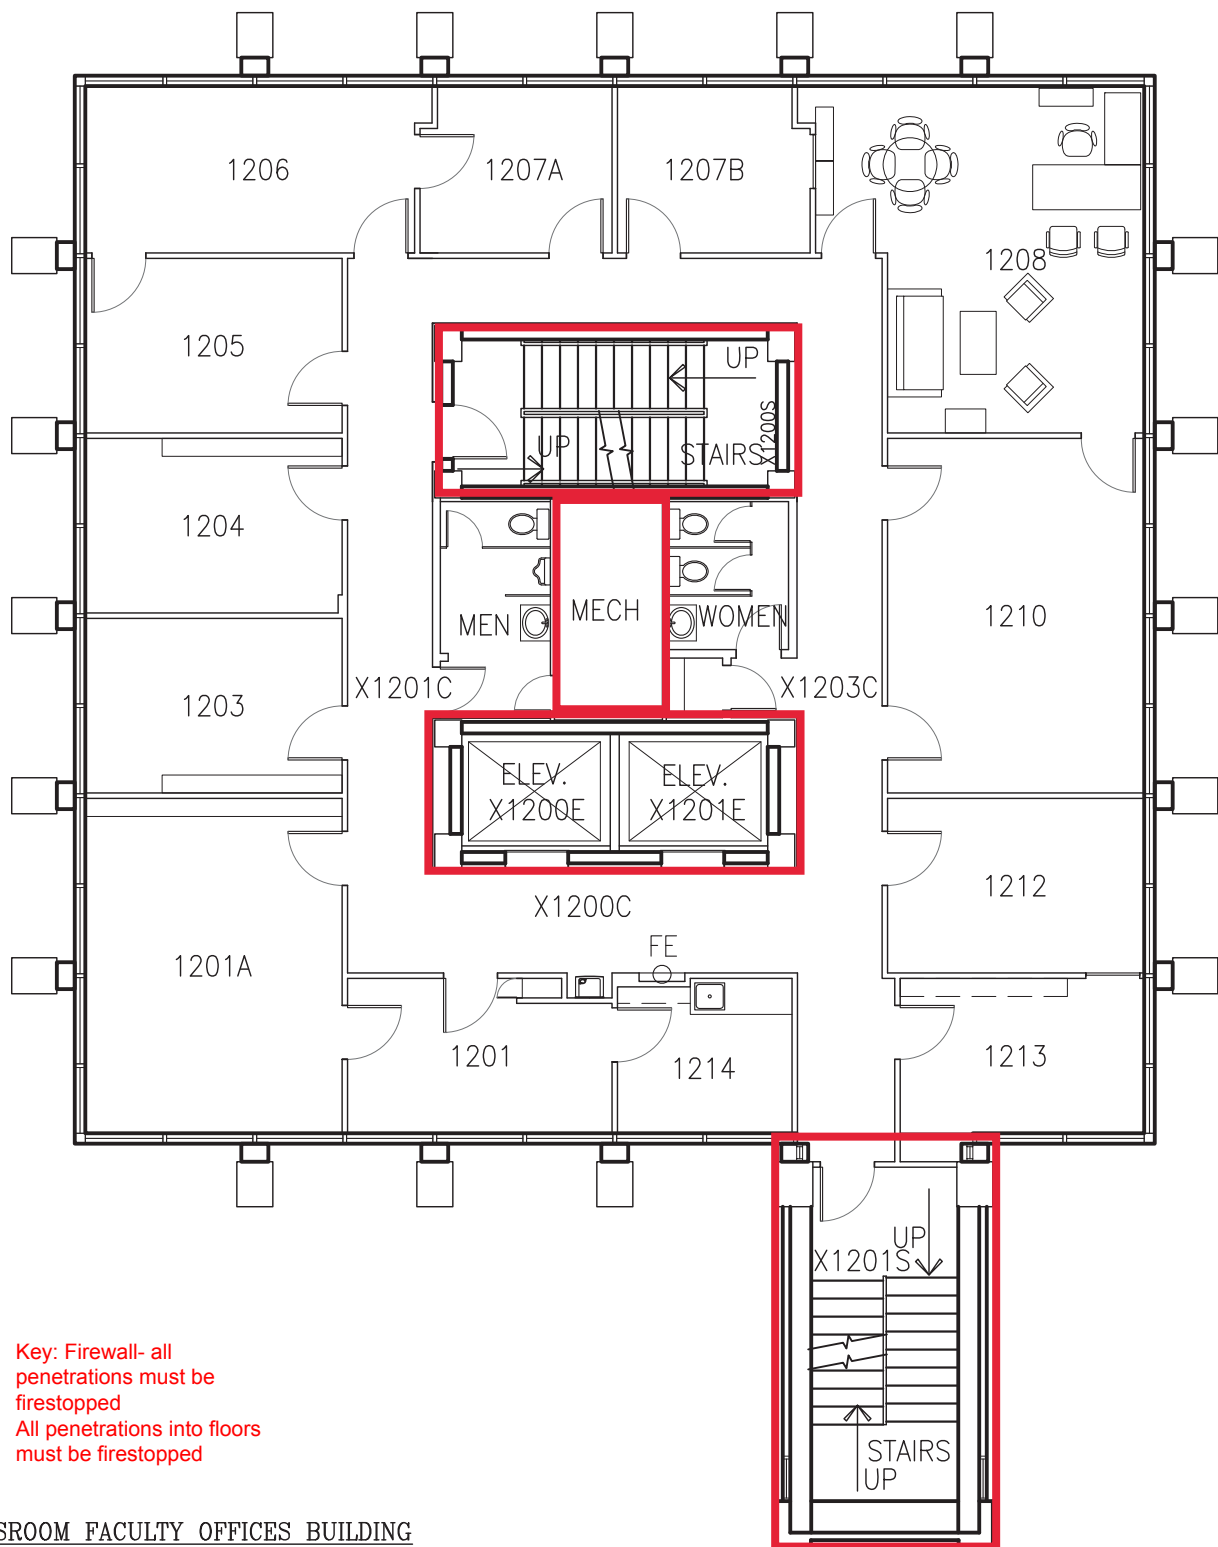


1 CLASSROOM FACULTY OFFICES BUILDING
12TH FLOOR PLAN SCALE: 3/32" = 1'-0"

GRAPHIC SCALE

0 5 10 15 20 30 40 50



LEGEND	
FIRE PULL	FIRE
FIRE EXTINGUISHER	FE

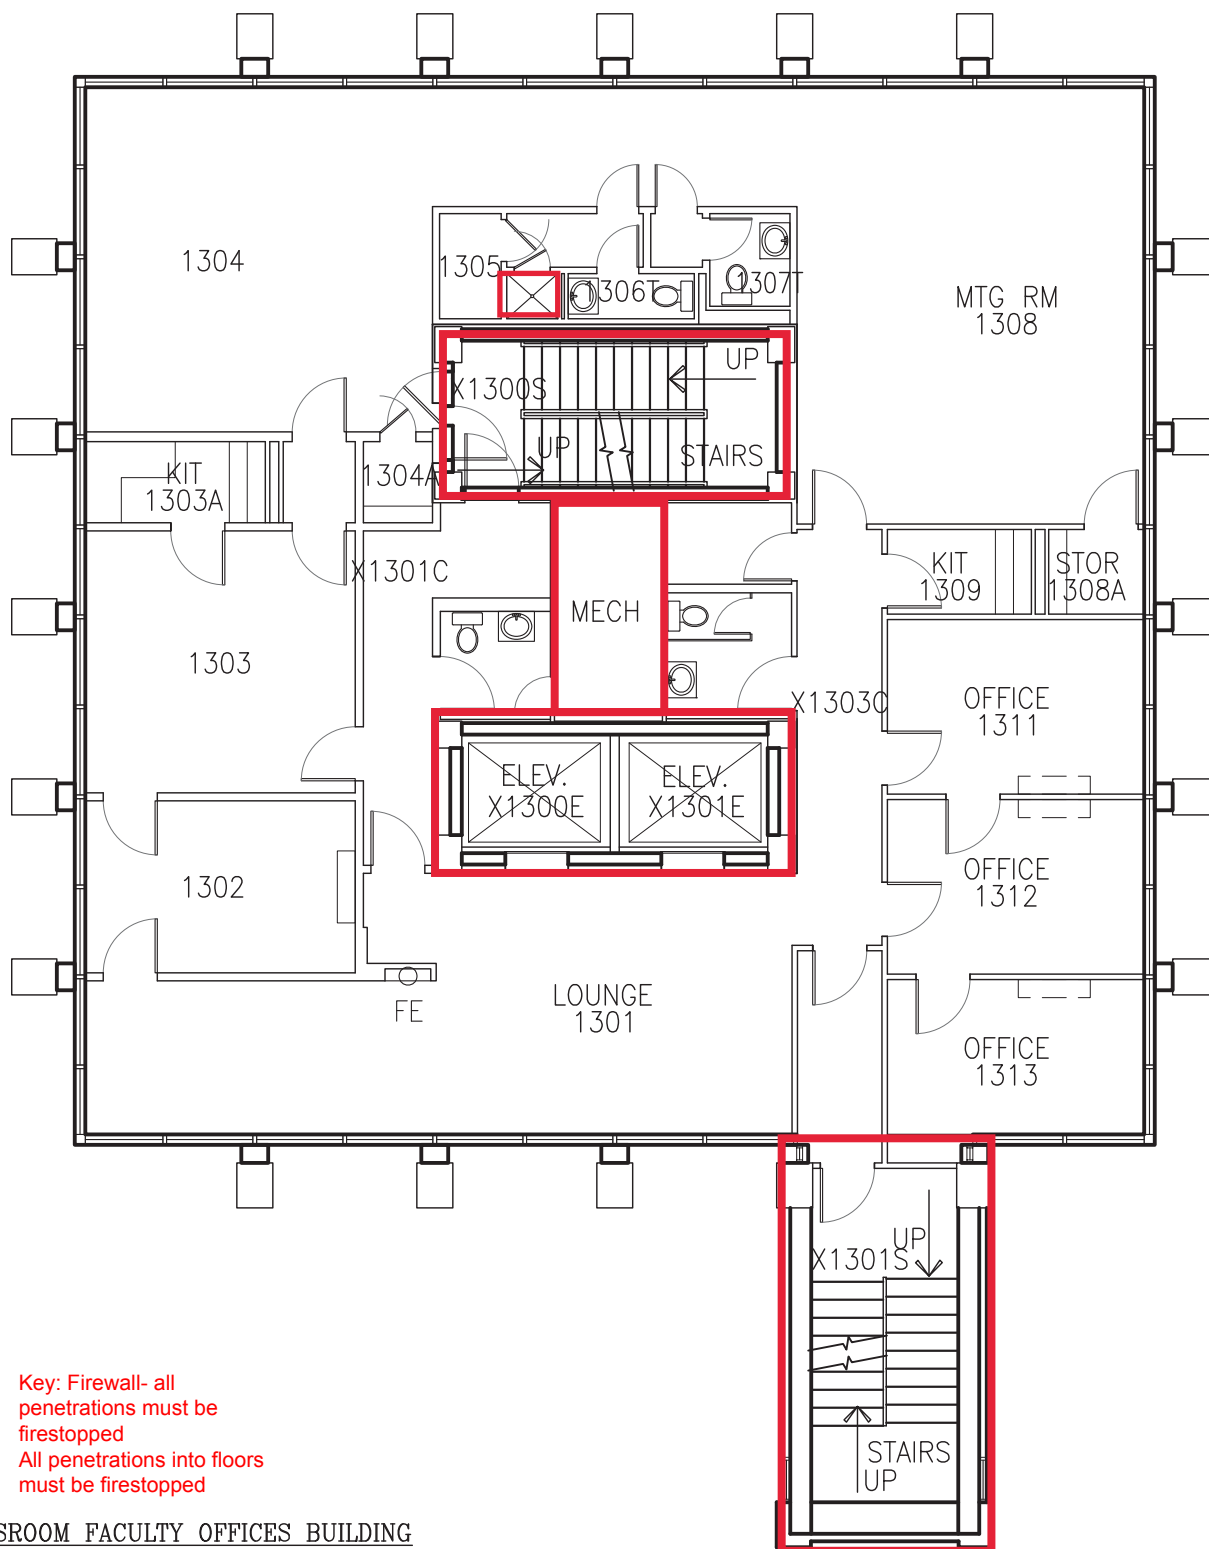


Key: Firewall- all penetrations must be firestopped
All penetrations into floors must be firestopped


1 CLASSROOM FACULTY OFFICES BUILDING
 13TH FLOOR PLAN

SCALE: 3/32" = 1'-0"

 GRAPHIC SCALE



LEGEND	
FIRE PULL	FIRE
FIRE EXTINGUISHER	FE

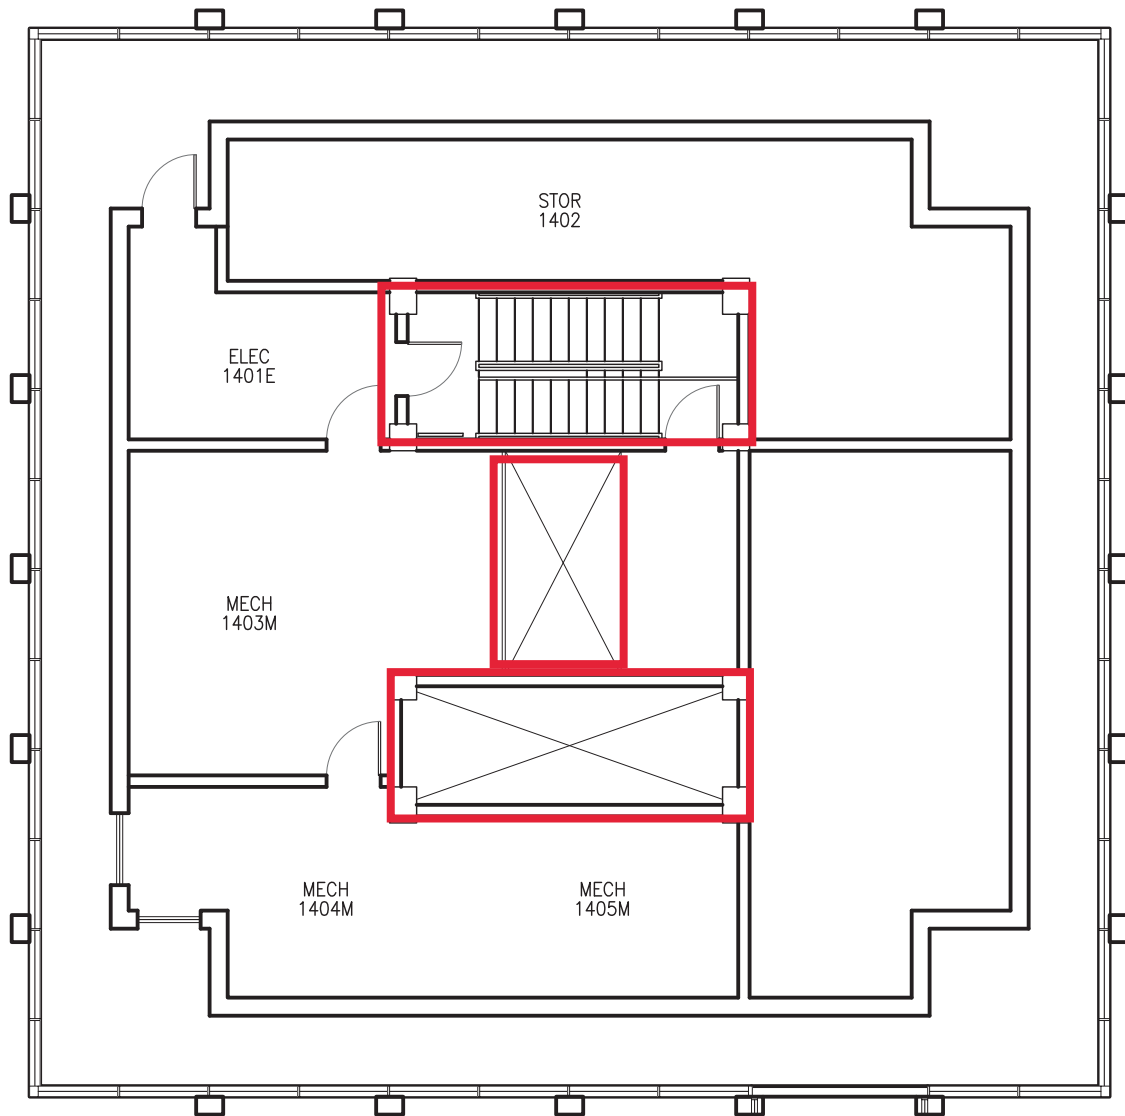


Key: Firewall- all
penetrations must be
firestopped
All penetrations into floors
must be firestopped

1 CLASSROOM FACULTY OFFICES BUILDING
14TH FLOOR PLAN SCALE: 3/32" = 1'-0"

GRAPHIC SCALE



LEGEND	
FIRE PULL	FIRE
FIRE EXTINGUISHER	FE

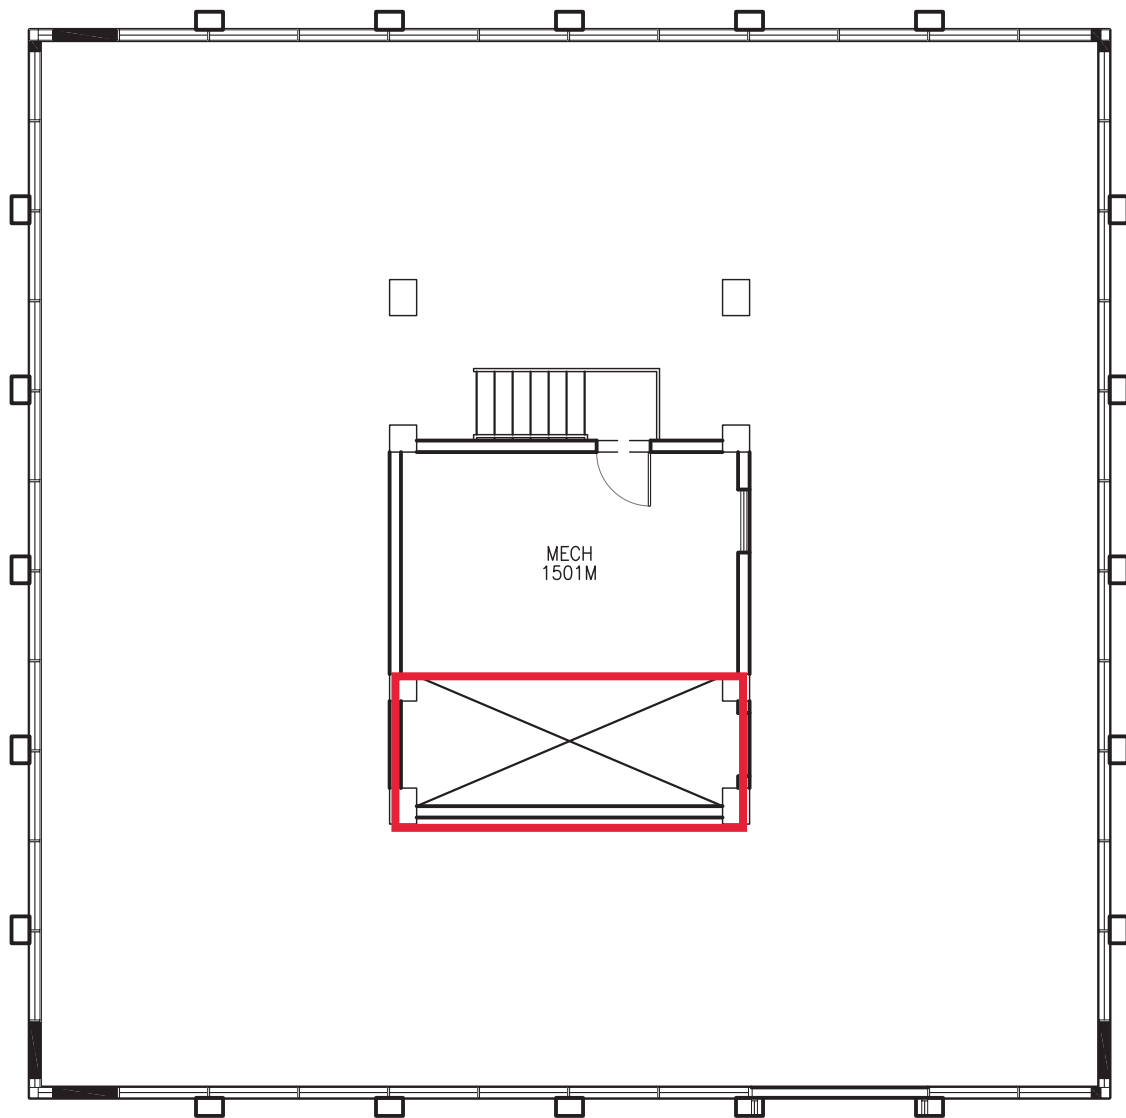


Key: Firewall- all
penetrations must be
firestopped
All penetrations into floors
must be firestopped

1

CLASSROOM FACULTY OFFICES BUILDING
15TH FLOOR PLAN

SCALE: 3/32" = 1'-0"

 GRAPHIC SCALE



LEGEND	
FIRE PULL	FIRE
FIRE EXTINGUISHER	FE