




Key: Firewall- all penetrations must be firestopped
All penetrations into floors must be firestopped

1 DANCE GYM LAB BUILDING
 BASEMENT PLAN SCALE: 3/32" = 1'-0"




LEGEND
 FIRE PULL FIRE EXTINGUISHER FEO

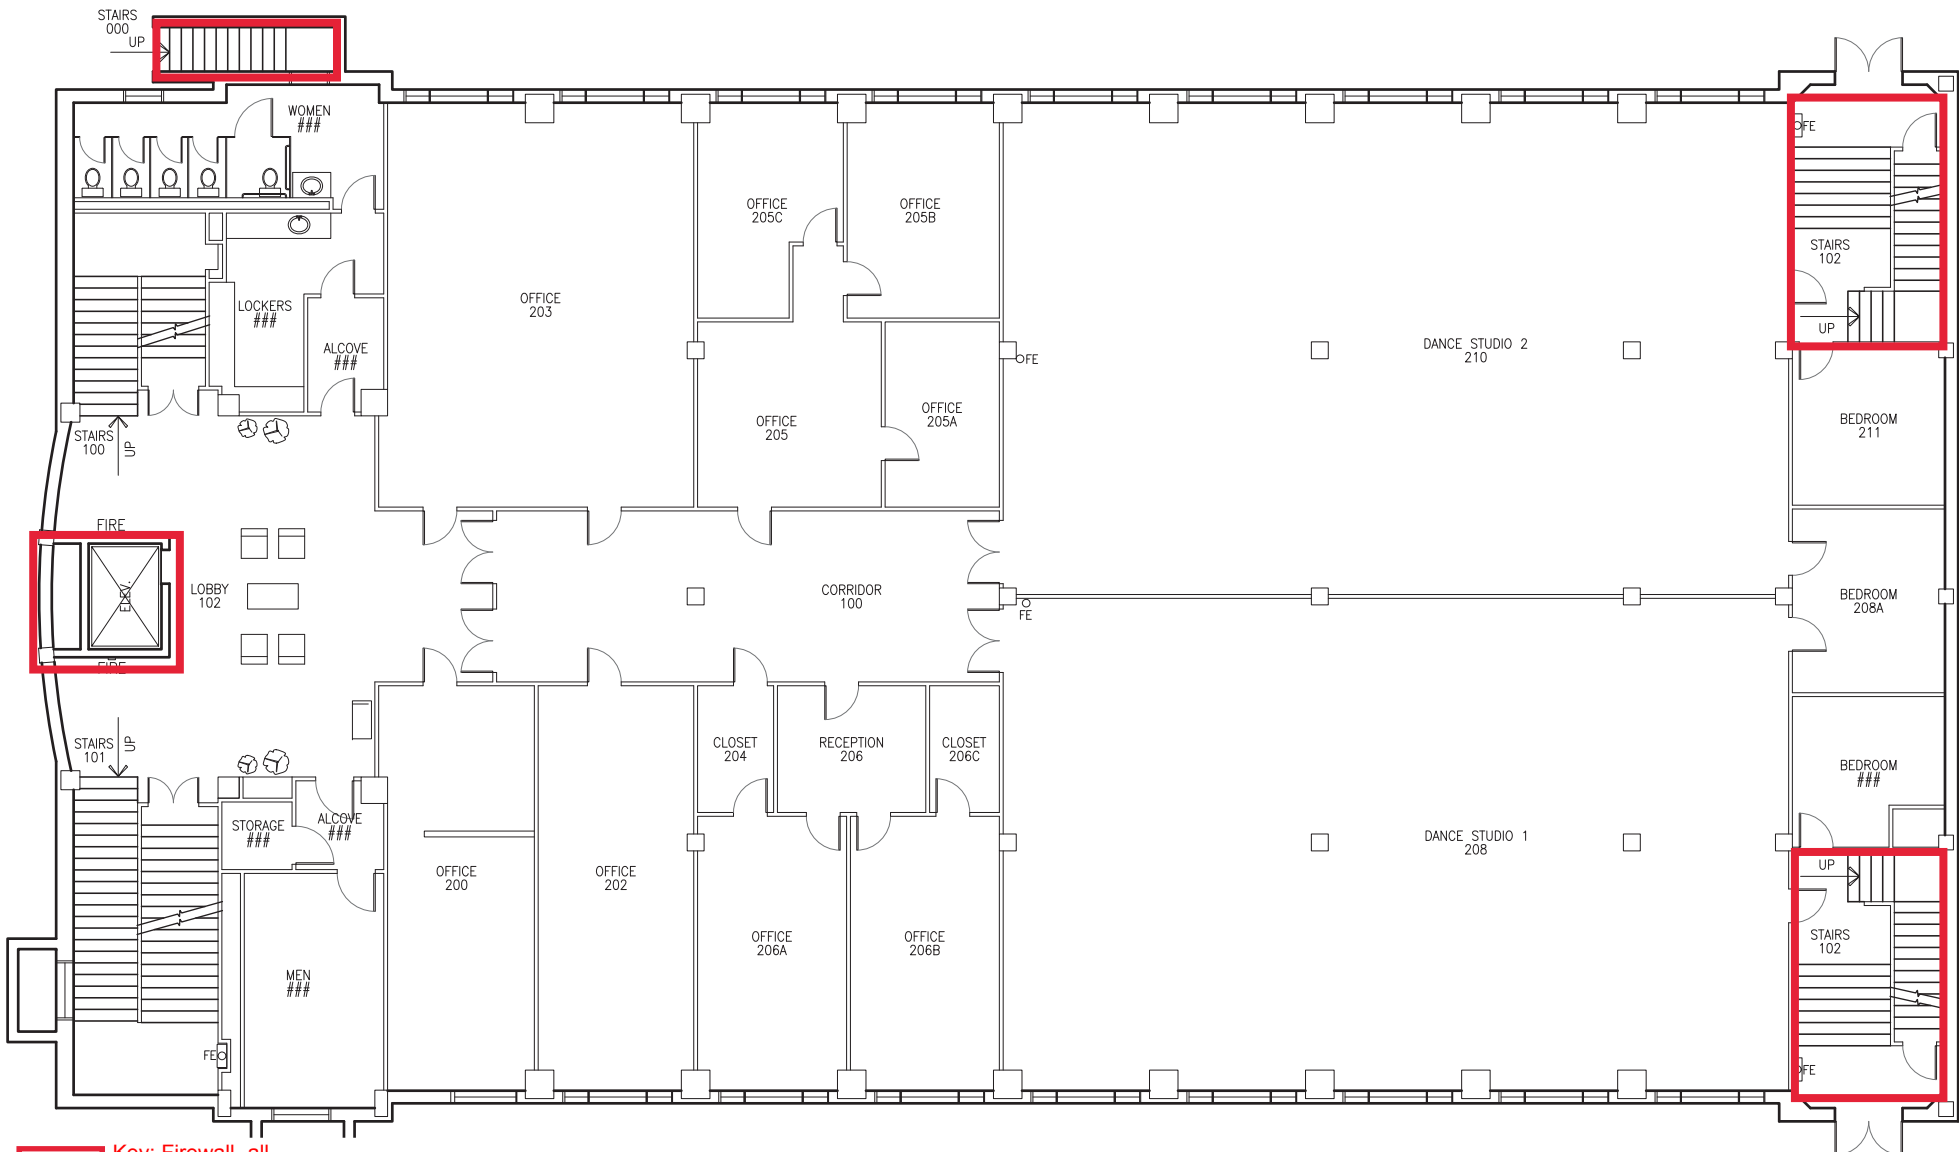

Key: Firewall- all penetrations must be firestopped
All penetrations into floors must be firestopped


1 DANCE GYM LAB BUILDING
 1ST FLOOR PLAN SCALE: 3/32" = 1'-0"



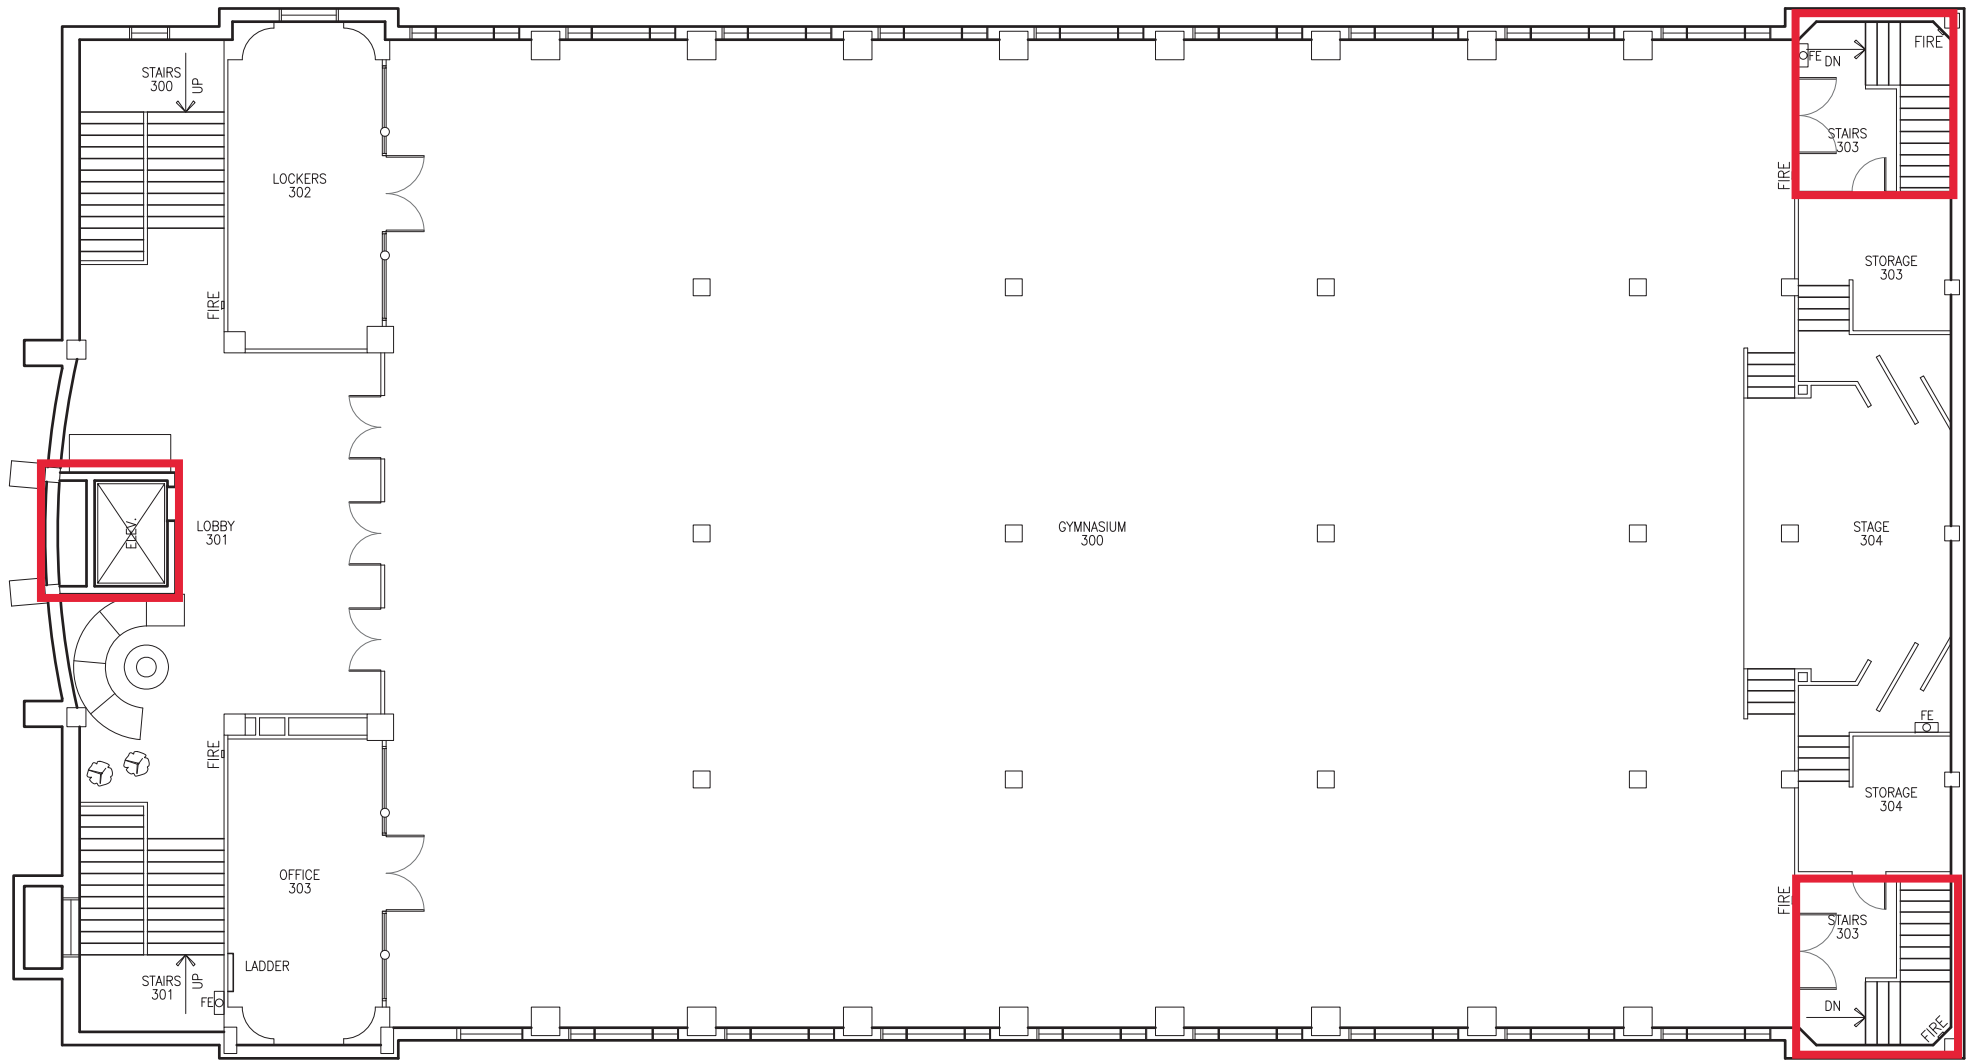


Key: Firewall- all penetrations must be firestopped
All penetrations into floors must be firestopped

 
1 DANCE GYM LAB BUILDING
 2ND FLOOR PLAN SCALE: 3/32" = 1'-0"



LEGEND
 FIRE PULL FIRE PULL
 FIRE EXTINGUISHER FEO

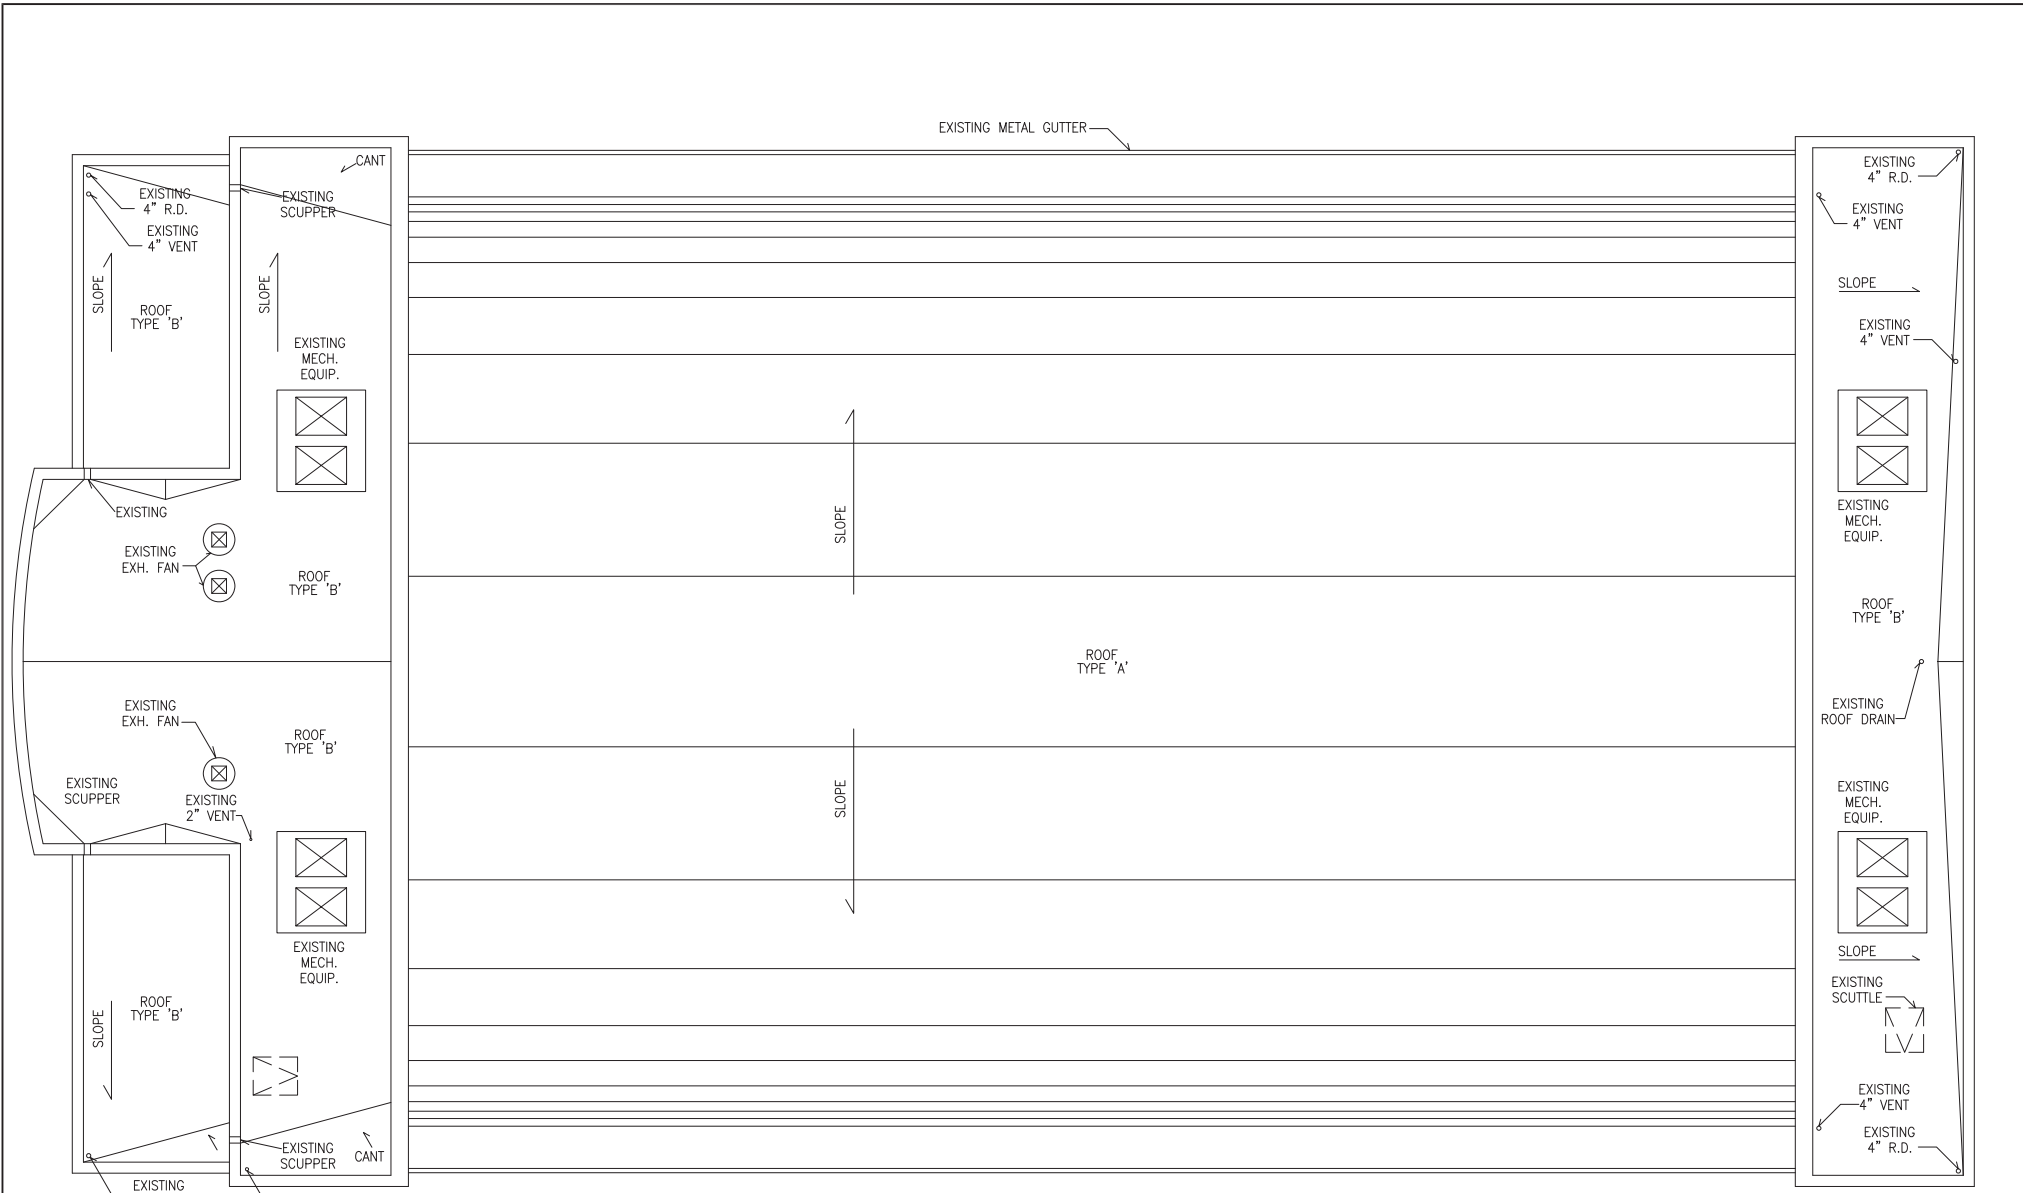

 Key: Firewall- all penetrations must be firestopped
All penetrations into floors must be firestopped



LEGEND
 FIRE PULL FIRE PULL
 FIRE EXTINGUISHER FEO