 



MAP KEY

Shelter Locations

- Primary
- Secondary




LEGEND	
FIRE PULL	FIRE
FIRE EXTINGUISHER	FE

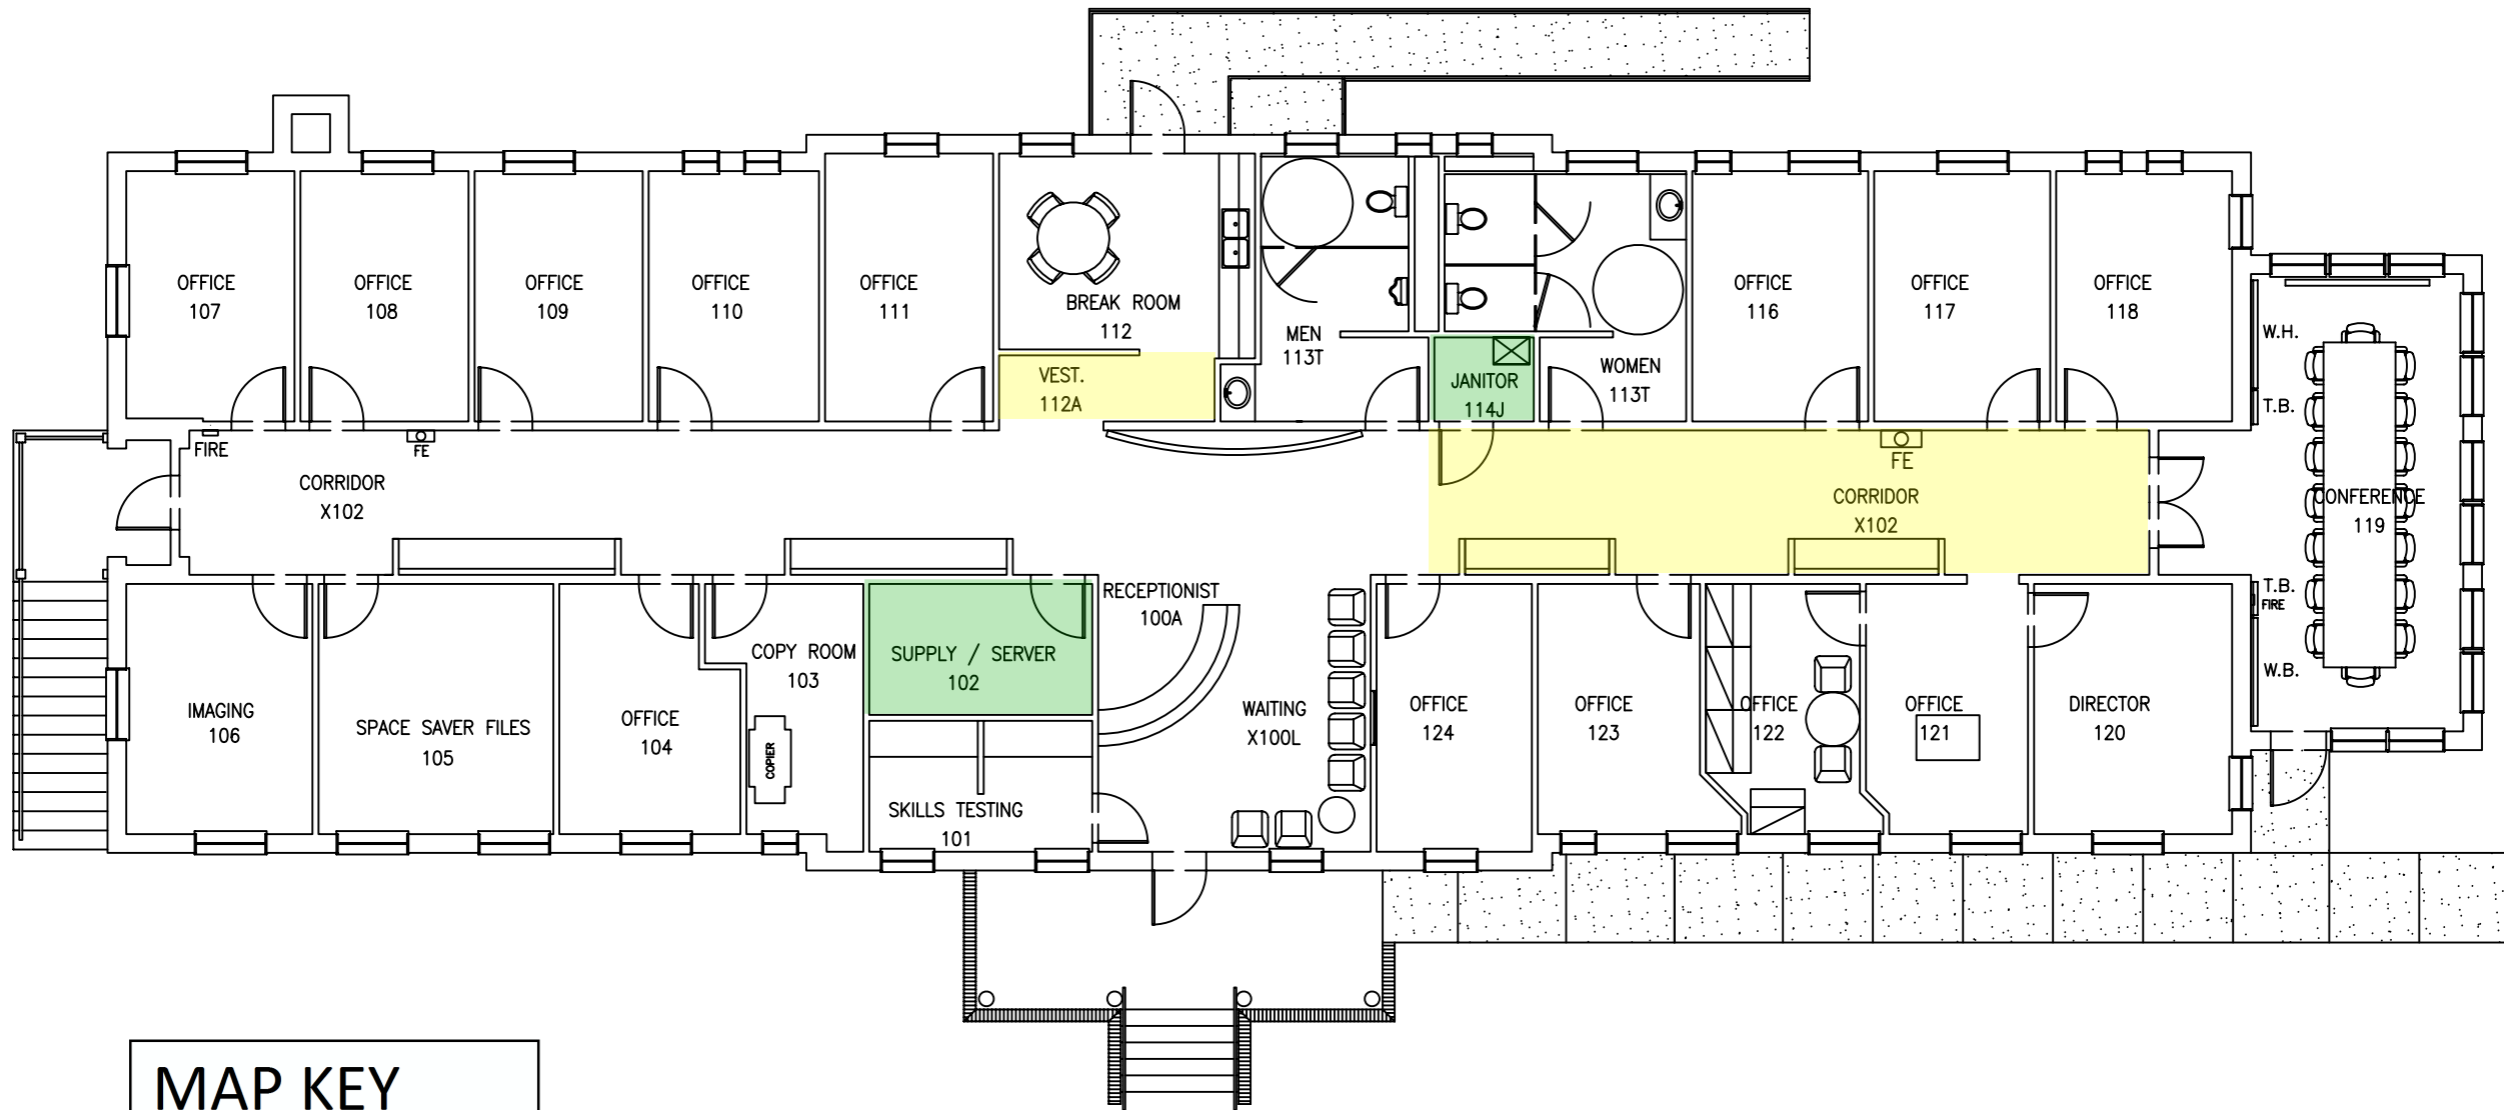

MAP KEY
 Shelter Locations

- Primary
- Secondary

1 INSTITUTIONAL DEVELOPMENT BUILDING
 1ST FLOOR PLAN SCALE: 3/32" = 1'-0"

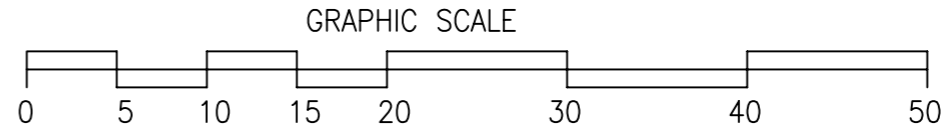

LEGEND

FIRE PULL	FIRE-
FIRE EXTINGUISHER	FE □