




TEXAS WOMAN'S UNIVERSITY
 FACILITIES MANAGEMENT & CONSTRUCTION DEPT.
 PHYSICAL PLANT SERVICES CENTER DENTON, TEXAS

UPDATED
 3/5/2014
 REVISION #


MARY EVELYN BLAGG HUEY
 LIBRARY
 GARDEN LEVEL - AS-BUILT

PROJECT NUMBER


SHEET
 A1
 OF 4

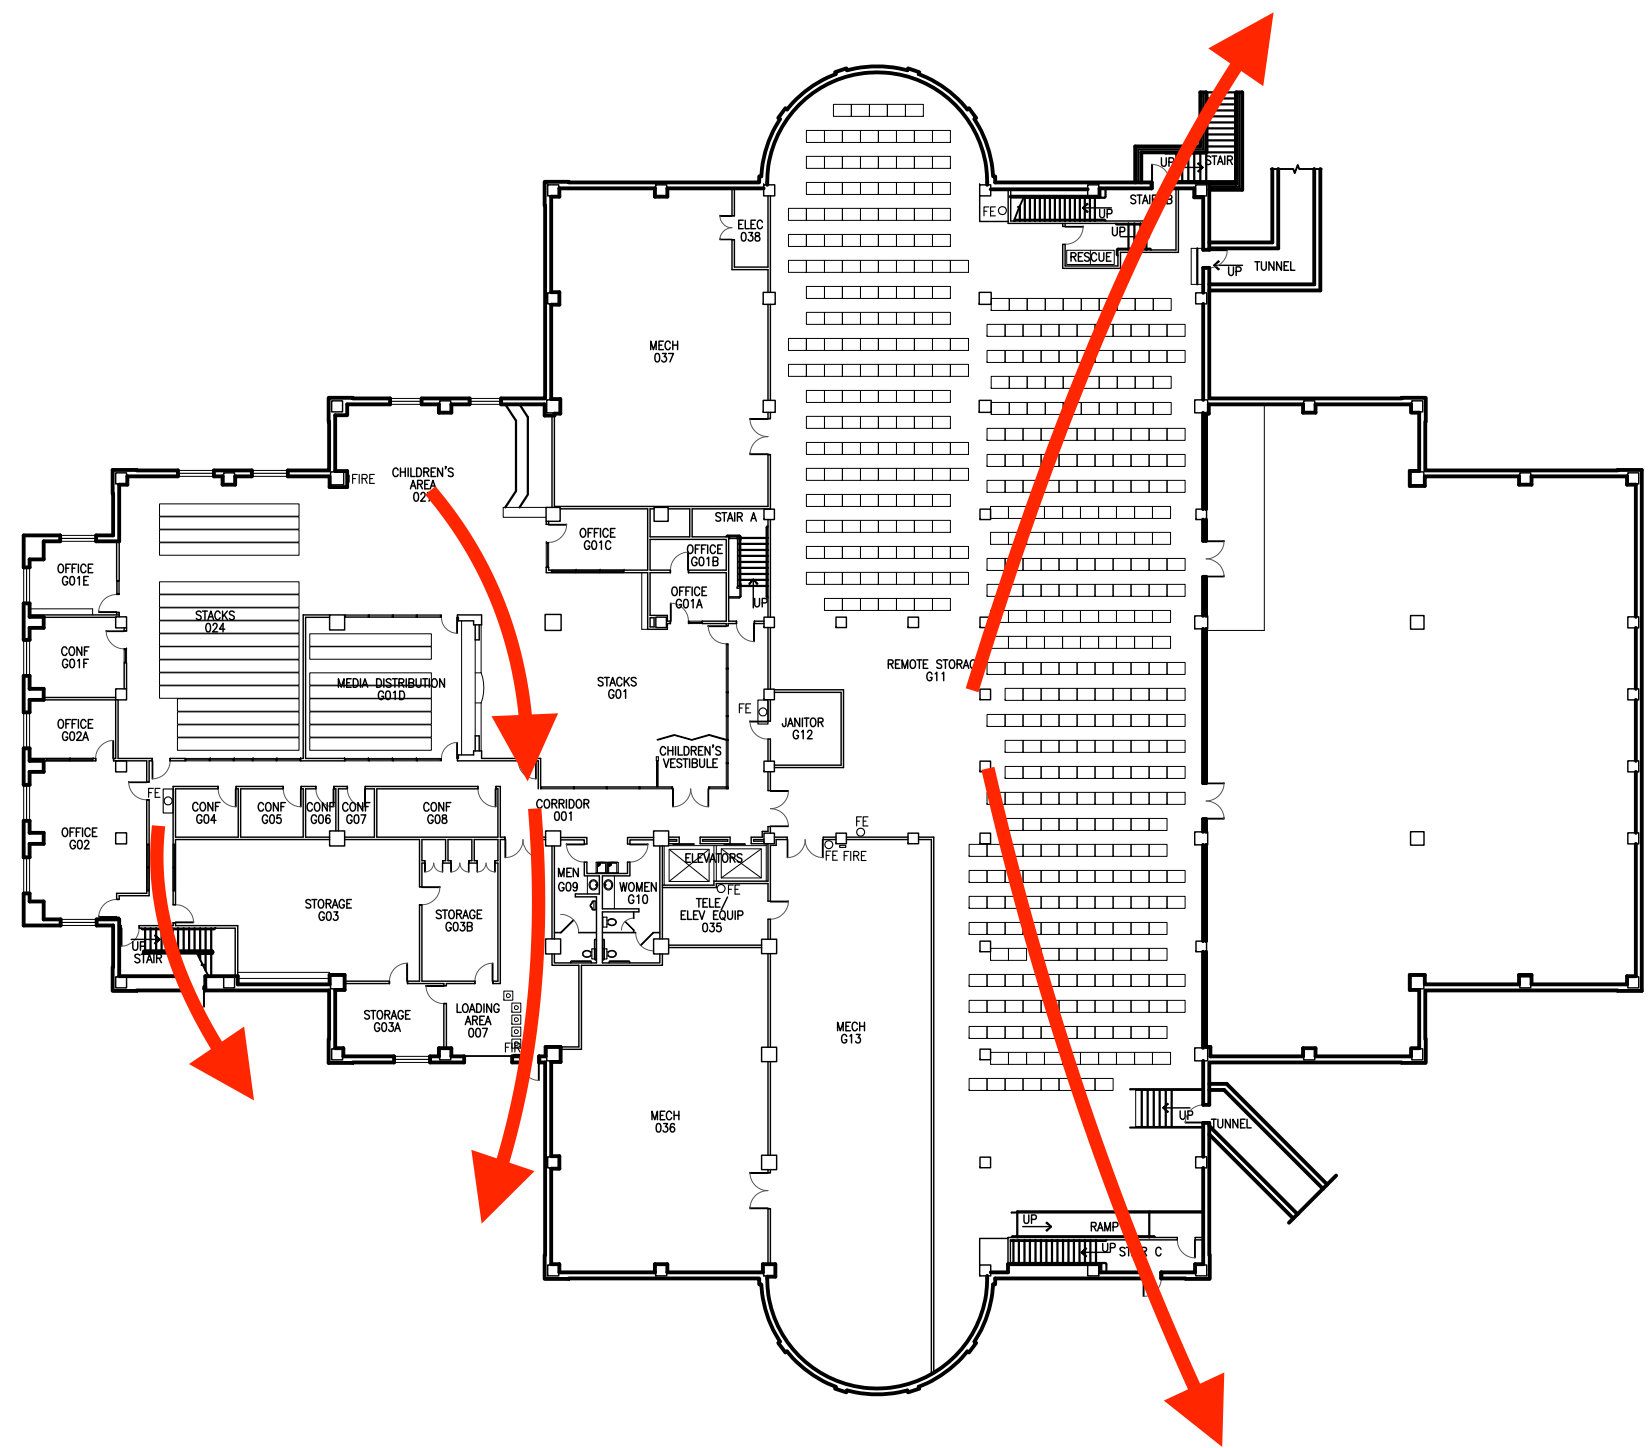

 1 MARY EVELYN BLAGG HUEY LIBRARY
 GROUND FLOOR PLAN SCALE: 1/32" = 1'-0"



LEGEND	
FIRE PULL	FIRE=
FIRE EXTINGUISHER	FE ○
FIRE EXT IN CABINET	FE □

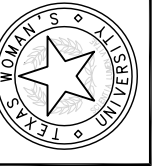

TEXAS WOMAN'S UNIVERSITY
 FACILITIES MANAGEMENT & CONSTRUCTION DEPT.
 PHYSICAL PLANT SERVICES CENTER DENTON, TEXAS


UPDATED
 3/5/2014
 REVISION #

MARY EVELYN BLAGG HUEY
 LIBRARY
 1ST FLOOR - AS-BUILT


PROJECT NUMBER

SHEET
 A2

OF 4

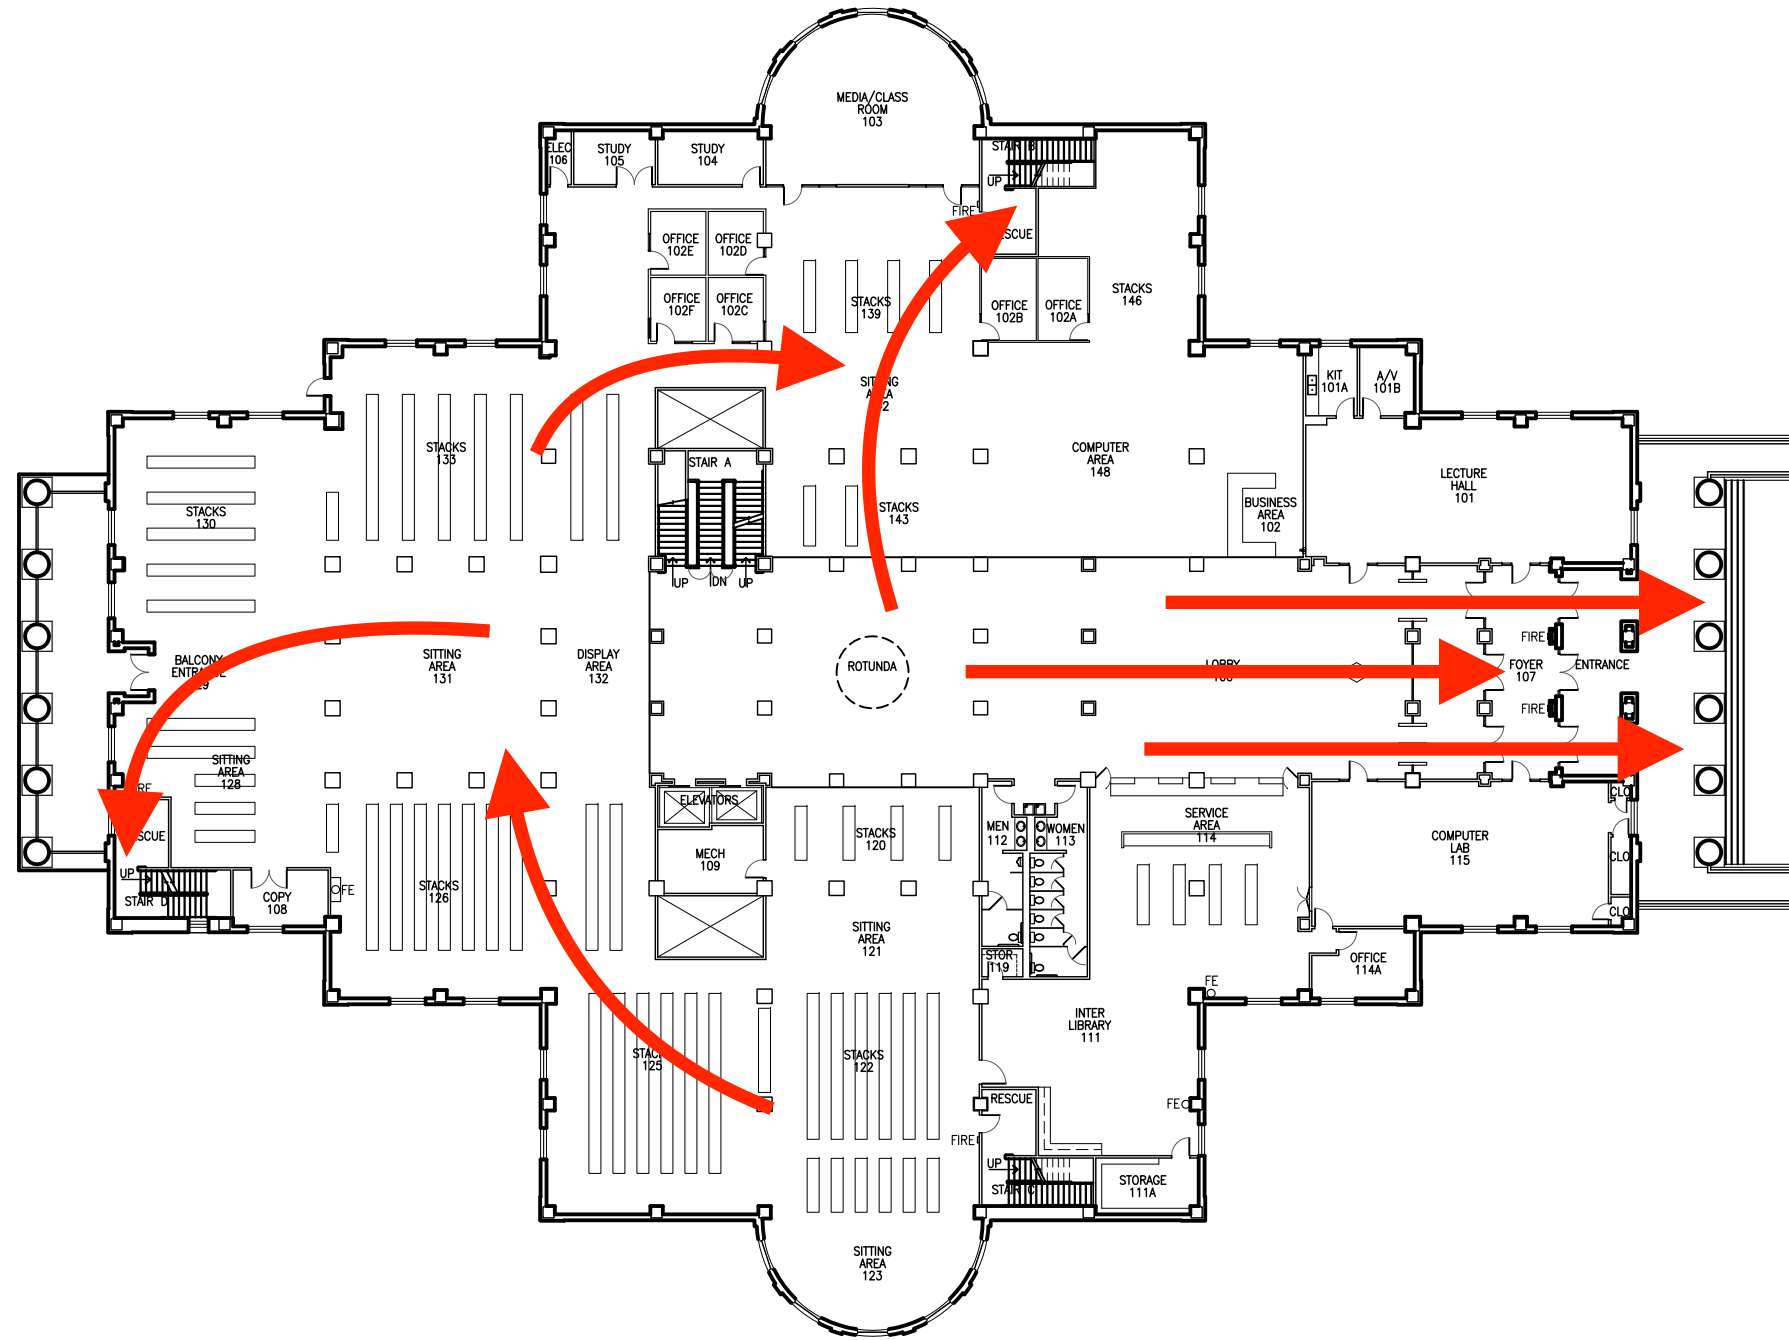


 1 MARY EVELYN BLAGG HUEY LIBRARY
 1ST FLOOR PLAN SCALE: 1/32" = 1'-0"



LEGEND	
FIRE PULL	FIRE=
FIRE EXTINGUISHER	FE○
FIRE EXT IN CABINET	FE□

REVISION			
01	03-05-14	N/A	UNKNOWN
02	04-12-19	BWW	NUMEROUS RENOVATIONS AS SHOWN BY REVISION CLOUDS

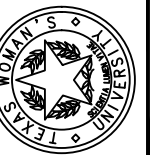

TEXAS WOMAN'S UNIVERSITY
 FACILITIES MANAGEMENT & CONSTRUCTION DEPT.
 PHYSICAL PLANT SERVICES CENTER DENTON, TEXAS


UPDATED
 04-12-19
 REVISION #

MARY EVELYN BLAGG HUEY
 LIBRARY
 2ND FLOOR - AS-BUILT


PROJECT NUMBER

SHEET
 A3

OF 4

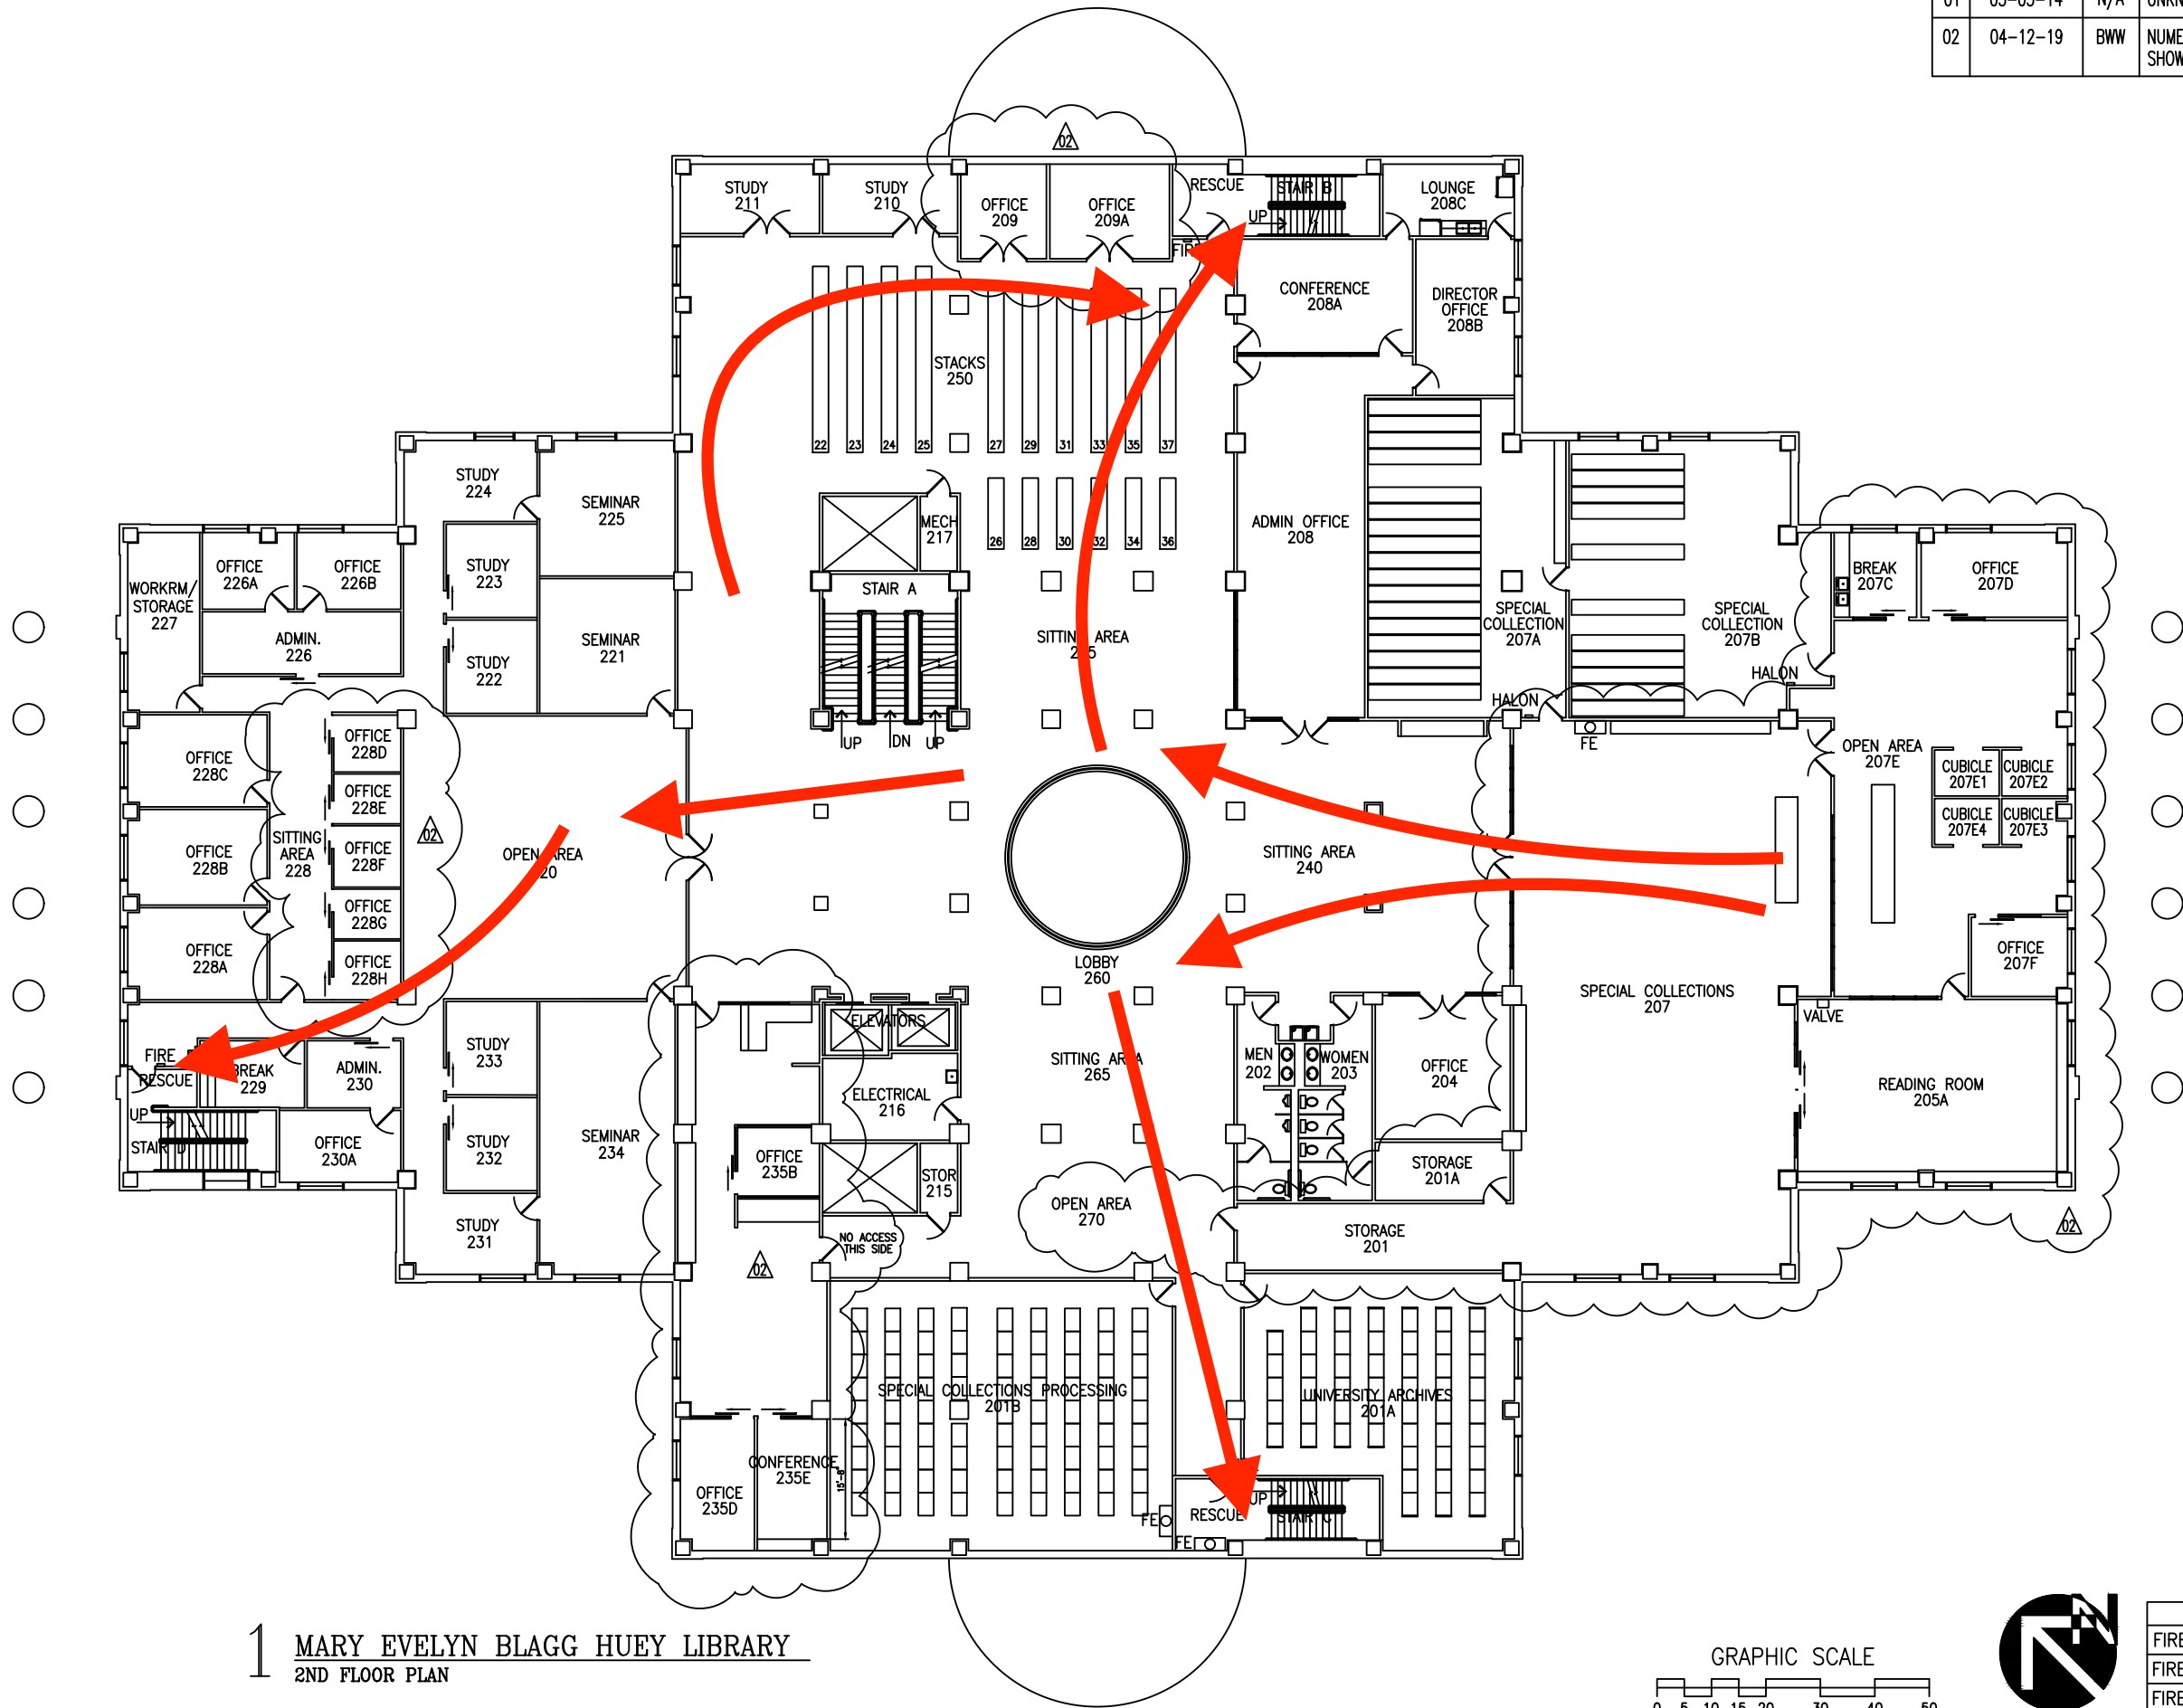

 1 MARY EVELYN BLAGG HUEY LIBRARY
 2ND FLOOR PLAN



LEGEND	
	FIRE PULL
	FIRE EXTINGUISHER
	FIRE EXT IN CABINET

REVISION			
01	03-06-14	N/A	UNKNOWN
02	04-12-19	BWW	NUMEROUS RENOVATIONS INDICATED BY ONE REVISION CLOUD



TEXAS WOMAN'S UNIVERSITY
 FACILITIES MANAGEMENT & CONSTRUCTION DEPT.
 PHYSICAL PLANT SERVICES CENTER DENTON, TEXAS


UPDATED 04-12-19
 REVISION # 1

MARY EVELYN BLAGG HUEY LIBRARY
 3RD FLOOR - AS-BUILT


PROJECT NUMBER

SHEET
 A4

OF 4

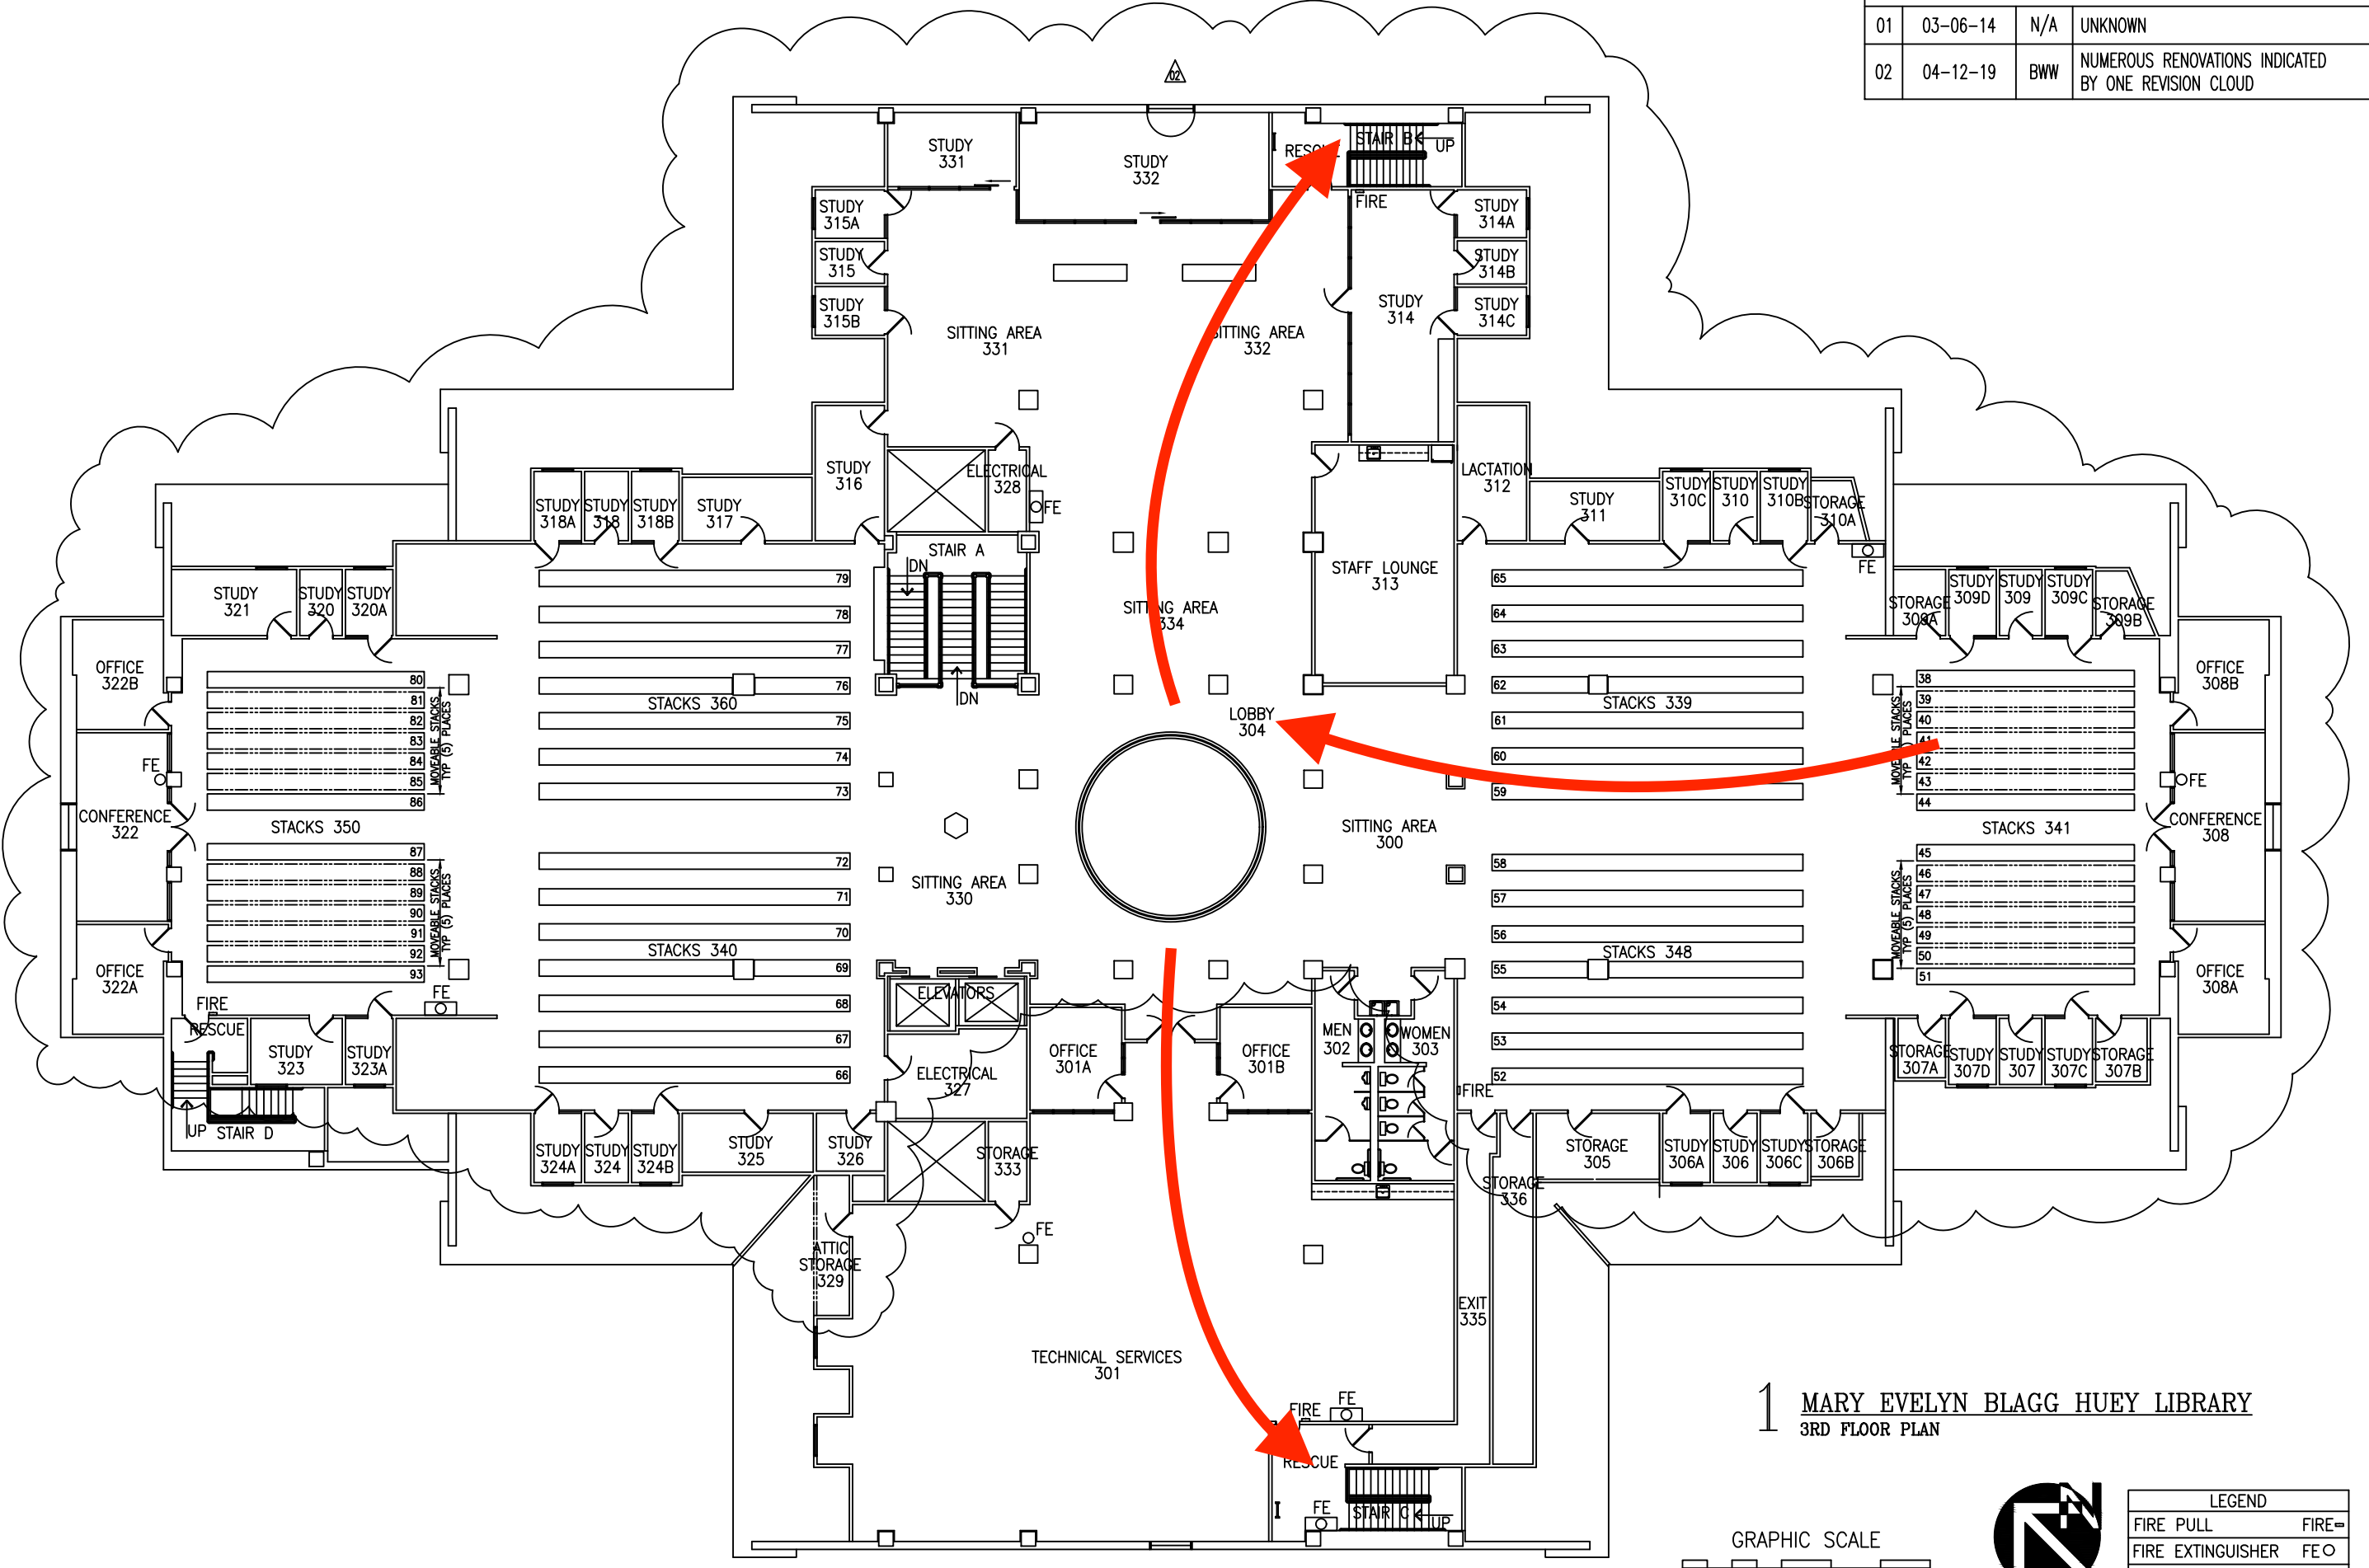

 1 MARY EVELYN BLAGG HUEY LIBRARY
 3RD FLOOR PLAN



LEGEND	
FIRE PULL	FIRE
FIRE EXTINGUISHER	FE
FIRE EXT IN CABINET	FE