



# MAP KEY

## Shelter Locations

- Primary
- Secondary

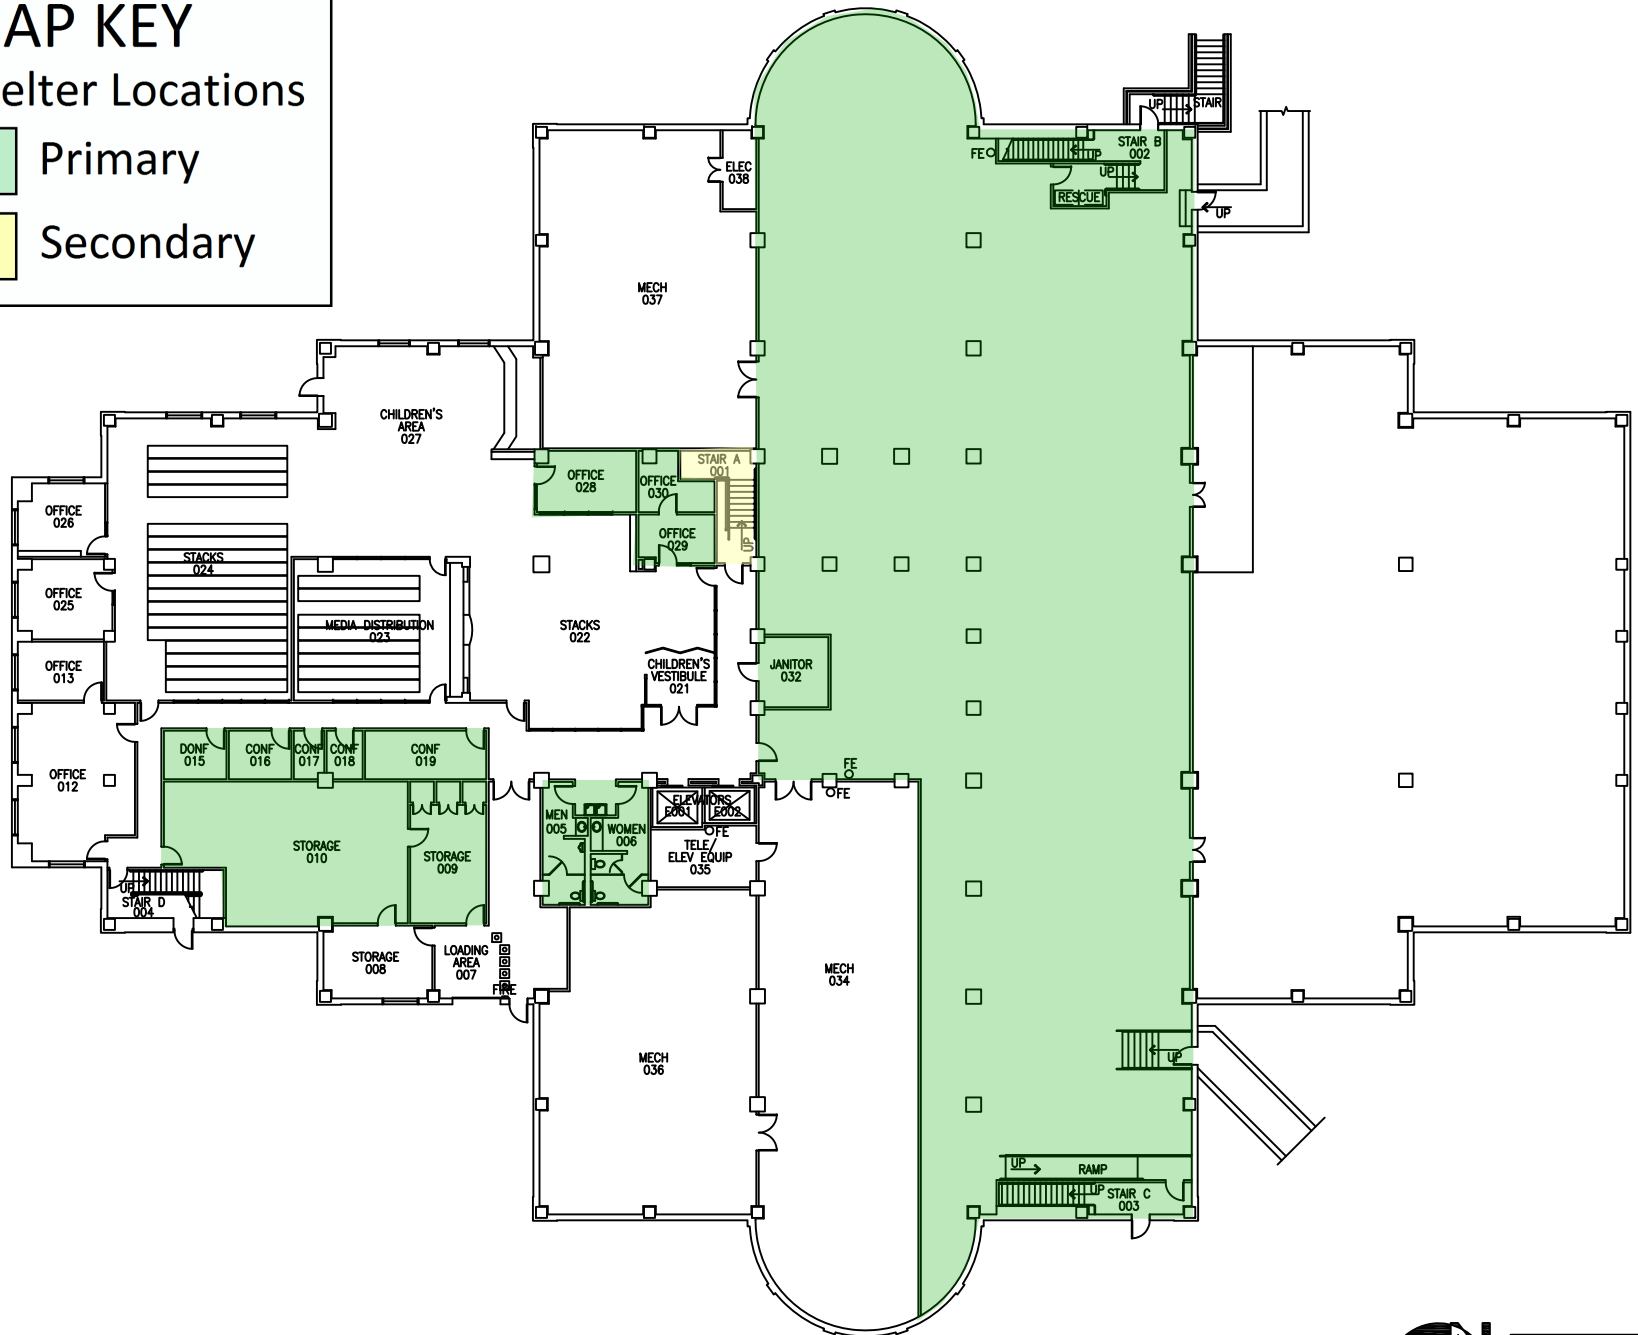

 1 MARY EVELYN BLAGG HUEY LIBRARY  
GARDEN LEVEL PLAN SCALE: 1/32" = 1'-0"




LEGEND	
FIRE PULL	FIRE-
FIRE EXTINGUISHER	FE
FIRE EXT IN CABINET	FE
EYEWASH STATION	EW

# MAP KEY


## Shelter Locations

- Primary
- Secondary

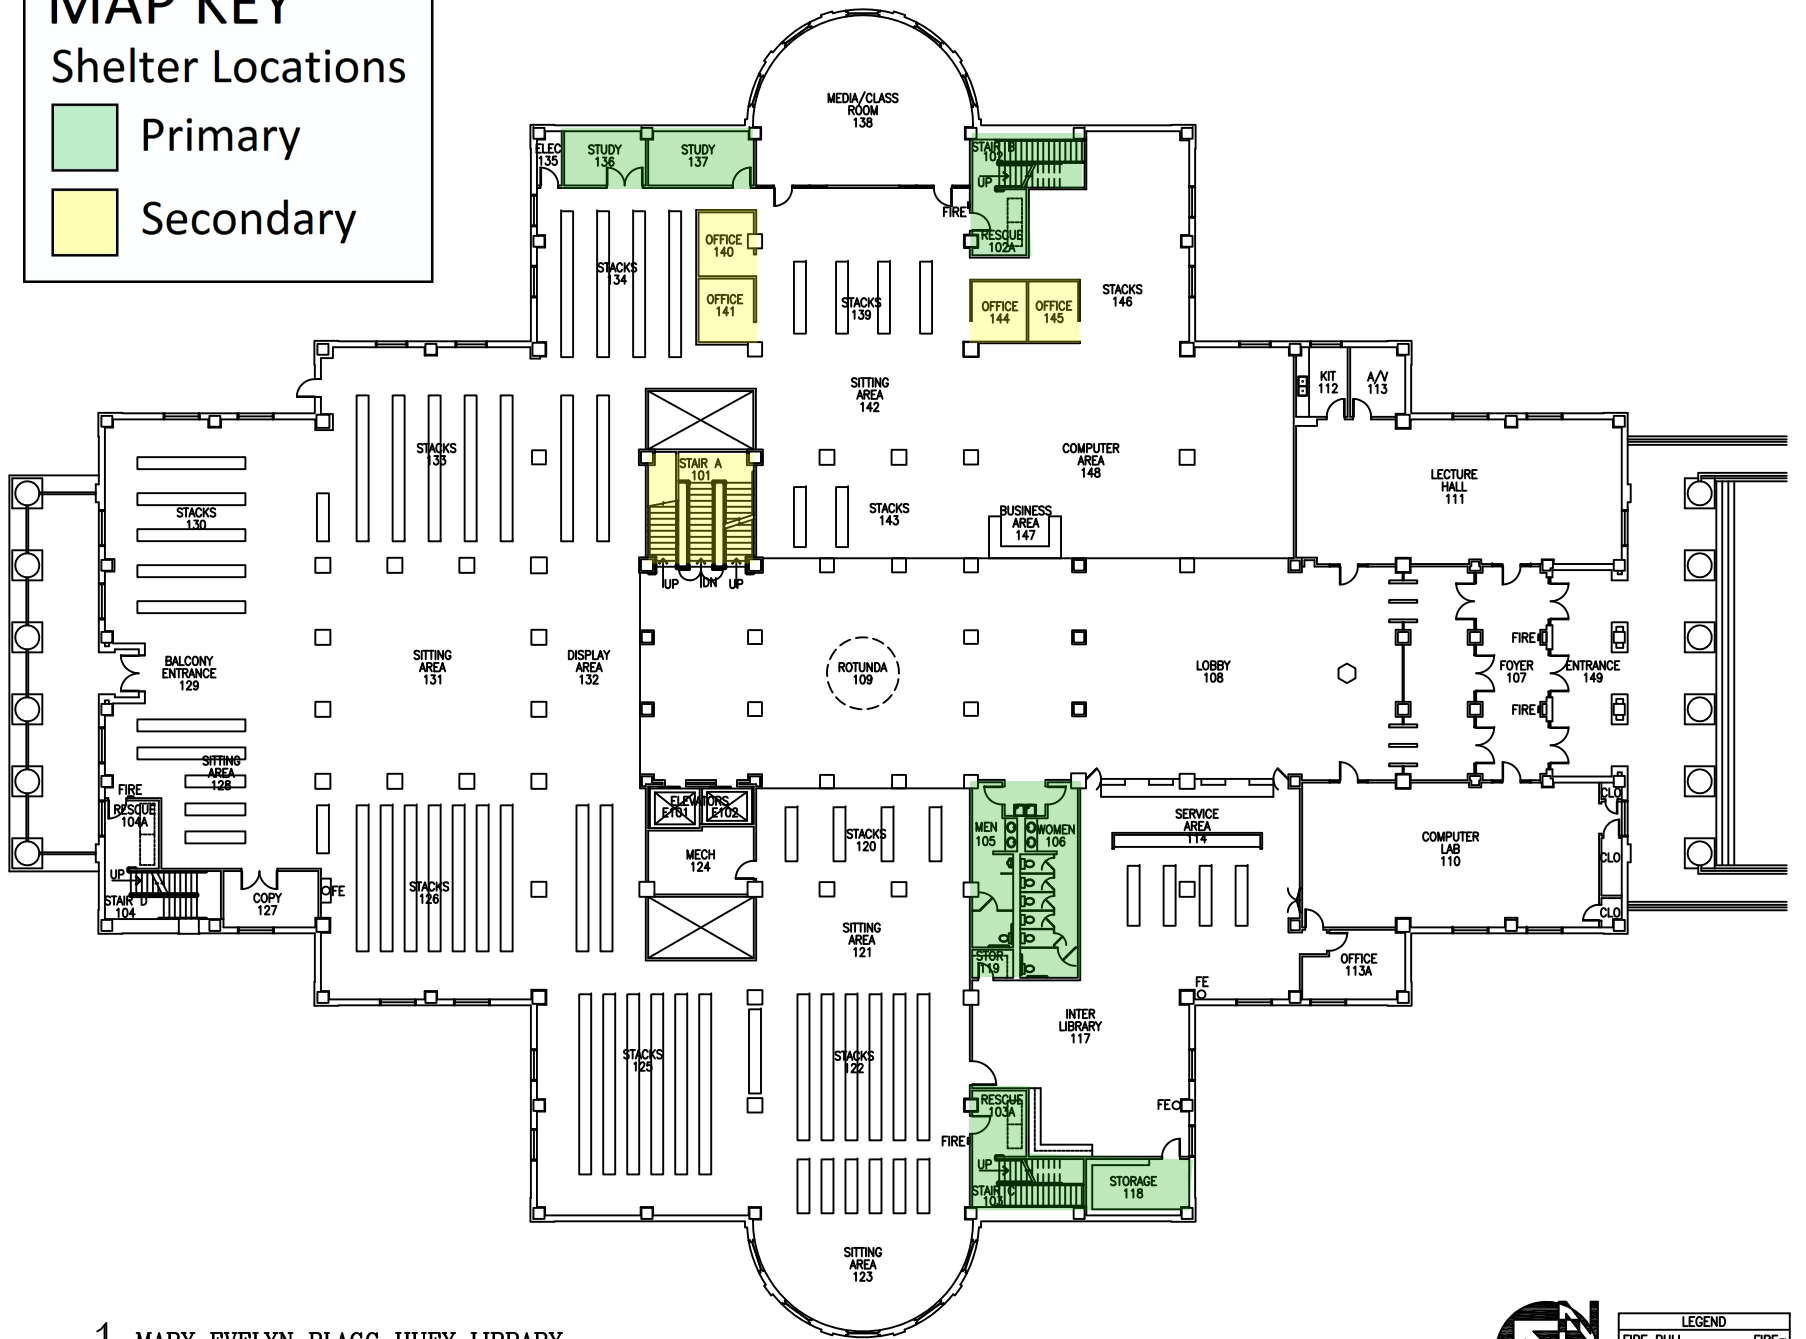

1 MARY EVELYN BLAGG HUEY LIBRARY  
1ST FLOOR PLAN

 SCALE: 1/32" = 1'-0"



LEGEND	
FIRE PULL	FIRE
FIRE EXTINGUISHER	FE
FIRE EXT IN CABINET	FE C
EYEWASH STATION	EW


# MAP KEY

## Shelter Locations


Primary

Secondary

REVISION			
01	03-05-14	N/A	UNKNOWN
02	04-12-19	BWW	NUMEROUS RENOVATIONS AS SHOWN BY REVISION CLOUDS

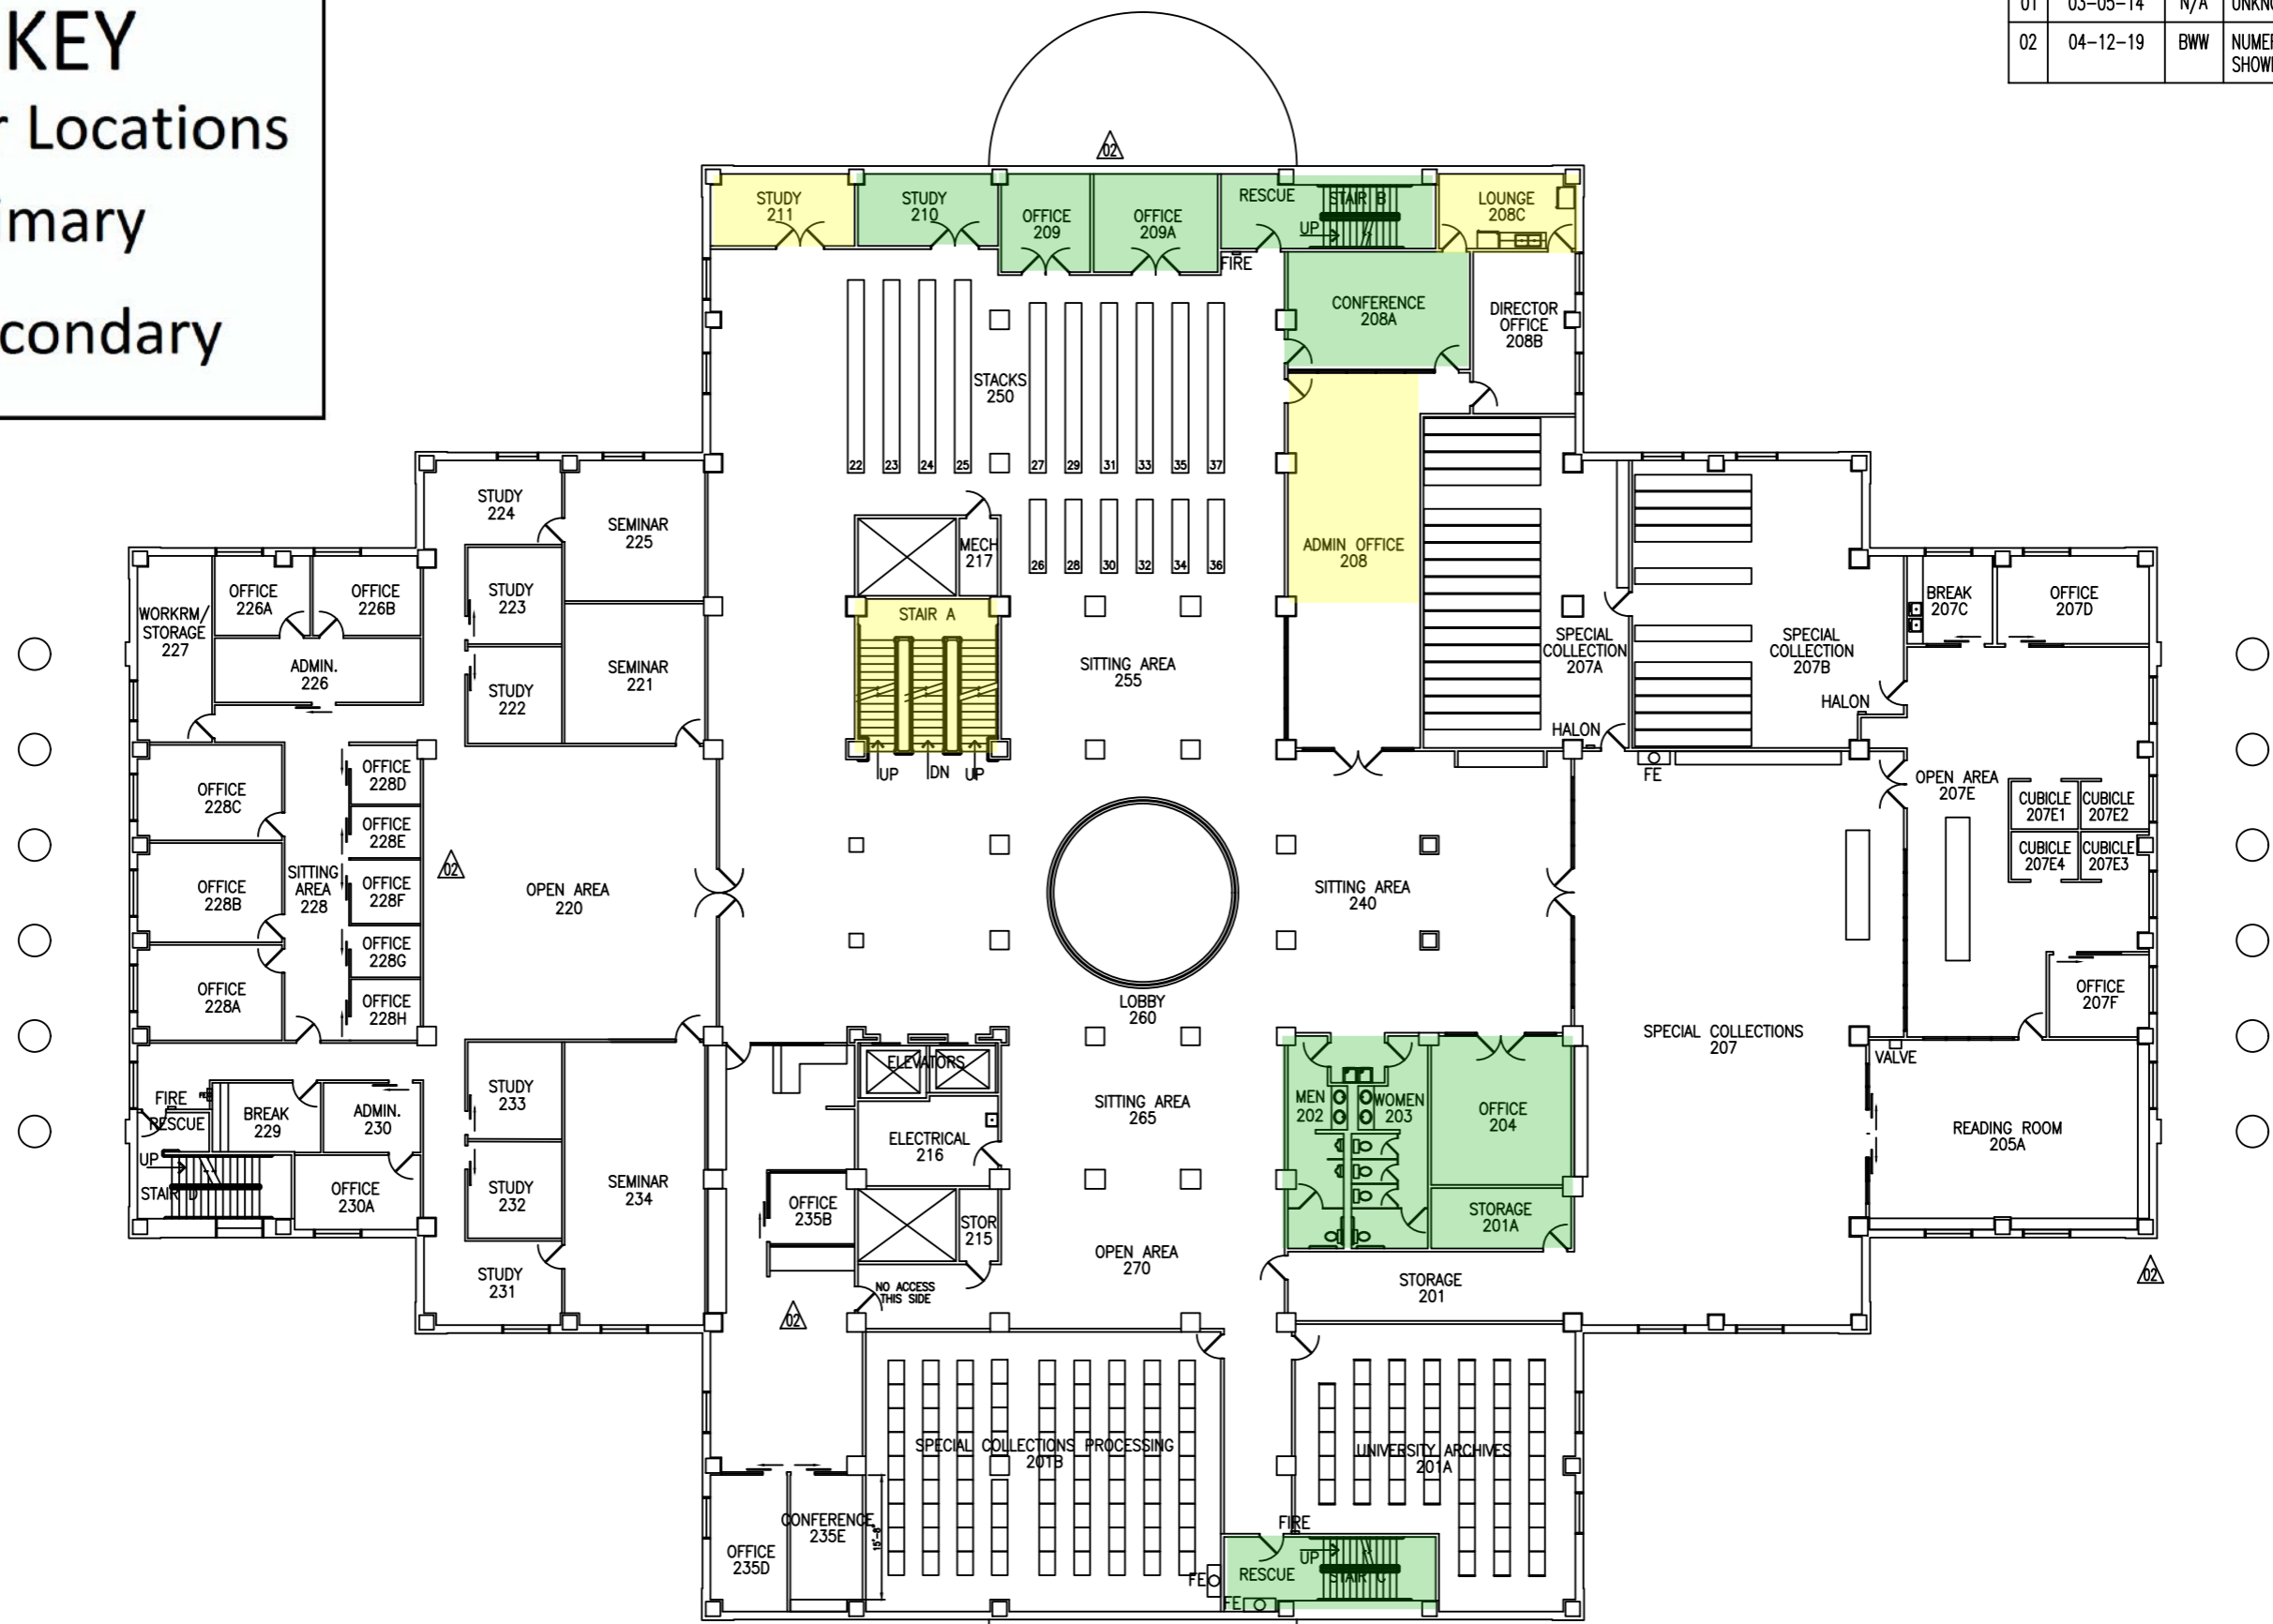

 1 MARY EVELYN BLAGG HUEY LIBRARY  
2ND FLOOR PLAN




LEGEND	
FIRE PULL	FIRE=
FIRE EXTINGUISHER	FE ○
FIRE EXT IN CABINET	FE □

# MAP KEY


## Shelter Locations

- Primary
- Secondary

REVISION			
01	03-06-14	N/A	UNKNOWN
02	04-12-19	BWW	NUMEROUS RENOVATIONS INDICATED BY ONE REVISION CLOUD

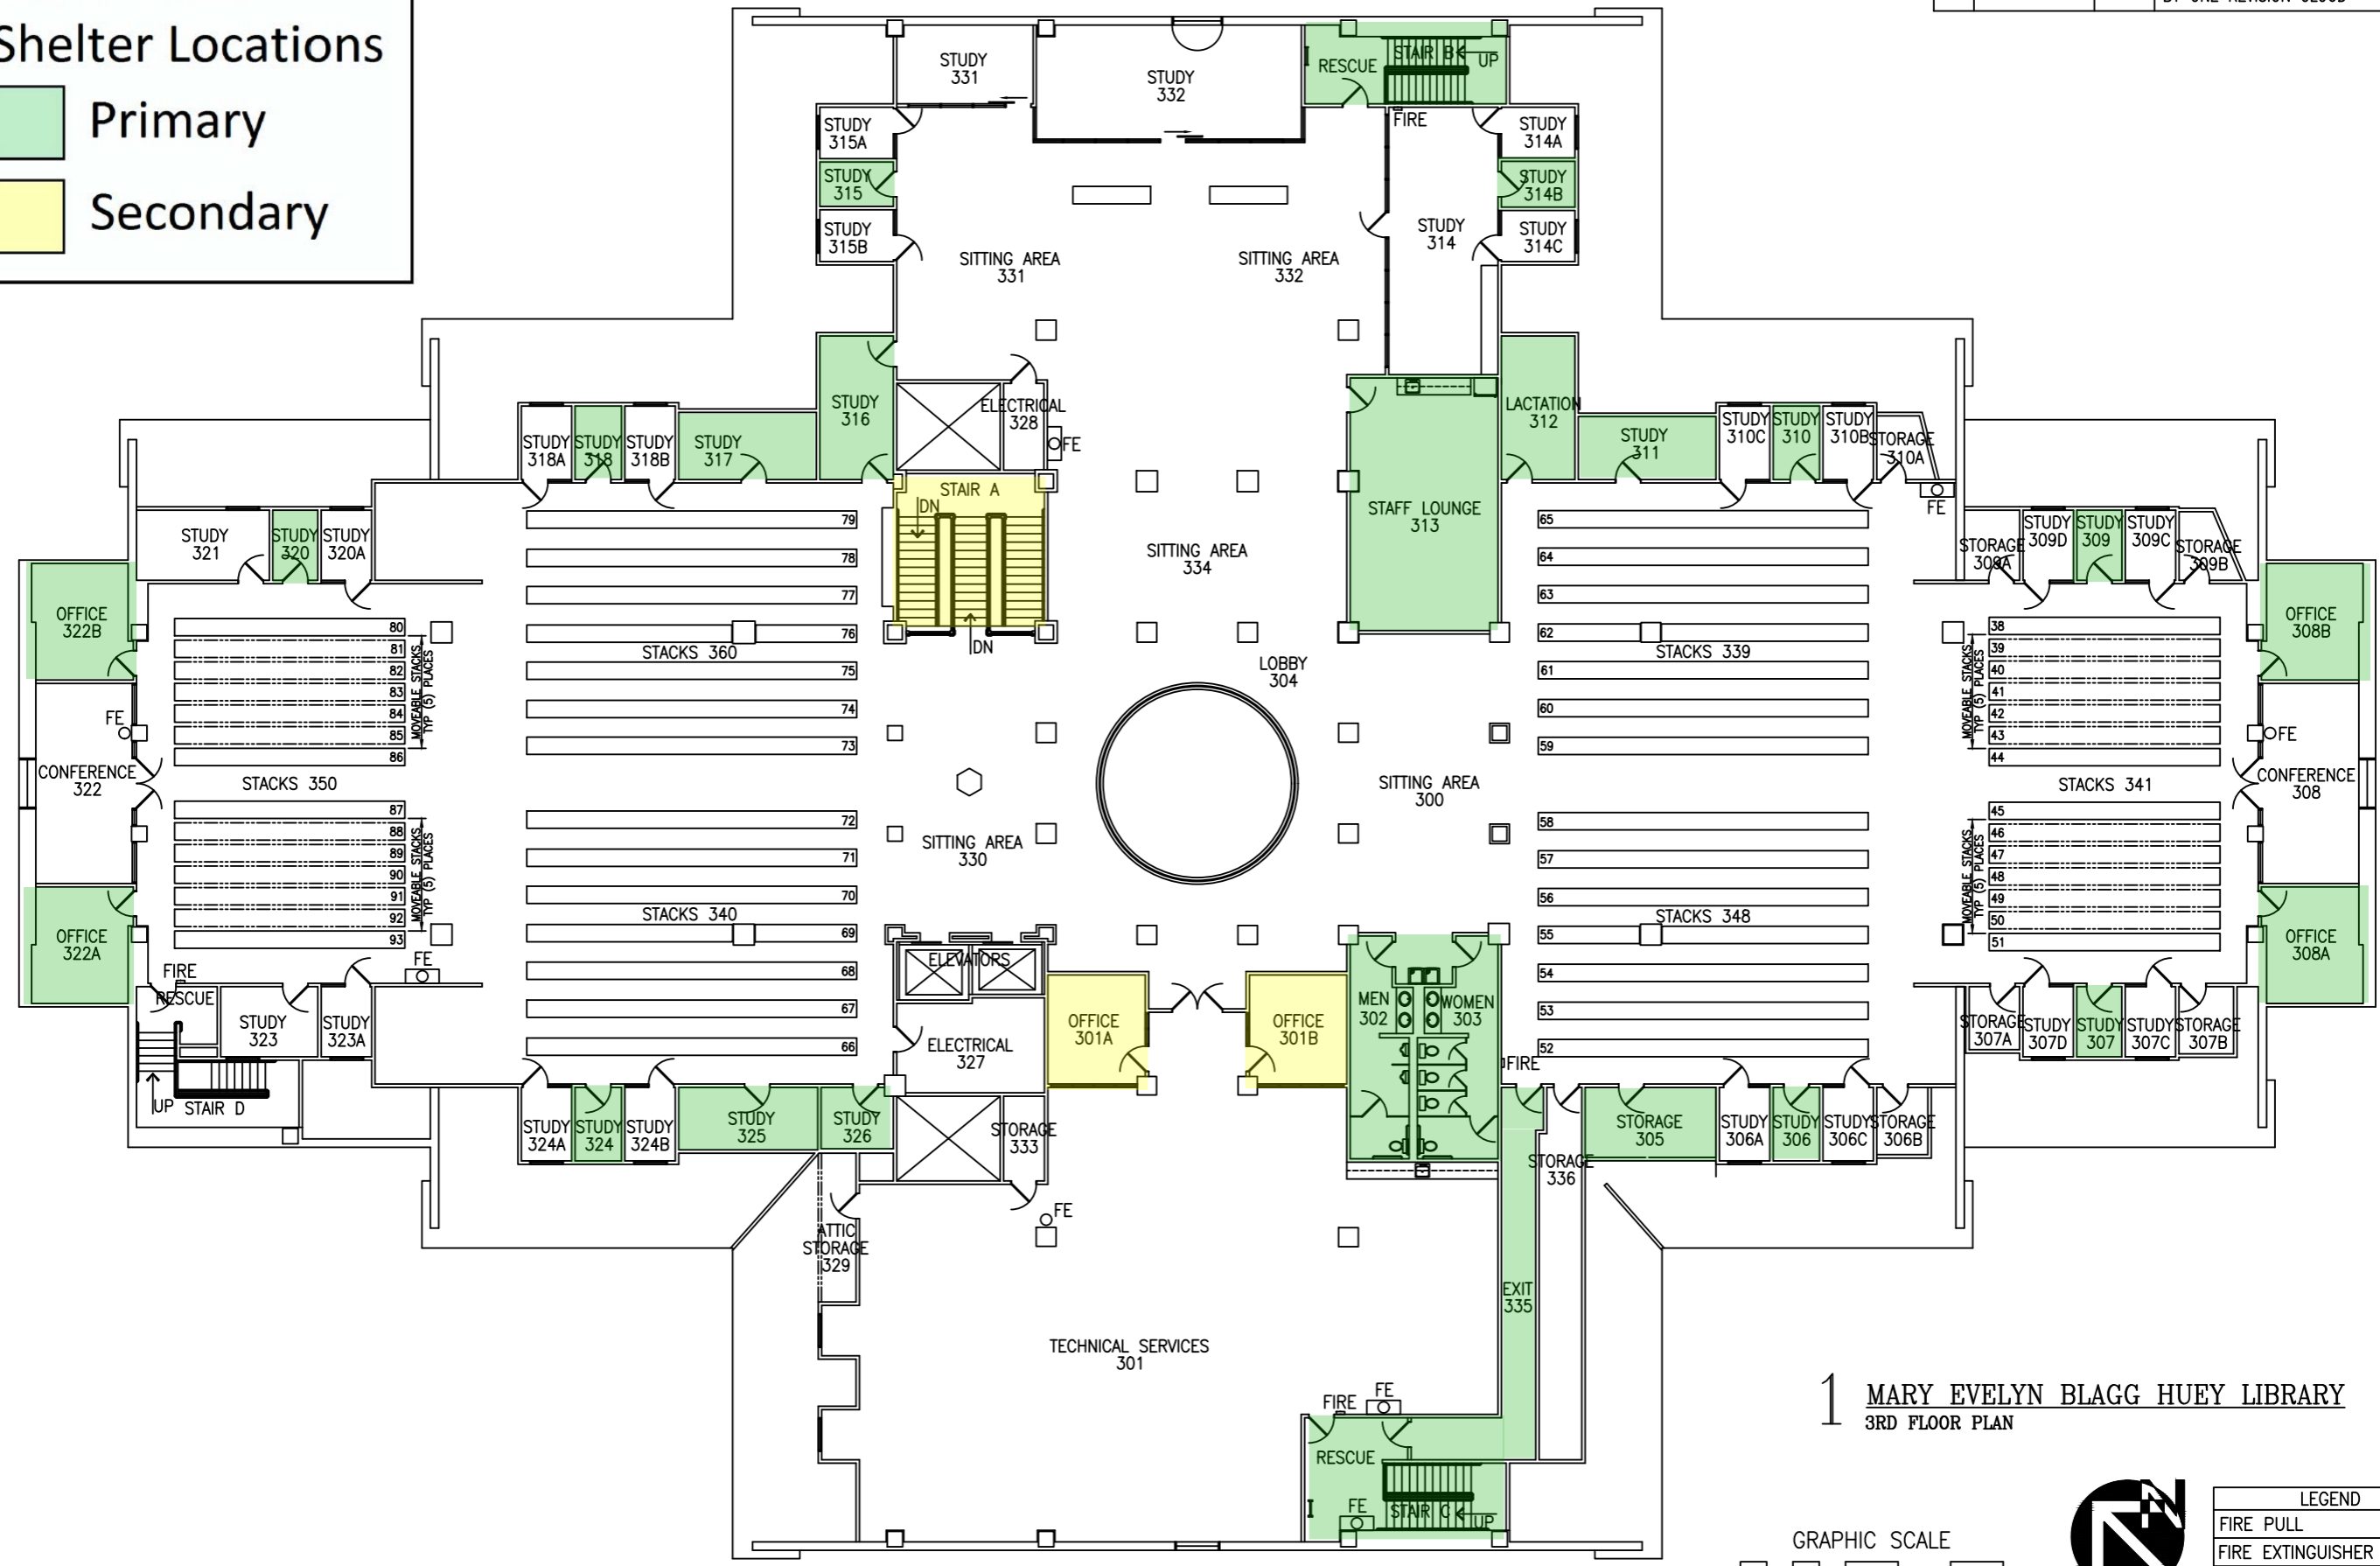

 1 MARY EVELYN BLAGG HUEY LIBRARY  
3RD FLOOR PLAN



LEGEND	
FIRE PULL	FIRE=
FIRE EXTINGUISHER	FE○
FIRE EXT IN CABINET	FE□