 


MAP KEY
 Shelter Locations

- Primary
- Secondary

1 OLD MAIN BUILDING
 1ST FLOOR PLAN

SCALE: 1/16" = 1'-0"



LEGEND

- FIRE PULL
- FIRE EXTINGUISHER
- FIRE
- FE

REVISION			
01	2013-03-14	N/A	INITIAL RELEASE
02	2023-03-30	BWW	TOO MANY REVISIONS TO INDICATED BY INDIVIDUAL REVISION CLOUD(S)/TRIANGLE(S)

GENERAL NOTE:
 01) DRAWING DISCLAIMER
 TEXAS WOMAN'S UNIVERSITY (TWU) HAS PROVIDED THIS DRAWING FOR REFERENCE USE ONLY WITH THE UNDERSTANDING IT SHALL NOT BE USED FOR CONSTRUCTION, DIMENSIONAL SCALING, OR ANY OTHER PURPOSE UNLESS SPECIFIED OTHERWISE IN WRITING BY TWU. TWU IS NOT RESPONSIBLE FOR DRAWING ERRORS; THEREFORE, ALL DRAWING INFORMATION MUST BE VERIFIED BY OTHERS PRIOR TO USE.
 02) EXTERIOR DOOR LOCATED @ INTERMEDIATE LEVEL BETWEEN FLOOR 001 & 002; REFERENCE DRAWING A1 FOR DETAILS.
 03) 2019 RENOVATION WALLED OVER/COVERED EXISTING INTERIOR WINDOW SURFACE
 04) EXTERIOR WINDOW COVERED/REPLACED BY VENT LOUVERS



TEXAS WOMAN'S UNIVERSITY
 FACILITIES MANAGEMENT & CONSTRUCTION DEPT.
 PHYSICAL PLANT SERVICES CENTER DENTON, TEXAS

UPDATED
 2023-03-30
 REVISION # 02


OLD MAIN BUILDING
 SECOND FLOOR PLAN - AS-BUILT

PROJECT NUMBER


SHEET

A2

OF 4

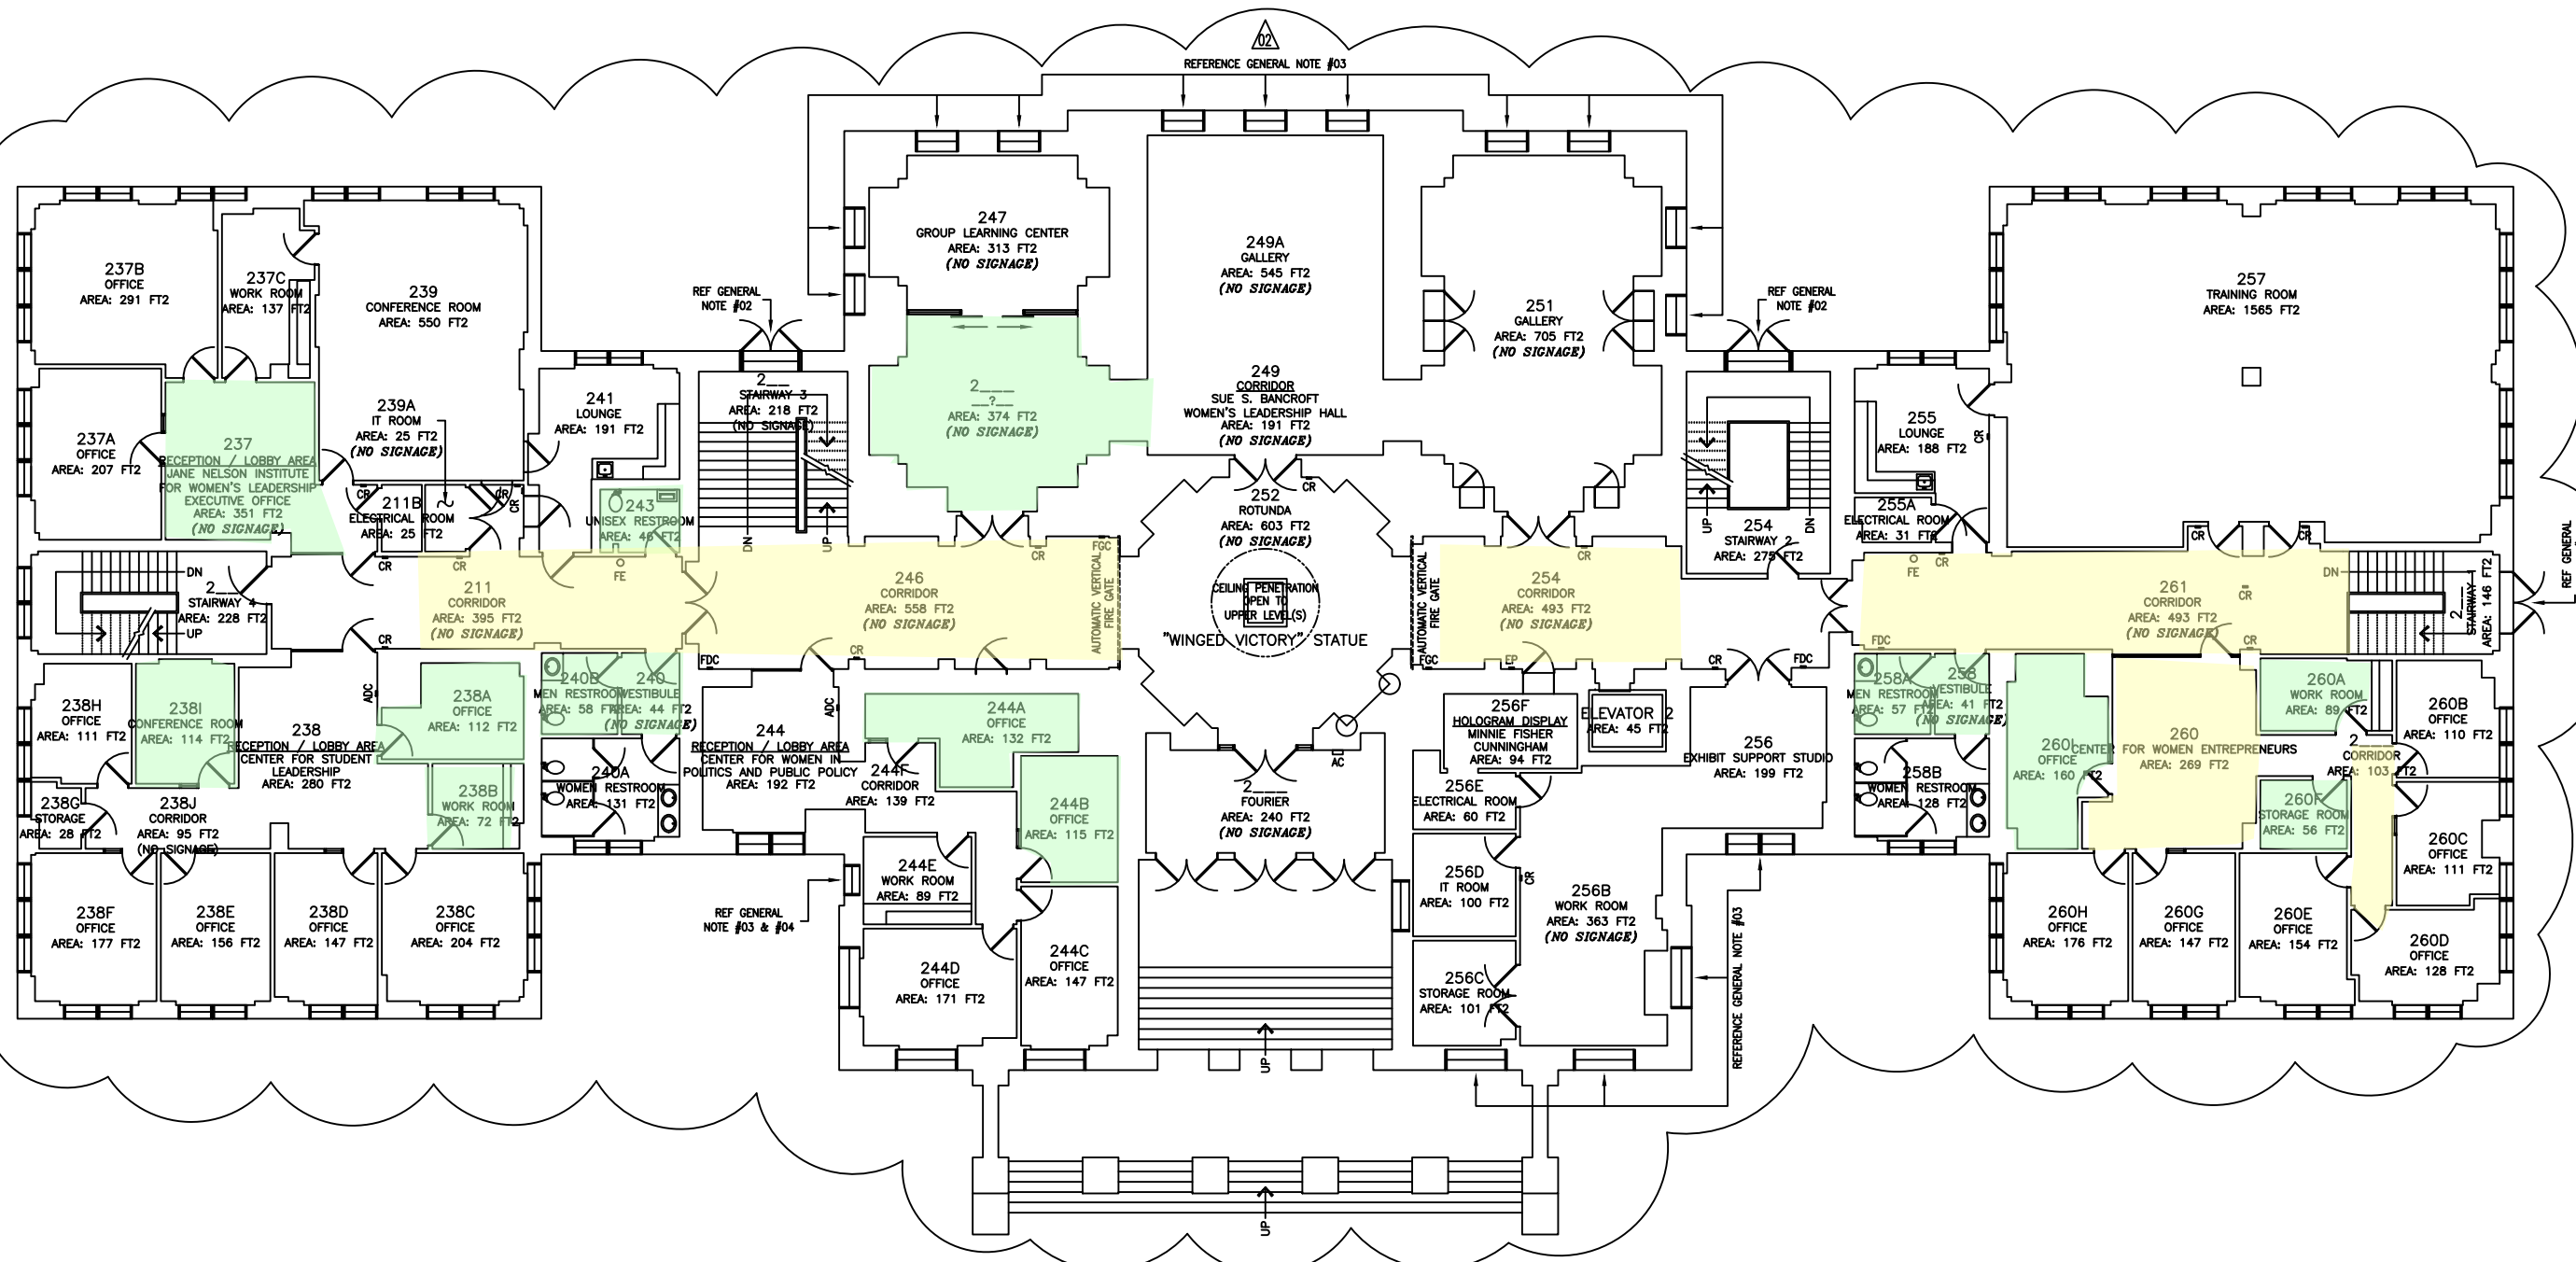


 1 OLD MAIN BUILDING
 2ND FLOOR PLAN SCALE: 1/8" = 1'-0"



LEGEND	
FIRE EXTINGUISHER	FE ○
FIRE PHONE	FP =
FIRE GATE CONTROL	FGC =
AUTOMATIC DOOR CONTROL	ADC =
CARD READER	CR =



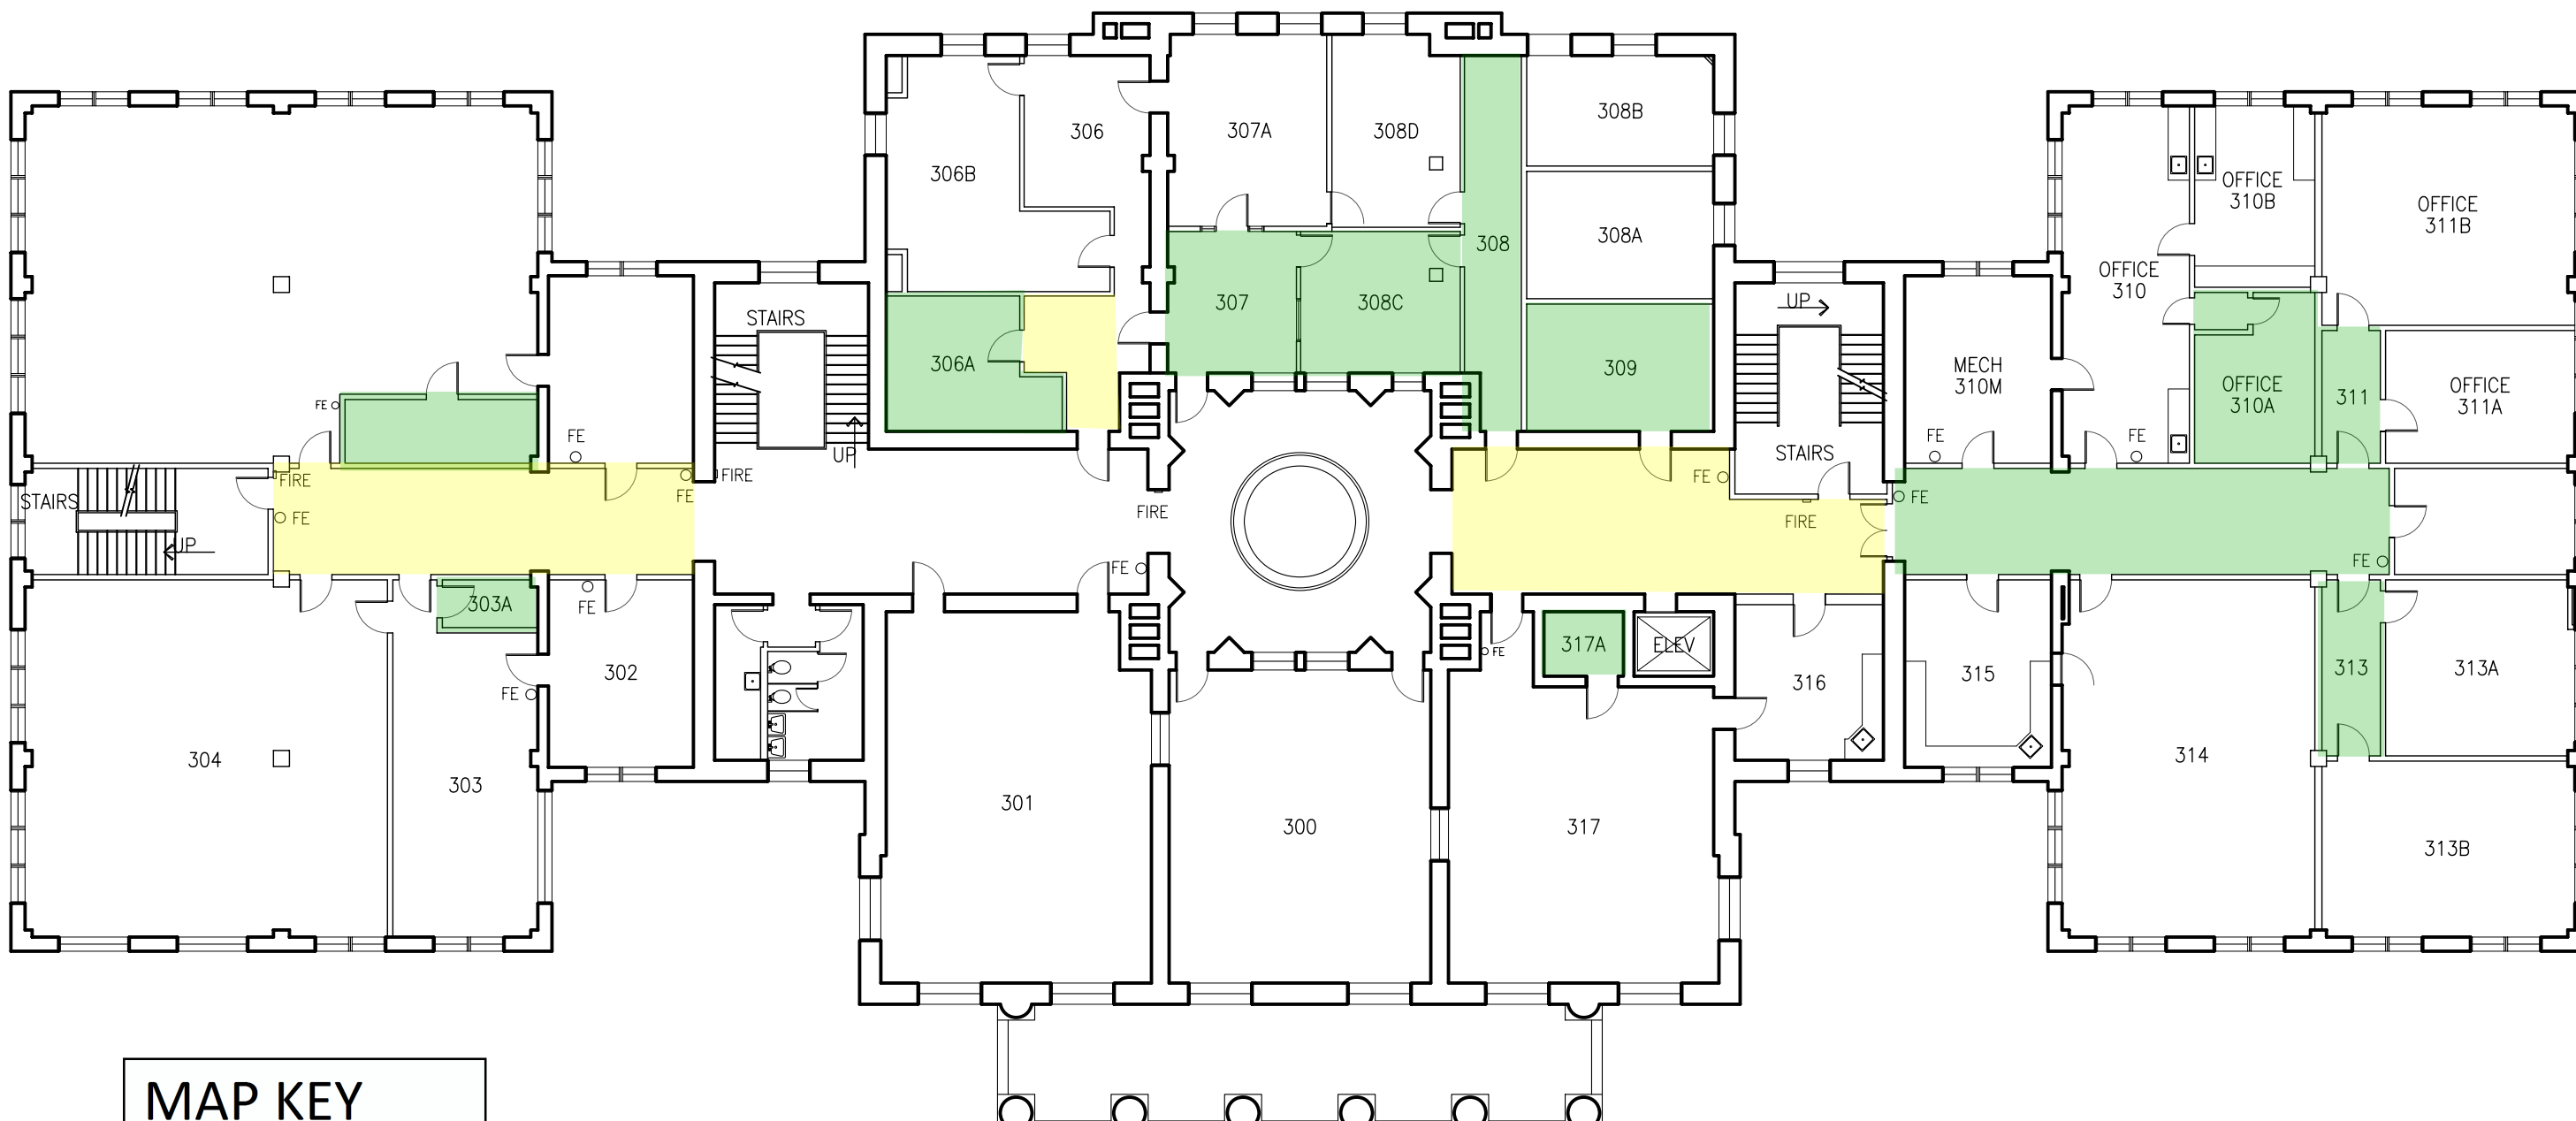


MAP KEY
 Shelter Locations

- Primary
- Secondary

1 OLD MAIN BUILDING
 3RD FLOOR PLAN

 SCALE: 1/16" = 1'-0"



LEGEND

	FIRE PULL		FIRE EXTINGUISHER
	FIRE PULL		FIRE EXTINGUISHER



REVISION			
01	2013-02-11	N/A	INITIAL RELEASE
02	2023-03-14	BWW	TOO MANY REVISIONS TO INDICATED BY INDIVIDUAL REVISION CLOUD(S)/TRIANGLE(S)

GENERAL NOTE:
 01) DRAWING DISCLAIMER
 TEXAS WOMAN'S UNIVERSITY (TWU) HAS PROVIDED THIS DRAWING FOR REFERENCE USE ONLY WITH THE UNDERSTANDING IT SHALL NOT BE USED FOR CONSTRUCTION, DIMENSIONAL SCALING, OR ANY OTHER PURPOSE UNLESS SPECIFIED OTHERWISE IN WRITING BY TWU. TWU IS NOT RESPONSIBLE FOR DRAWING ERRORS; THEREFORE, ALL DRAWING INFORMATION MUST BE VERIFIED BY OTHERS PRIOR TO USE.
 02) ONE-WAY MIRROR VIEW IS FROM ROOM #411 TO #411C




TEXAS WOMAN'S UNIVERSITY
 FACILITIES MANAGEMENT & CONSTRUCTION DEPT.
 PHYSICAL PLANT SERVICES CENTER DENTON, TEXAS

UPDATED
 2023-03-14
 REVISION # 02

OLD MAIN BUILDING
 FOURTH FLOOR PLAN - AS-BUILT

PROJECT NUMBER

SHEET
 A4
 OF 4

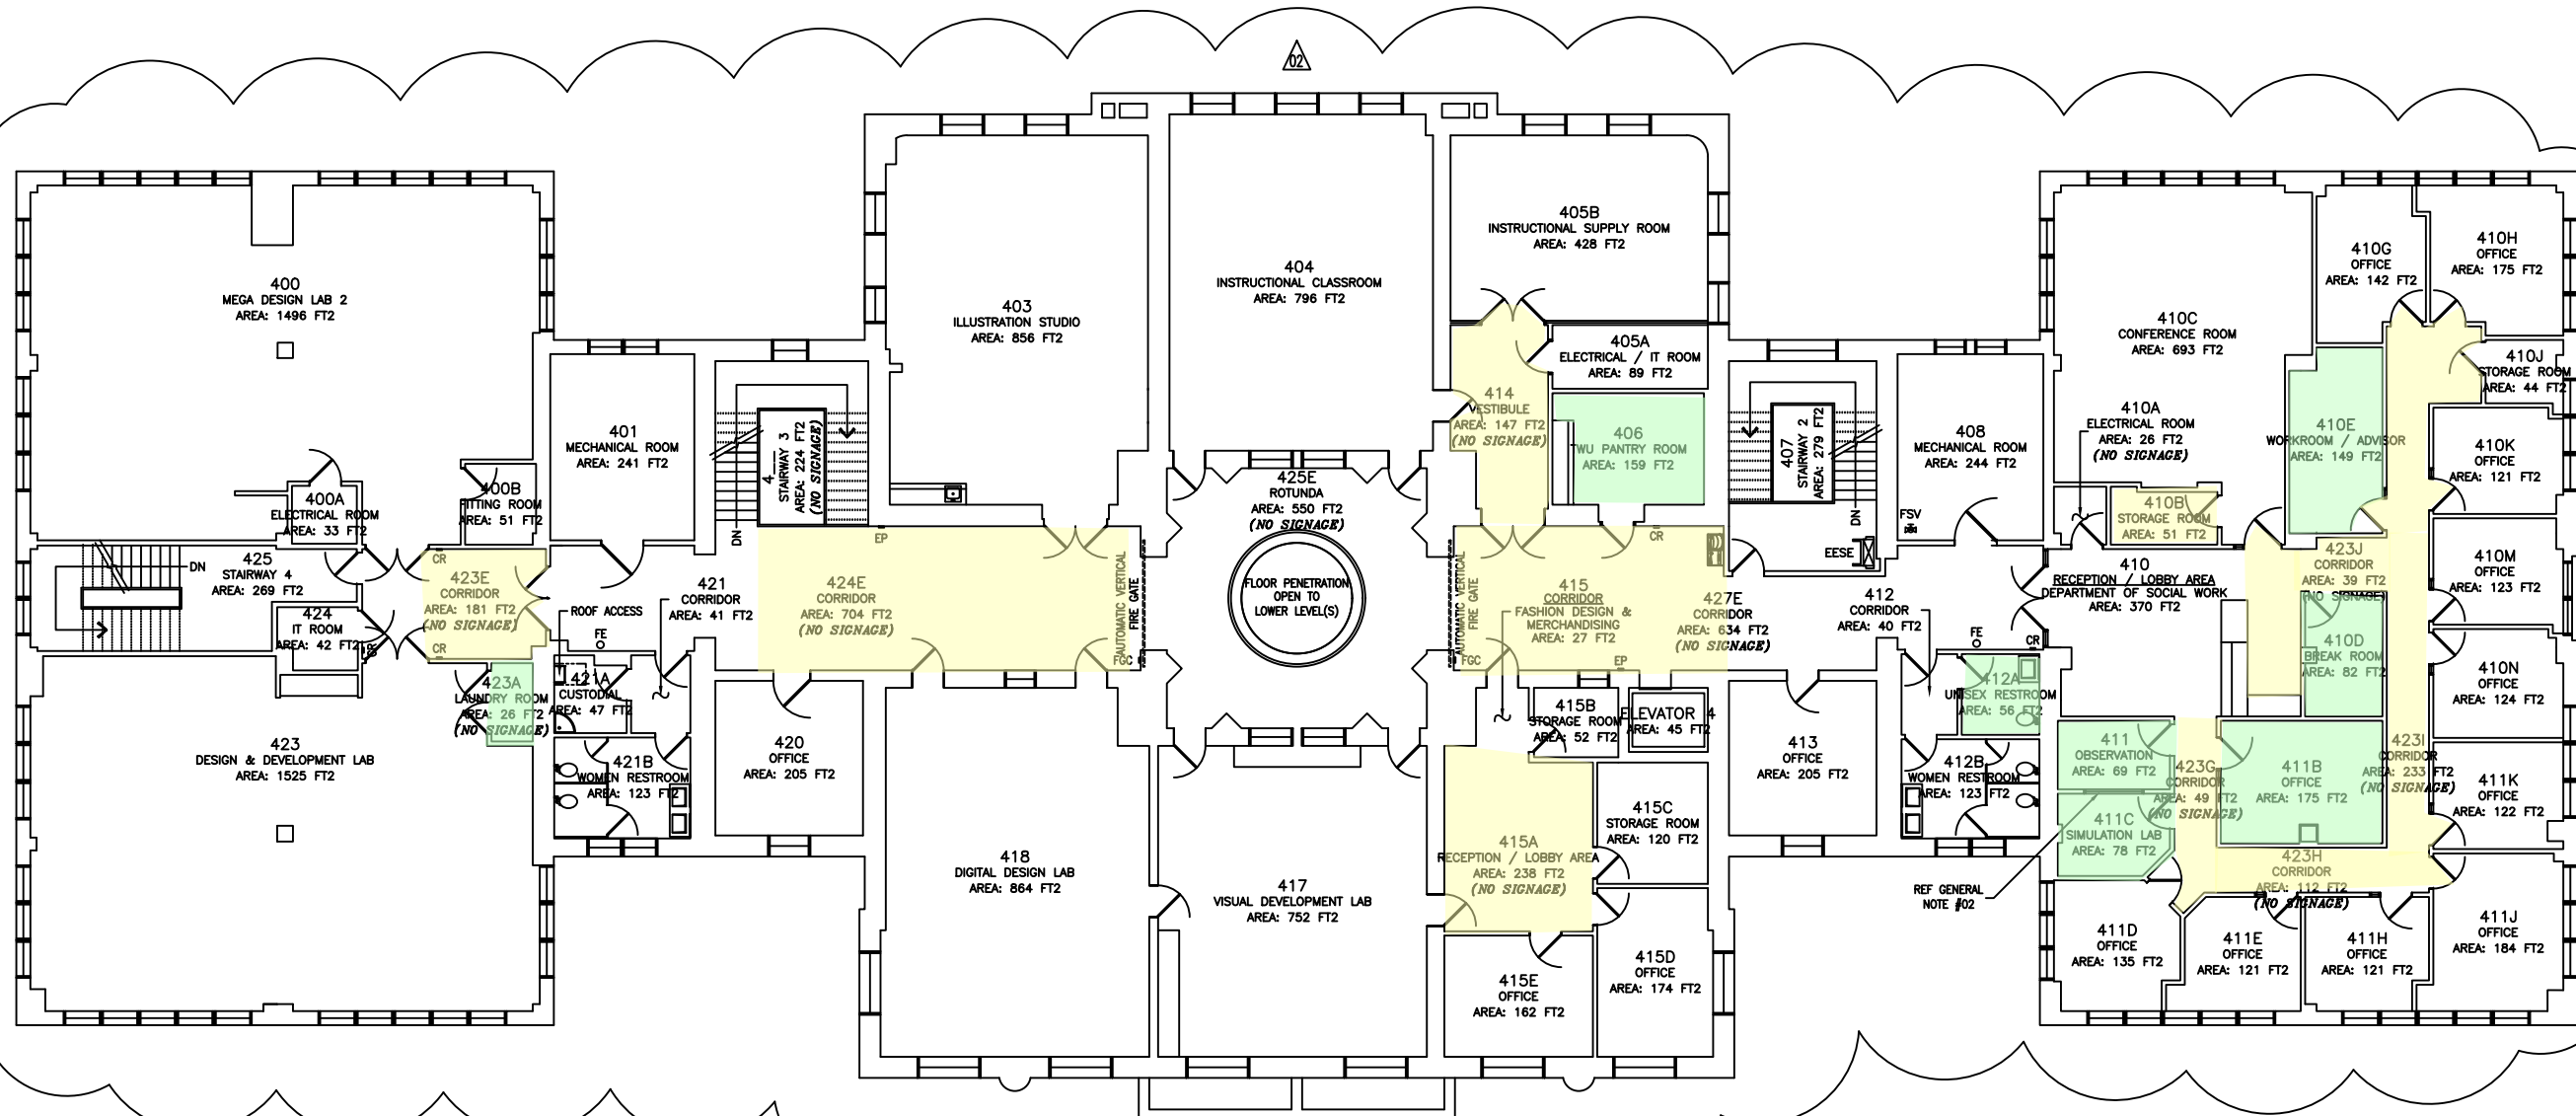

MAP KEY
 Shelter Locations
 Primary
 Secondary

1 OLD MAIN BUILDING
 4TH FLOOR PLAN
 SCALE: 1/8" = 1'-0"



LEGEND	
FIRE EXTINGUISHER	FE ○
FIRE PHONE	FP =
FIRE GATE CONTROL	FGC =
FIRE SUPPRESSION VALVE	FSV [Symbol]
EMERGENCY EVACUATION STAIR EQUIPMENT	ESEE [Symbol]
CARD READER	CR =

