

TEXAS WOMAN'S UNIVERSITY
 FACILITIES MANAGEMENT & CONSTRUCTION DEPT.
 PHYSICAL PLANT SERVICES CENTER DENTON, TEXAS


UPDATED
 8/15/2008
 REVISION #

PIONEER HALL
 BUILDING
 FIRST FLOOR PLAN - AS-BUILT


PROJECT NUMBER

SHEET
 A2

OF 4

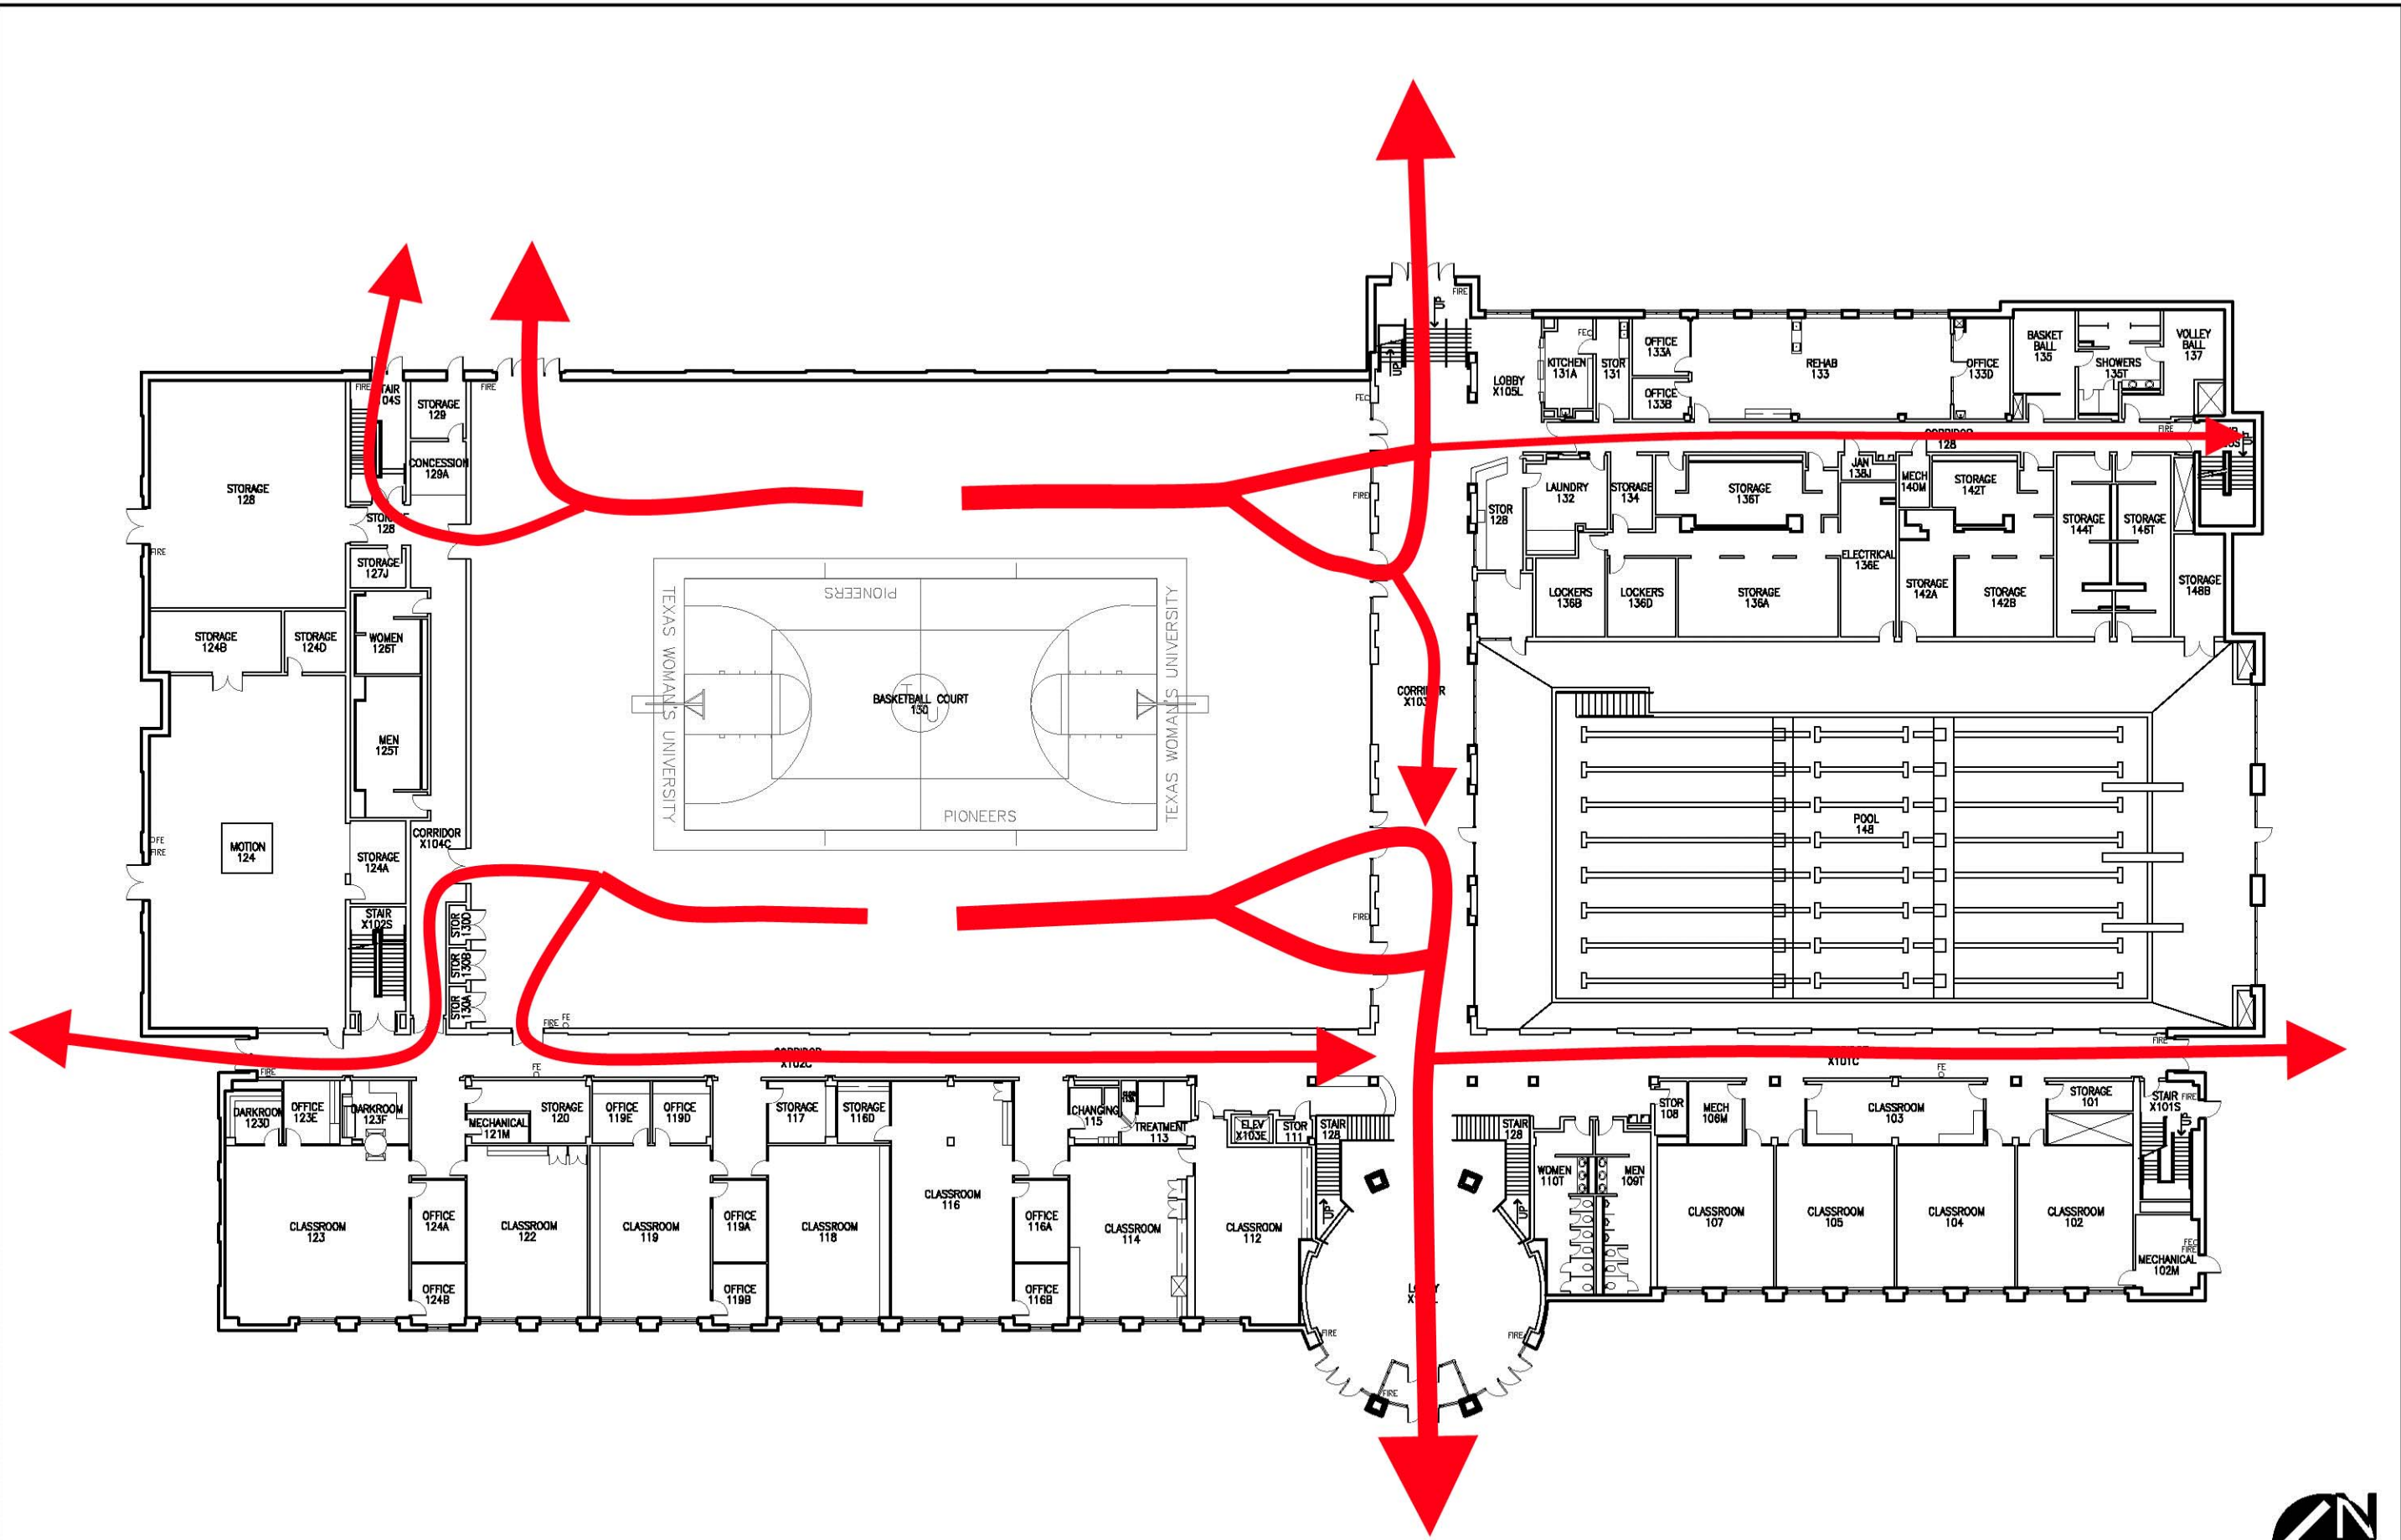

 1 PIONEER HALL BUILDING
 1ST FLOOR PLAN SCALE: 1/32" = 1'-0"



LEGEND	
	FIRE PULL
	FIRE EXTINGUISHER
	FIRE- FE-O