


**Key:Firewall: all penetrations must be firestopped**  
**All penetrations into floors must be firestopped**

**1 STUDENT CENTER BUILDING**  
 BASEMENT FLOOR PLAN  
 SCALE: 1/16" = 1'-0"




**LEGEND**

	FIRE PULL
	FIRE EXTINGUISHER
	FIRE EXTINGUISHER FE

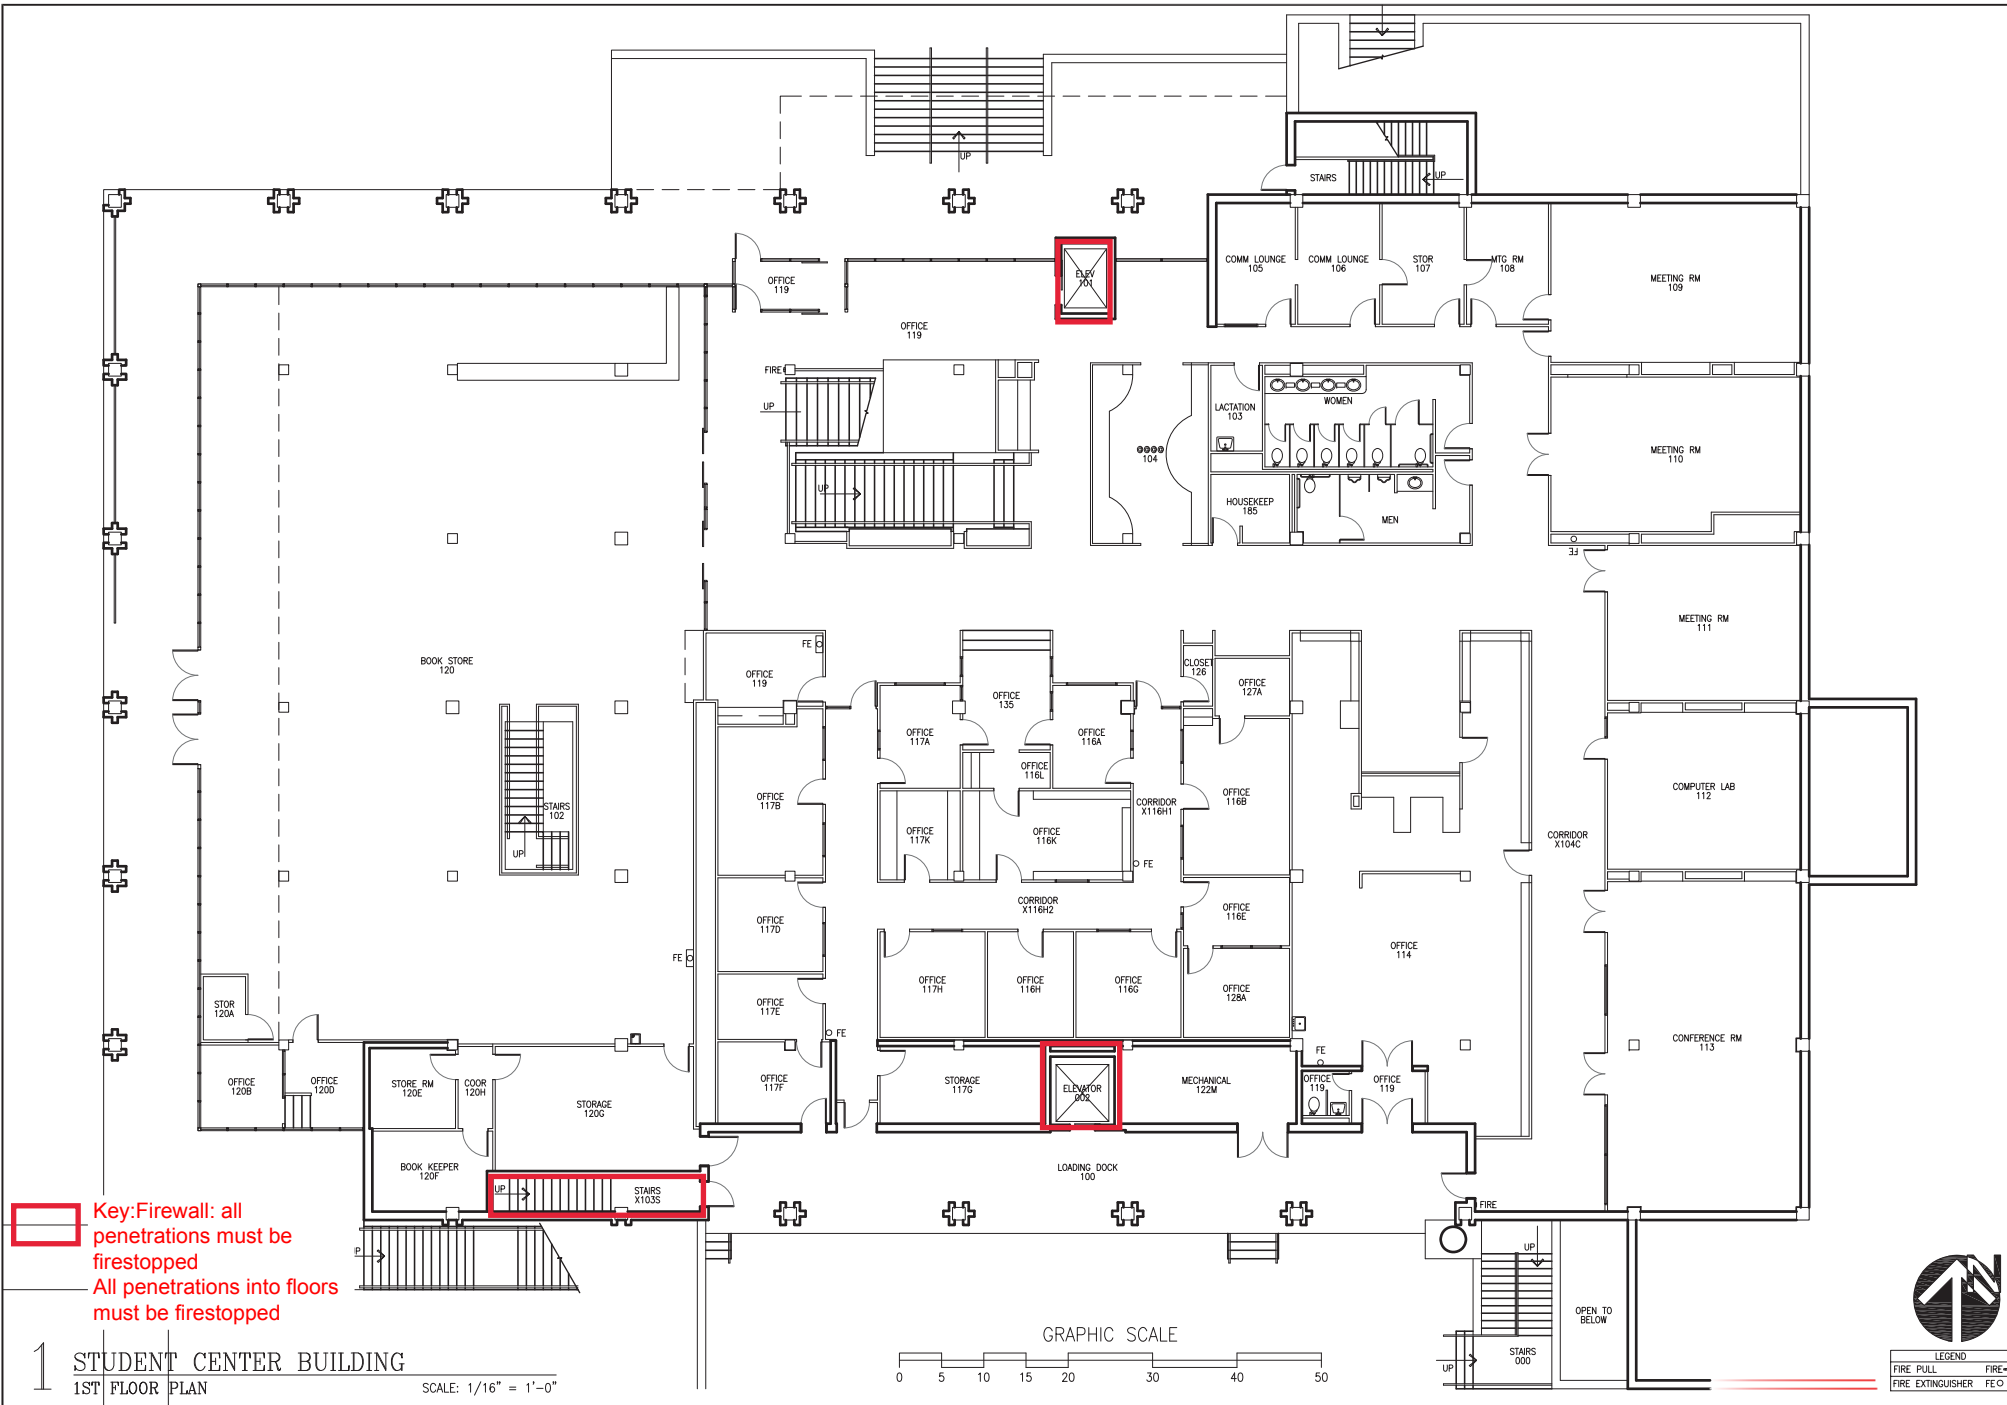


**Key: Firewall: all penetrations must be firestopped**  
**All penetrations into floors must be firestopped**

 **1 STUDENT CENTER BUILDING**  
 1ST FLOOR PLAN  
 SCALE: 1/16" = 1'-0"



LEGEND  
 FIRE PULL  
 FIRE EXTINGUISHER  
 FIRE EXTINGUISHER FCO

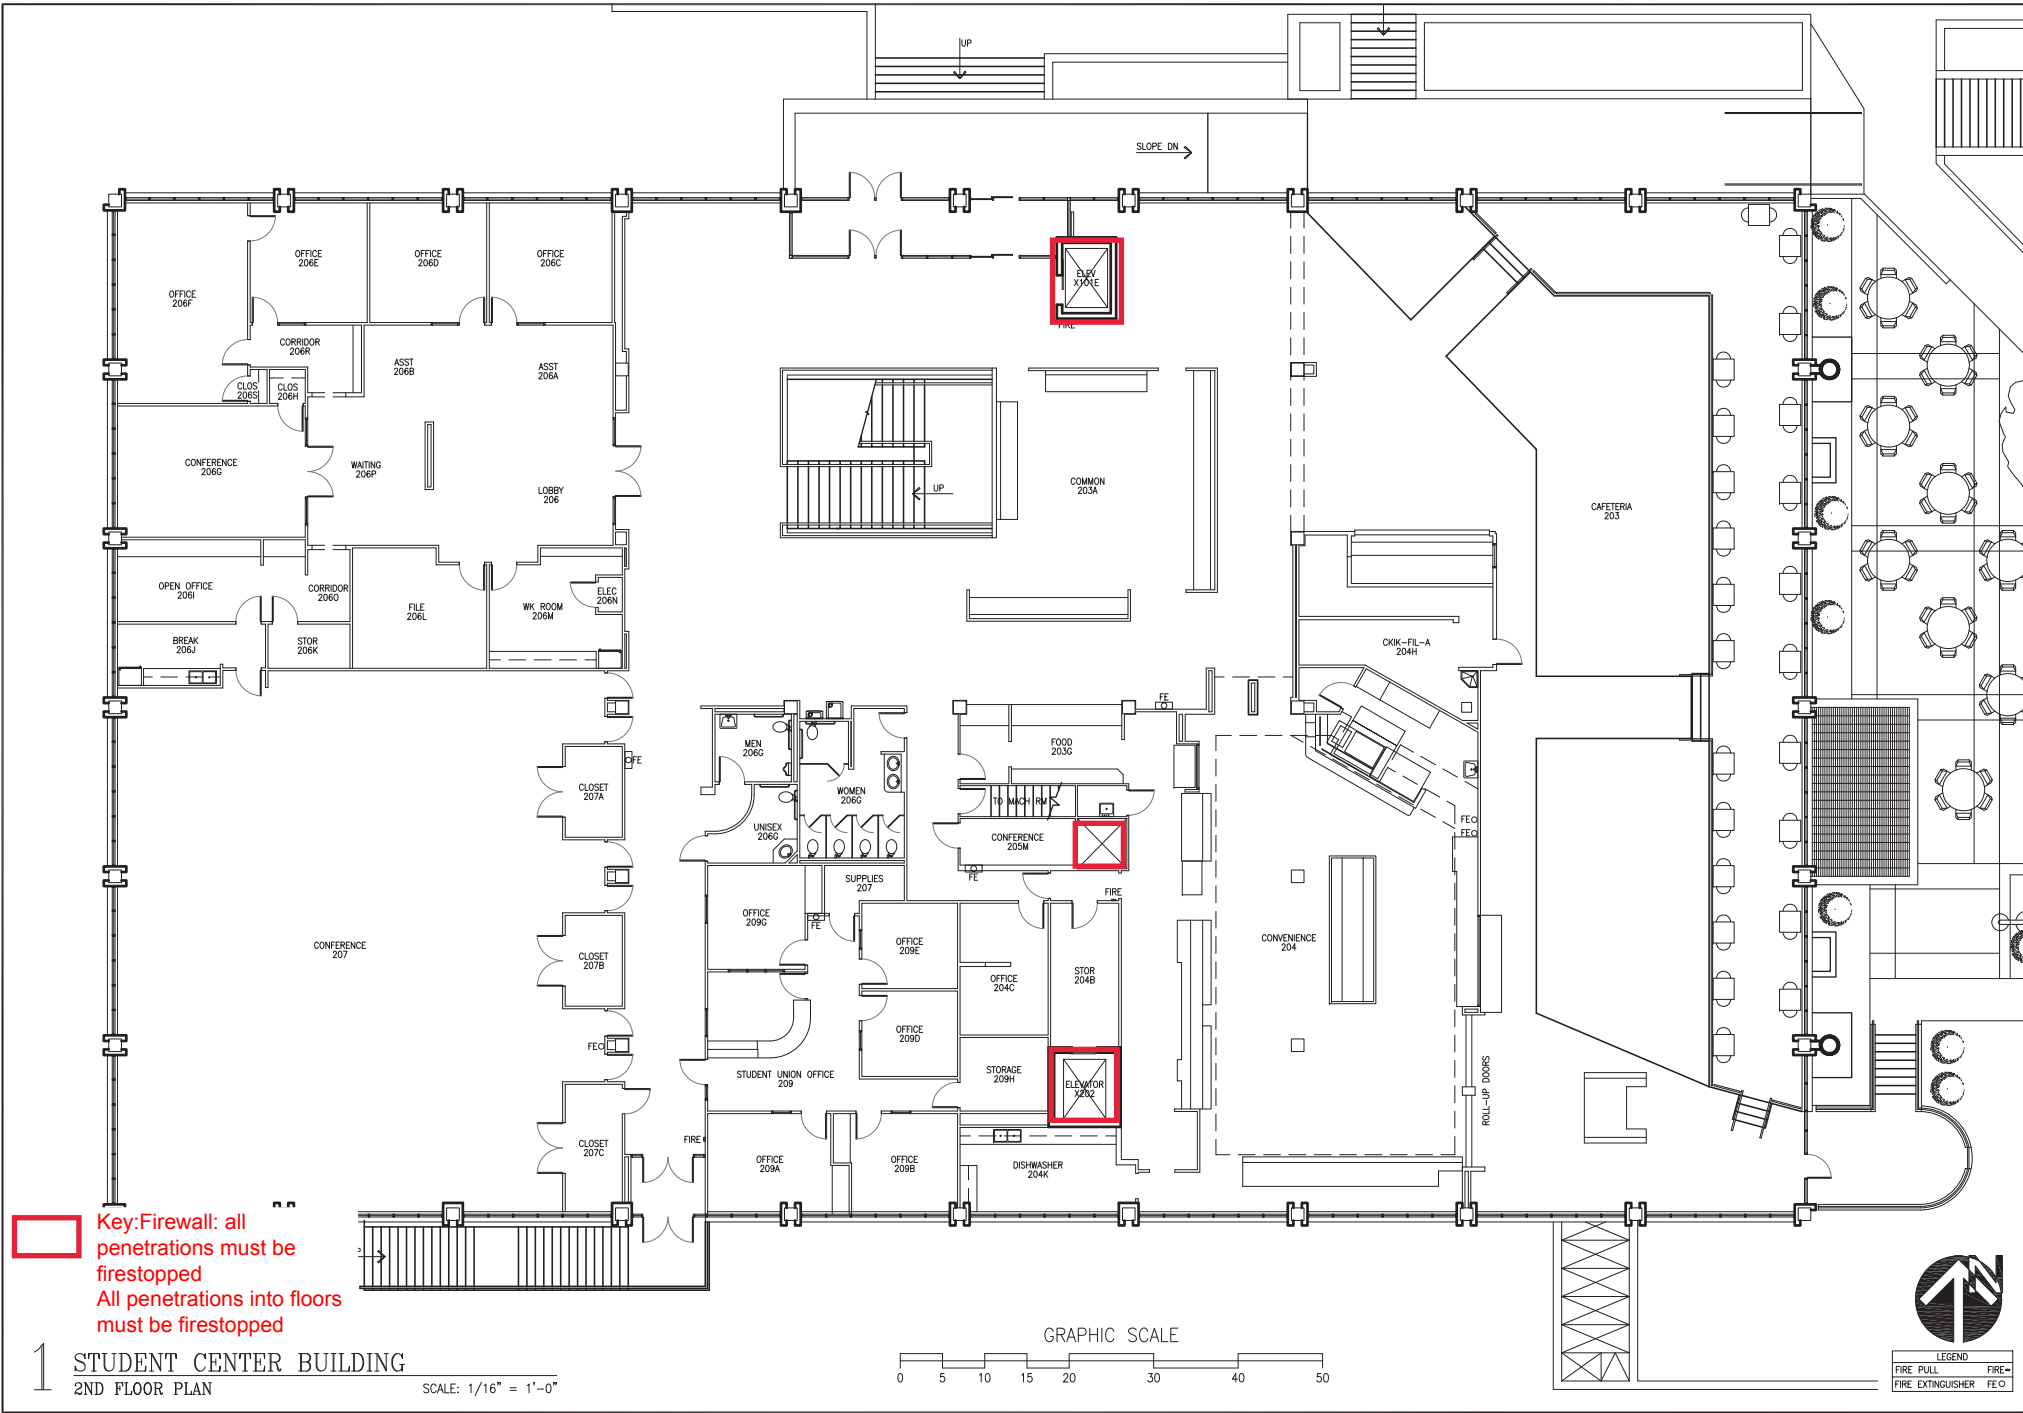

**Key: Firewall: all penetrations must be firestopped**  
**All penetrations into floors must be firestopped**


**1 STUDENT CENTER BUILDING**  
 2ND FLOOR PLAN

SCALE: 1/16" = 1'-0"




**LEGEND**

FIRE PULL FIRE-  
 FIRE EXTINGUISHER FEO

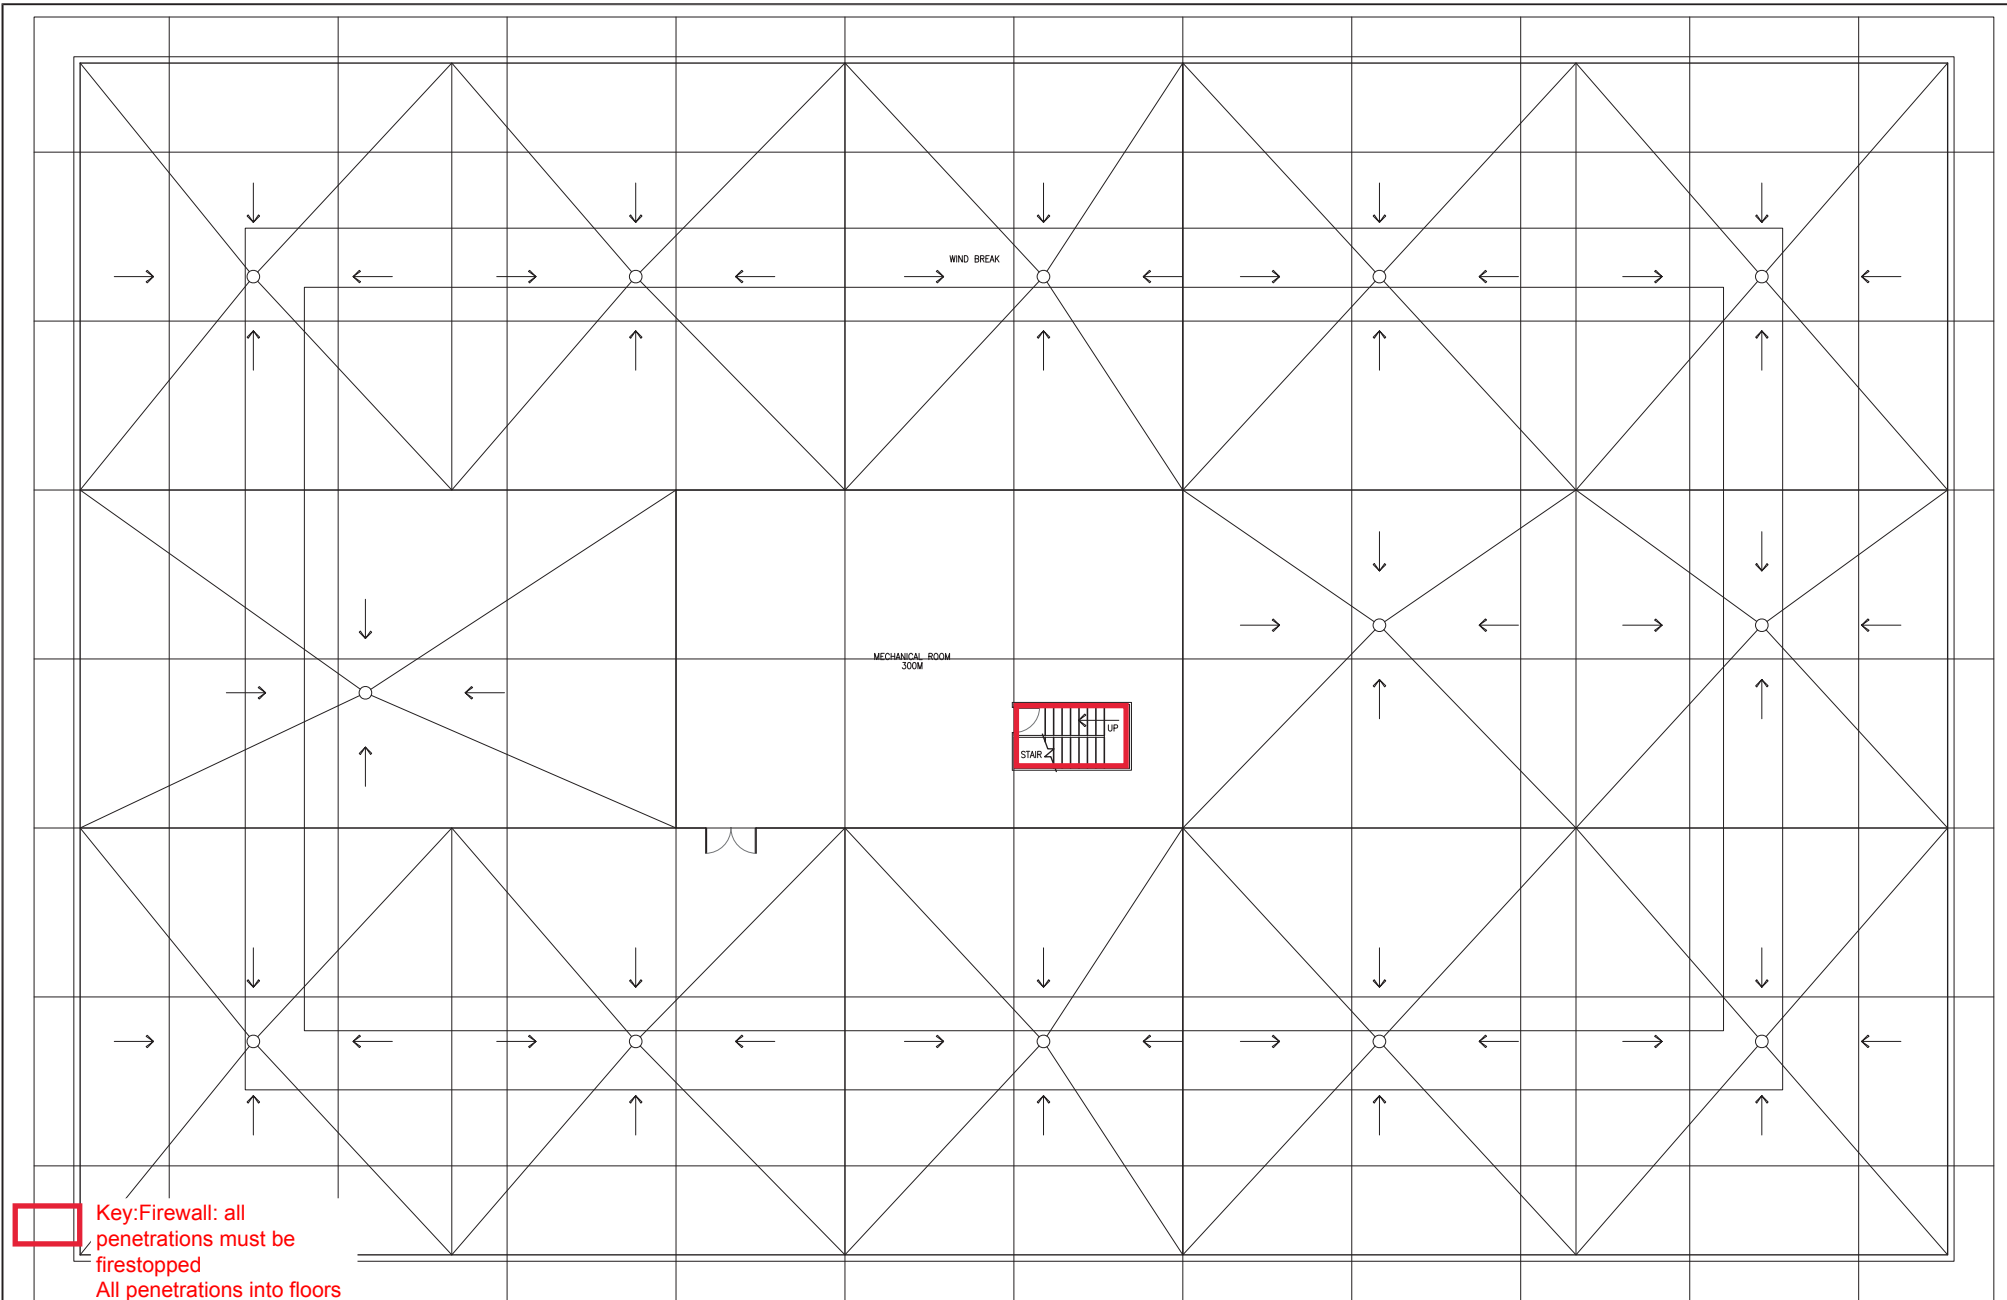

Key: Firewall: all penetrations must be firestopped  
 All penetrations into floors must be firestopped

 **1** STUDENT CENTER BUILDING  
 ROOF PLAN  
 SCALE: 1/16" = 1'-0"



LEGEND	
FIRE PULL	FIRE
FIRE EXTINGUISHER	FEO