 


**Shelter Locations**

Primary
  Secondary

1 STUDENT CENTER BUILDING  
 BASEMENT FLOOR PLAN  
 SCALE: 1/16" = 1'-0"



LEGEND

FIRE PULL	FIRE
FIRE EXTINGUISHER	FEO

 
Shelter Locations

- Primary
- Secondary



1 STUDENT CENTER BUILDING  
1ST FLOOR PLAN


SCALE: 1/16" = 1'-0"



LEGEND	
	FIRE PULL
	FIRE EXTINGUISHER
	FIRE
	FE

Shelter Locations

- Primary
- Secondary

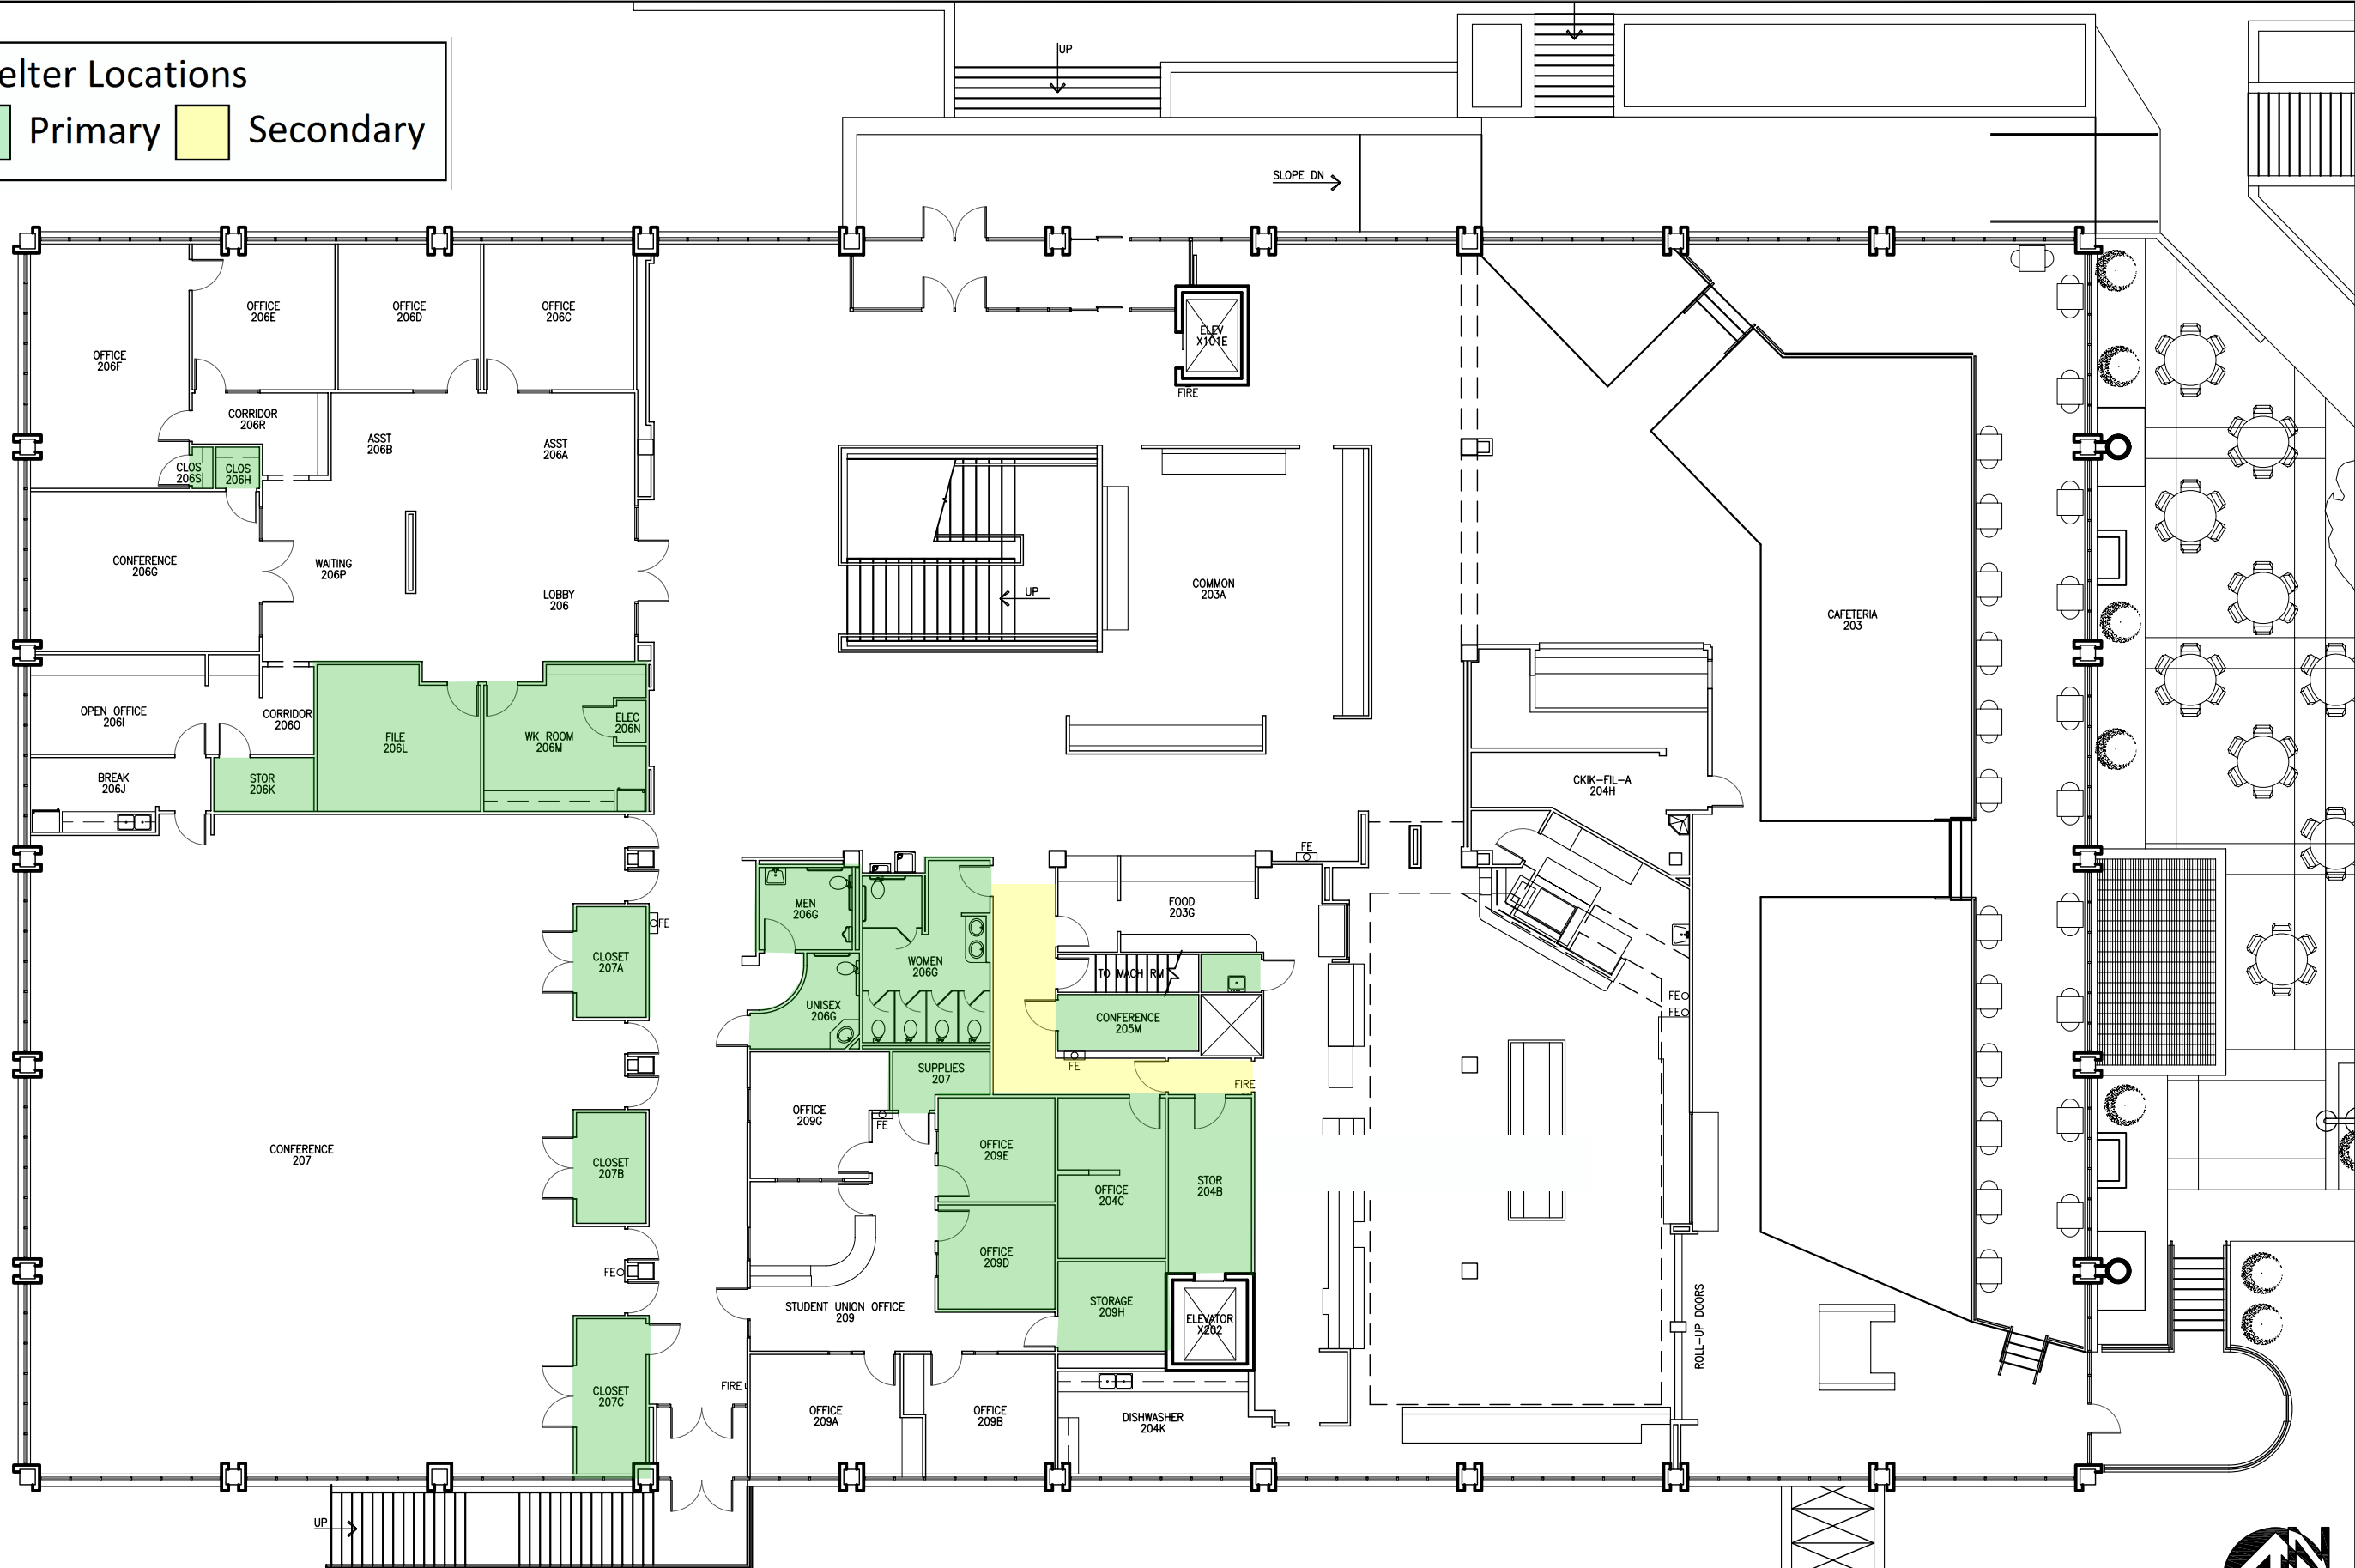


1 STUDENT CENTER BUILDING  
2ND FLOOR PLAN

SCALE: 1/16" = 1'-0"

GRAPHIC SCALE



LEGEND	
	FIRE PULL
	FIRE EXTINGUISHER
	FIRE EXTINGUISHER
	FIRE EXTINGUISHER

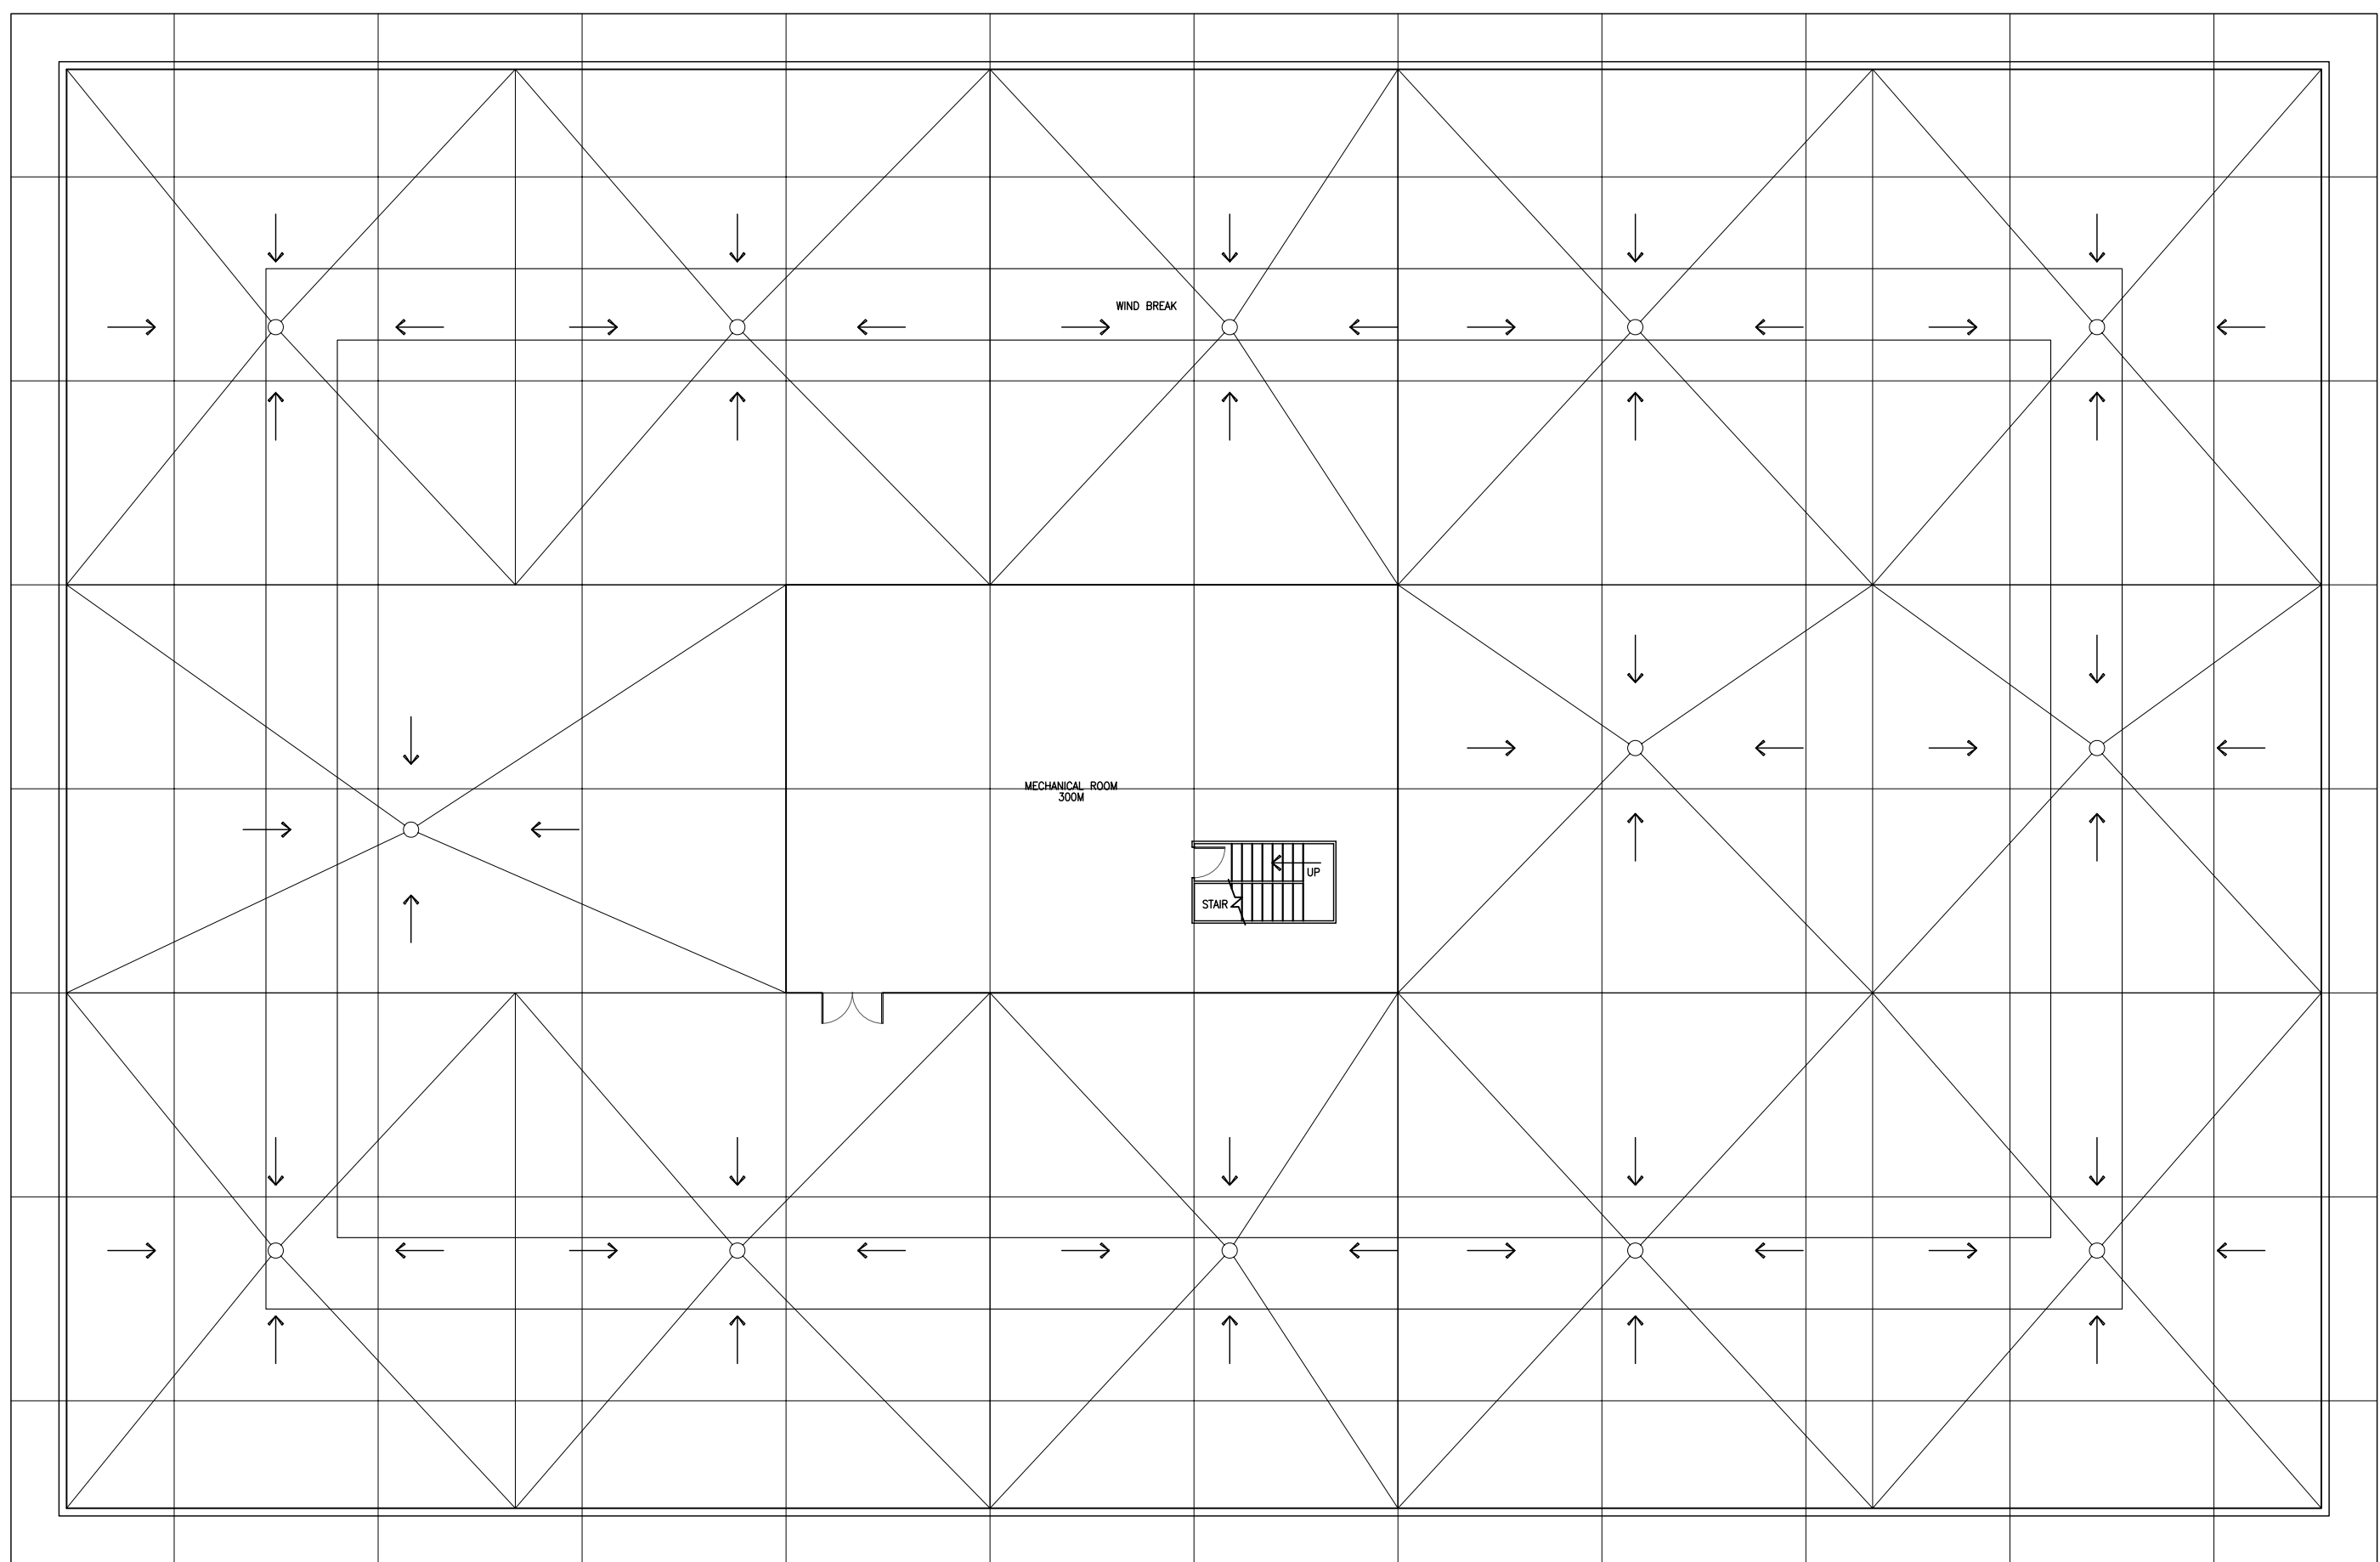

1 STUDENT CENTER BUILDING  
ROOF PLAN

SCALE: 1/16" = 1'-0"



LEGEND	
FIRE PULL	FIRE=
FIRE EXTINGUISHER	FE O